



Republic of the Philippines
GENERAL SANTOS CITY WATER DISTRICT
 E. Fernandez Street, Barangay Lagao General Santos
 Telephone No.: 552-3824; Telefax No.: 553-4960
 Email Address: gscwdprocurement@yahoo.com

GPM-014-2

REQUEST FOR QUOTATION

RFQ #: 3-0220-025 DATE: 02/11/2020

SUPPLIER: _____
 ADDRESS: _____
 TELEPHONE NO. : _____
 TIN NO. : _____

Dear Sir/Madam,

Pls. quote your lowest price on the item/s listed below subject to general condition stating the shortest time of delivery and submit your quotation duly signed by your representative not later than 02/17/2020, Pls. furnish this office the following articles subject to the terms and conditions contained therein.

ITEM NO.	DESCRIPTION	QTY.	UNIT	UNIT PRICE
1	CONSTRUCTION/LABOR AND MATERIALS : PLEASE SEE ATTACHED SCOPE OF WORK-ABC: PHP 57156.40 ##### nothing follows #####	1	LOT	P

Date of Delivery: _____
 Price Validity : _____
 Terms of Payment: _____

Place of Delivery: GSCWD Bodega
 *****No partial delivery allowed*****
 Note: 6% WITHHOLDING TAX DEDUCTION
 PR NO.:

Requested by:

Price quoted by:

 


Agnes P. Tampico
 SIRDO - A


 Supplier

 Date




 **PERSPECTIVE**

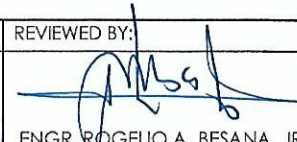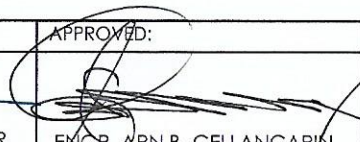
GENERAL SANTOS CITY WATER DISTRICT RIVANDEZ STREET, BRGY. LAGAO, GEN. SANTOS CITY ENGINEERING & CONSTRUCTION DEPARTMENT PLANNING AND DESIGN DIVISION TEL. NO.: (083) 552 - 3824	PROJECT AND LOCATION	CONFORMED BY:	REVIEWED BY:	APPROVED:	SHEET CONTENTS	SHEET NO.
	SEEDLINGS PRODUCTION ELEVATED BED	 ENGR. MARKO L. DELEOBILLO WATERSHED FORESTER	 ENGR. ROGELIO A. BESANA, JR. MANAGER A - ECD	 ENGR. ARN B. GELLANGARIN GENERAL MANAGER A	AS SHOWN	1/
	LOCATION : PUROK GOLINGAN, MABUHAY, GSC					DRAWN BY: RRA CHECKED BY: MGG REV. NO. DATE : JAN. 2020

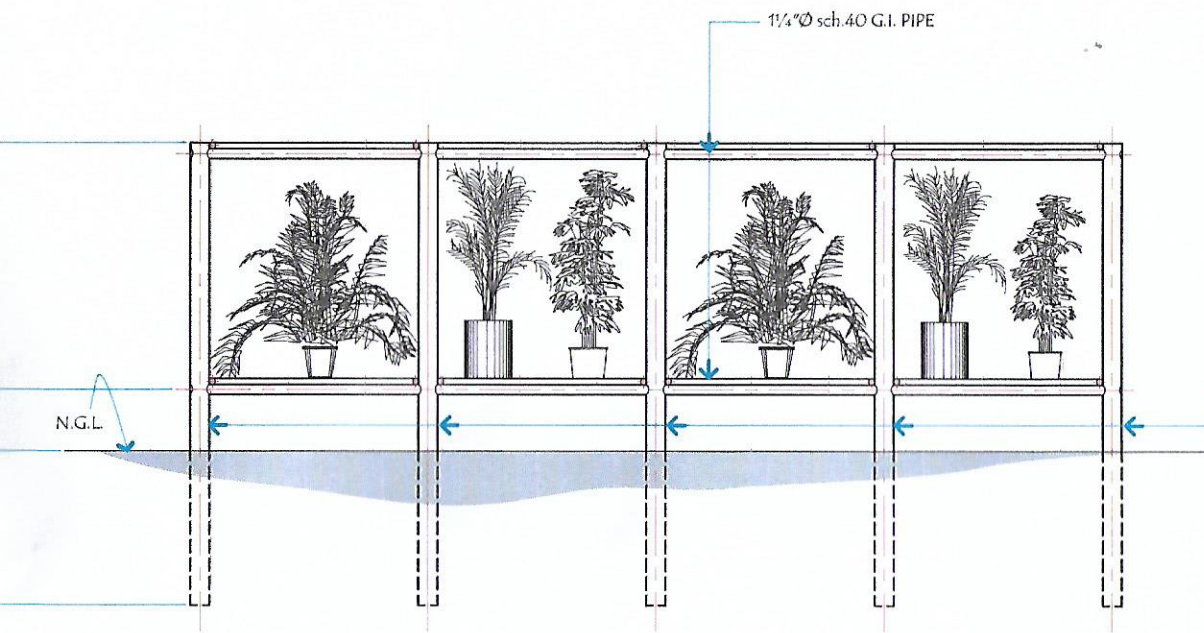

FRONT ELEVATION
SCALE: 1 : 25m

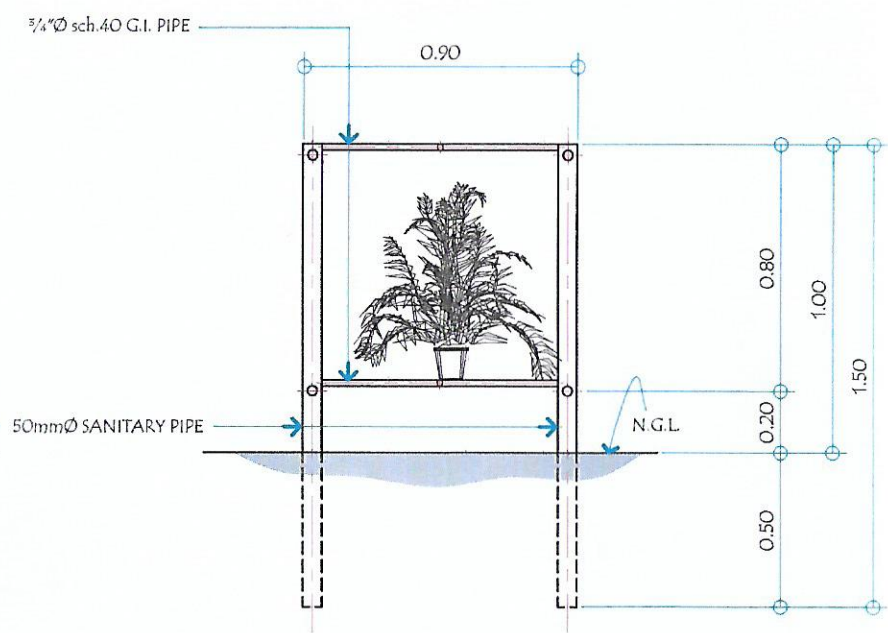

TYPICAL END ELEVATION
SCALE: 1 : 25m

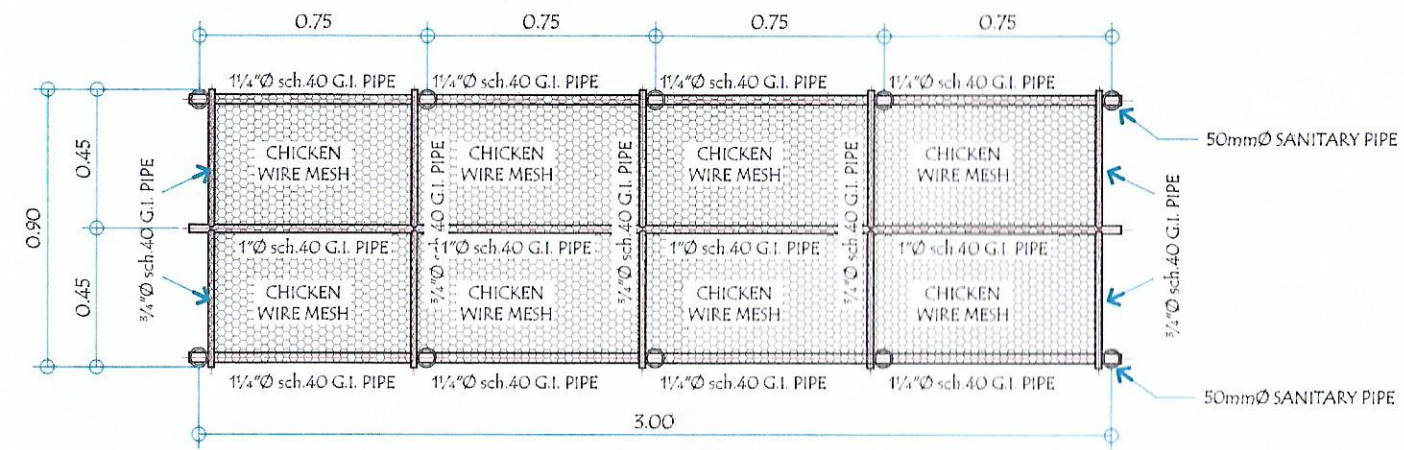

PLAN
SCALE: 1 : 25m

NOTE :
- G.I. PIPES AND CHICKEN WIRE MESH SHALL BE PRIMER PAINT FINISH

GENERAL SANTOS CITY WATER DISTRICT
FRANDEZ STREET, BRGY. LAGAO, GEN. SANTOS CITY
ENGINEERING & CONSTRUCTION DEPARTMENT
PLANNING AND DESIGN DIVISION
TEL. NO.: (083) 552 - 3824

PROJECT AND LOCATION
SEEDLINGS PRODUCTION ELEVATED BED
LOCATION : PUROK GOLINGAN, MABUHAY, GSC

CONFORMED BY:

ENGR. MARIO L. PELOBILLO
WATERSHED FORESTER

REVIEWED BY:

ENGR. ROGELIO A. BESANA, JR.
MANAGER A - ECD

APPROVED:

ENGR. ARNAB GELLANGARIN
GENERAL MANAGER A

SHEET CONTENTS
AS SHOWN
DRAWN BY: RRA
CHECKED BY: MGG
REV. NO.
DATE : JAN. 2020

SHEET NO.
2/