



Republic of the Philippines  
**GENERAL SANTOS CITY WATER DISTRICT**  
 E. Fernandez Street, Barangay Lagao General Santos  
 Telephone No.: 552-3824; Telefax No.: 553-4960  
 Email Address: gscwdprocurement@yahoo.com

GPM-014-2

**REQUEST FOR QUOTATION**

RFQ #: 3-0821-046      DATE: 09/24/2021

SUPPLIER: \_\_\_\_\_  
 ADDRESS: \_\_\_\_\_  
 TELEPHONE NO. : \_\_\_\_\_  
 TIN NO. : \_\_\_\_\_

 
Dear Sir/Madam,

Pls. quote your lowest price on the item/s listed below subject to general condition stating the shortest time of delivery and submit your quotation duly signed by your representative not later than 09/30/2021, Pls. furnish this office the following articles subject to the terms and conditions contained therein.


ITEM NO.	DESCRIPTION	QTY.	UNIT	UNIT PRICE
1	LABOR (FABRICATION) : PLEASE SEE ATTACHED (ABC: PHP 190,617.00) ##### nothing follows #####	1	LOT	P

Date of Delivery: \_\_\_\_\_  
 Price Validity : \_\_\_\_\_  
 Terms of Payment: \_\_\_\_\_


Place of Delivery: GSCWD Bodega  
 \*\*\*\*\*No partial delivery allowed\*\*\*\*\*  
 Note: 6% WITHHOLDING TAX DEDUCTION  
 PR NO.: 0821-026

Requested by:  
  
**GESEM R. CABAÑERO**  
 MATERIAL PROCUREMENT OFFICER A

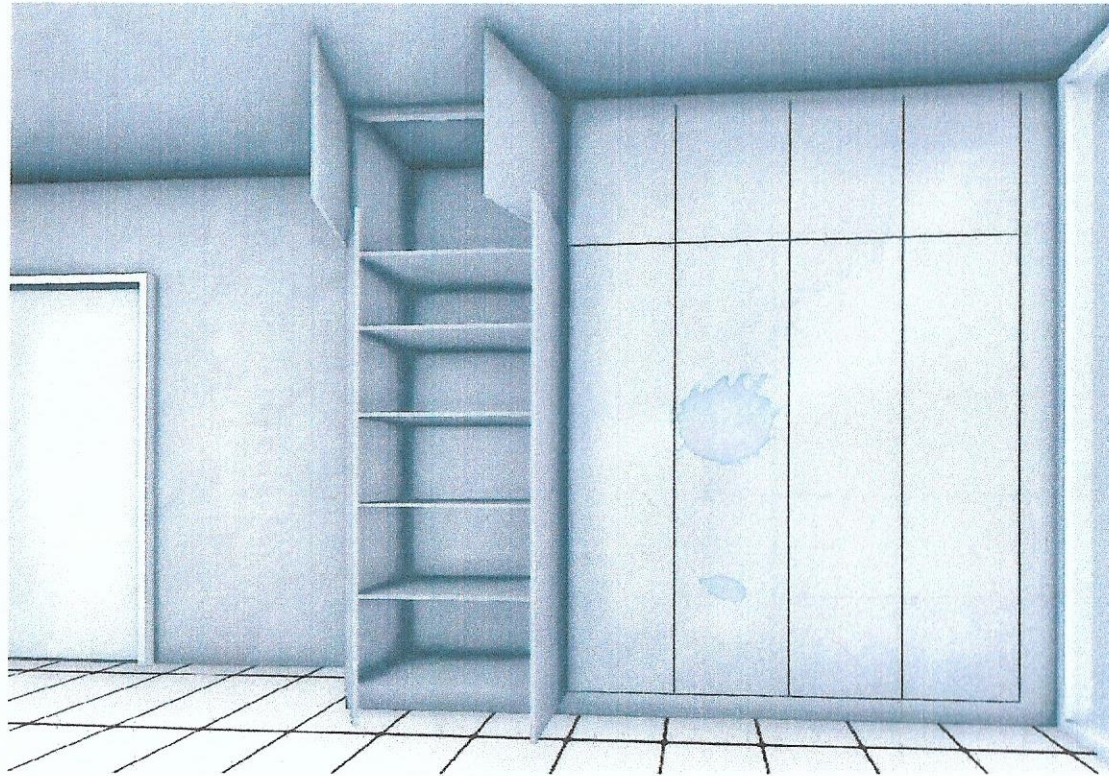


Price quoted by:  
 \_\_\_\_\_  
 Supplier  
 \_\_\_\_\_  
 Date

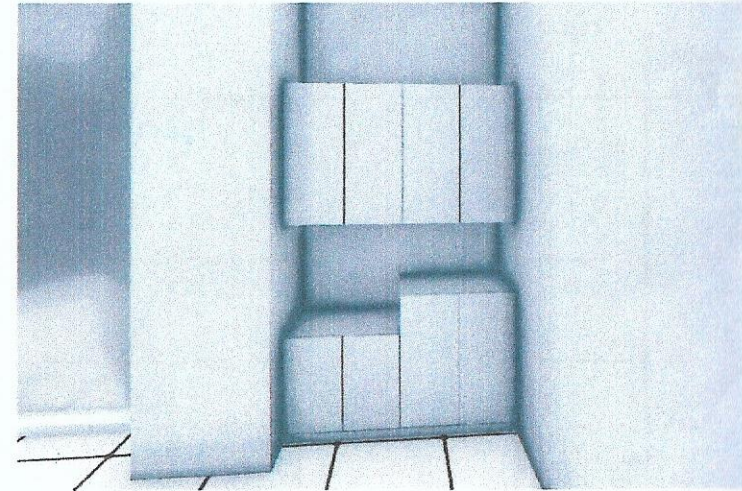


○ PERSPECTIVE (CABINET-1)




○ PERSPECTIVE (CABINET-2)

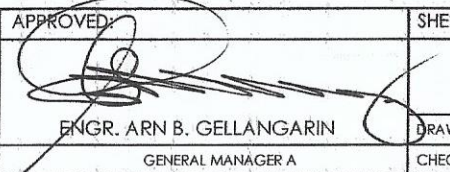
 <p><b>GENERAL SANTOS CITY WATER DISTRICT</b>          * E. FERNANDEZ STREET, BRGY. LAGAO, GEN. SANTOS CITY          ENGINEERING &amp; CONSTRUCTION DEPARTMENT          PLANNING AND DESIGN DIVISION          TEL. NO.: (083) 552 - 3824</p>	PROJECT AND LOCATION	CHECKED BY:	APPROVED:	SHEET CONTENTS	
	CONSTRUCTION OF OGM'S MODULAR CABINETS	 REVIE GIANNE F. TINIO SUPERVISING INTERNAL CONTROL OFFICER	 ENGR. ARN B. GELLANGARIN GENERAL MANAGER A	AS SHOWN	
	LOCATION : OGM, ADMIN BLDG.				DRAWN BY: RRA
				CHECKED BY: RAG	DATE : JULY 2021

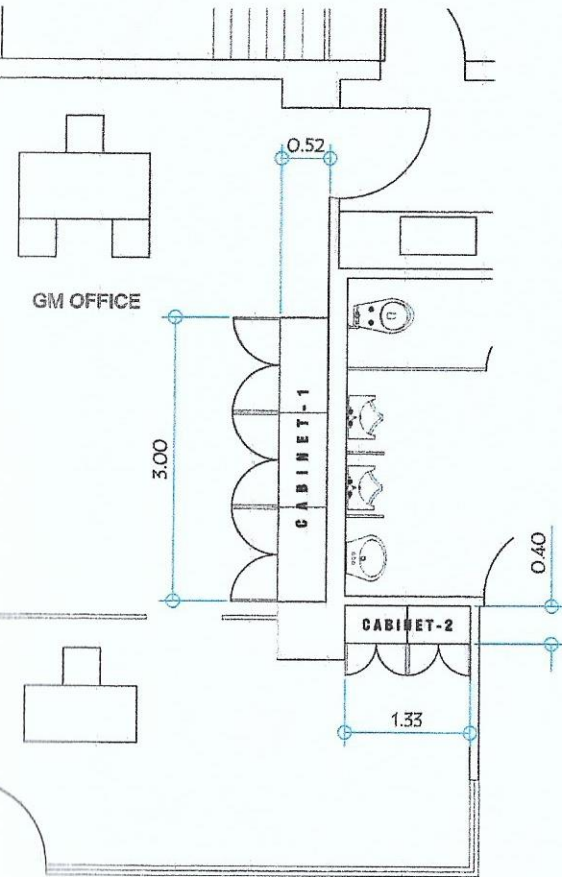

**LOCATION PLAN**  
SCALE: 1:80 M

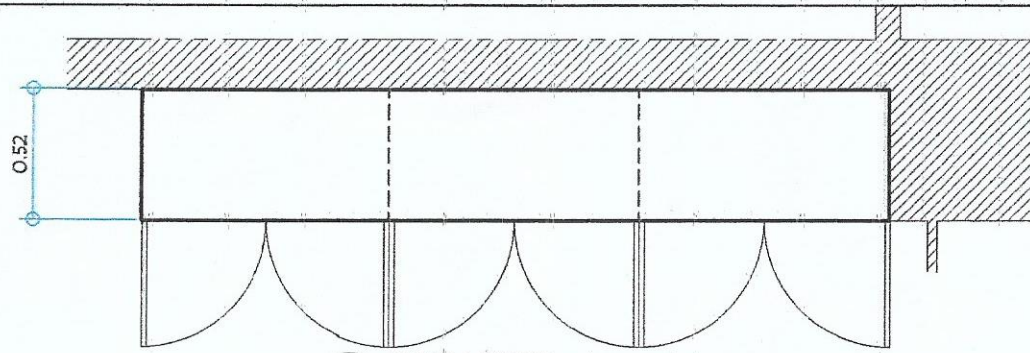


**TOP VIEW (CABINET-1)**  
SCALE: 1:30 M

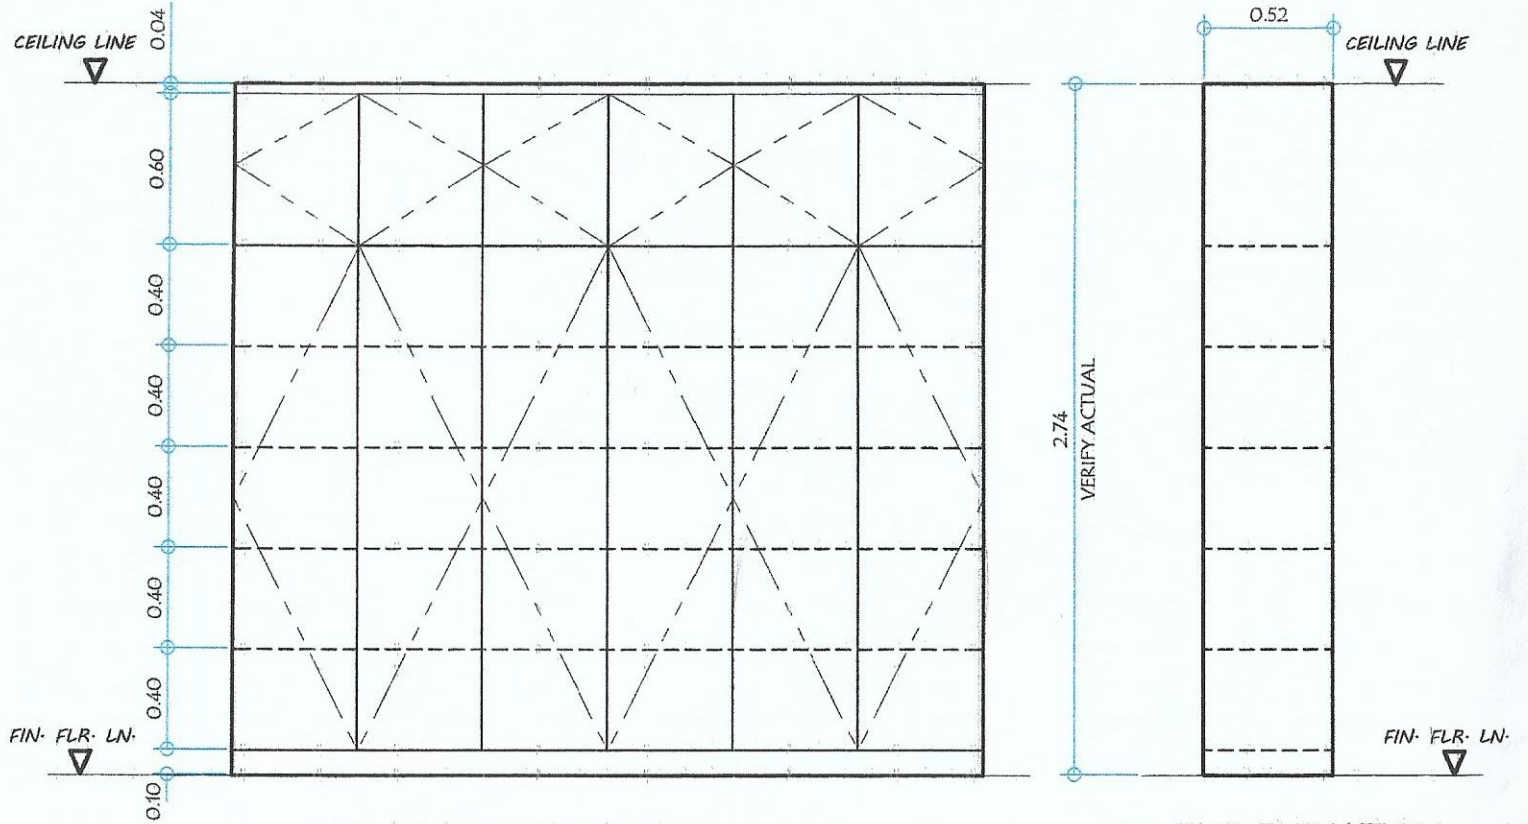


**FRONT ELEVATION (CABINET-1)**  
SCALE: 1:30 M

**END ELEVATION (CABINET-1)**  
SCALE: 1:30 M


PROJECT AND LOCATION	CHECKED BY:	APPROVED:	SHEET CONTENTS		SHEET NO.
CONSTRUCTION OF OGM'S MODULAR CABINETS	REVIE CHIANNE F. TINIO SUPERVISING INTERNAL CONTROL OFFICER	ENGR. ARN B. GELLANGARIN GENERAL MANAGER A	AS SHOWN		2/3
LOCATION: OGM., ADMIN BLDG.			DRAWN BY: RRA	REV. NO.	
			CHECKED BY: RAG	DATE: JULY 2021	

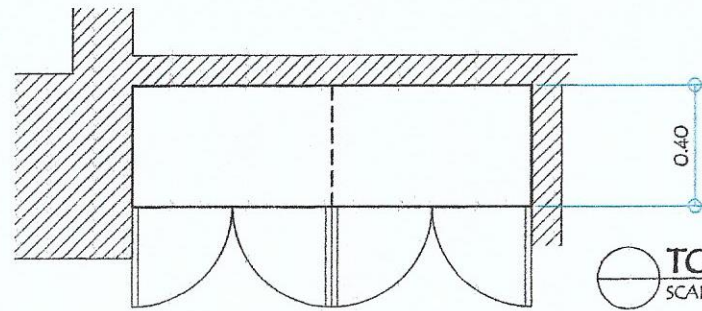

TOP VIEW (CABINET-2)  
SCALE: 1:25 M

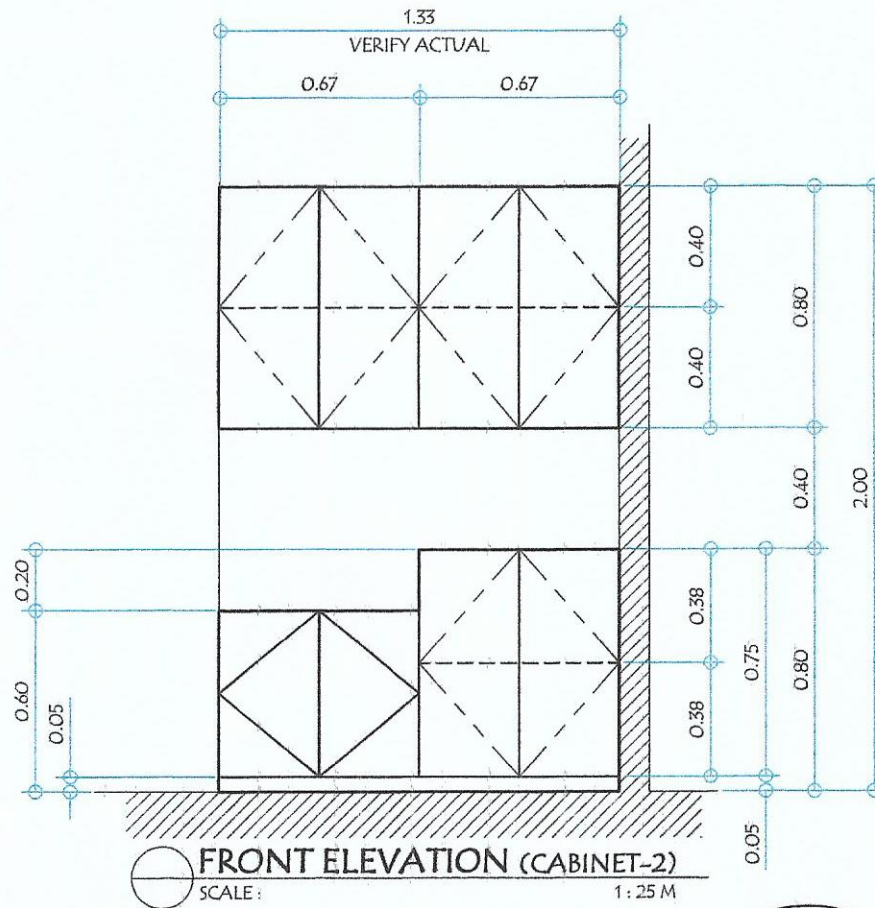

FRONT ELEVATION (CABINET-2)  
SCALE: 1:25 M

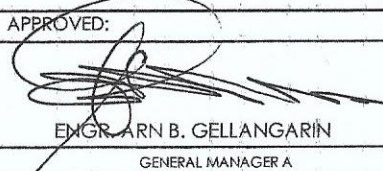GENERAL SANTOS CITY WATER DISTRICT	PROJECT AND LOCATION	CHECKED BY:	APPROVED:	SHEET CONTENTS	SHEET NO.
FINANDEZ STREET, BRGY. LAGAO, GEN. SANTOS CITY ENGINEERING & CONSTRUCTION DEPARTMENT PLANNING AND DESIGN DIVISION TEL. NO.: (083) 552 - 3824	CONSTRUCTION OF OGM'S MODULAR CABINETS  LOCATION: OGM, ADMIN BLDG.	REVIE GIANNIE P. TINIO SUPERVISING INTERNAL CONTROL OFFICER	 ENGR. ARN B. GELLANGARIN GENERAL MANAGER A	AS SHOWN  DRAWN BY: RRA      REV. NO. CHECKED BY: RAG      DATE: JULY 2021	3/3