



Republic of the Philippines
GENERAL SANTOS CITY WATER DISTRICT
E. Fernandez Street, Barangay Lagao General Santos
Telephone No.: 552-3824; Telefax No.: 553-4960
Email Address: gscwdprocurement@yahoo.com

GPM-014-2

REQUEST FOR QUOTATION

RFQ #: 3-0821-046 DATE: 08/24/2021

SUPPLIER: _____
ADDRESS: _____
TELEPHONE NO. : _____
TIN NO. : _____

Dear Sir/Madam,

Pls. quote your lowest price on the item/s listed below subject to general condition stating the shortest time of delivery and submit your quotation duly signed by your representative not later than 08/30/2021, Pls. furnish this office the following articles subject to the terms and conditions contained therein.

ITEM NO.	DESCRIPTION	QTY.	UNIT	UNIT PRICE
1	LABOR (FABRICATION) : PLEASE SEE ATTACHED (ABC: PHP 143,602.20 ##### nothing follows #####	1	LOT	P

Date of Delivery: _____
Price Validity : _____
Terms of Payment: _____

Place of Delivery: **GSCWD Bodega**
*******No partial delivery allowed******
Note: 6% WITHHOLDING TAX DEDUCTION
PR NO.: 0821-026


Requested by:

Price quoted by:


ANDREW H. NADAL JR.
Administration Services Assistant A

Supplier

Date

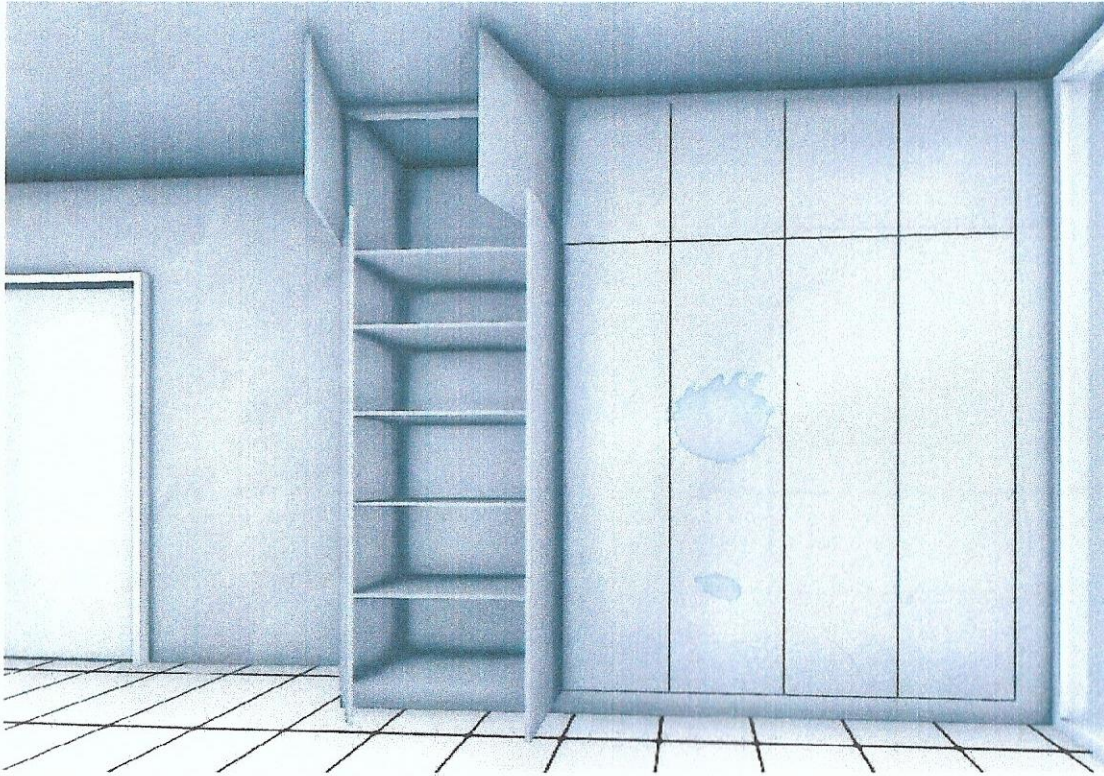


○ PERSPECTIVE (CABINET-1)

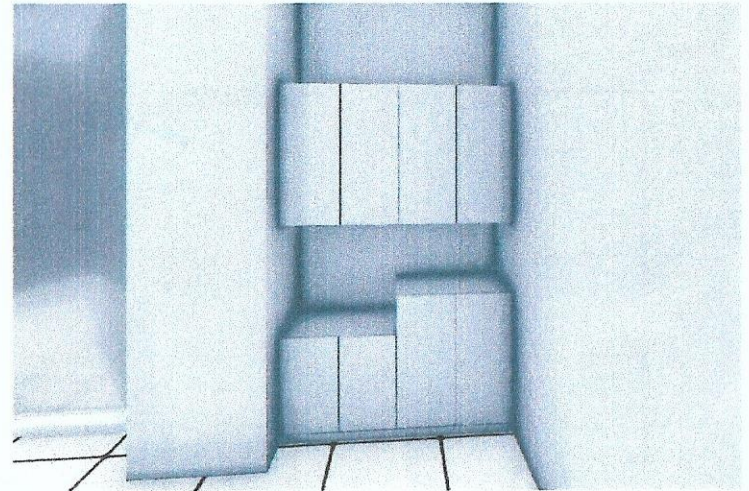


○ PERSPECTIVE (CABINET-2)


 GENERAL SANTOS CITY WATER DISTRICT E. FERNANDEZ STREET, BRGY. LAGAO, GEN. SANTOS CITY ENGINEERING & CONSTRUCTION DEPARTMENT PLANNING AND DESIGN DIVISION TEL. NO.: (083) 552 - 3824	PROJECT AND LOCATION	CHECKED BY:	APPROVED:	SHEET CONTENTS		SHEET NO.
	CONSTRUCTION OF OGM'S MODULAR CABINETS	 REVIE GIANNE F. TINIO SUPERVISING INTERNAL CONTROL OFFICER	 ENGR. ARN B. GELLANGARIN GENERAL MANAGER A	AS SHOWN		1/3
	LOCATION : OGM, ADMIN BLDG.			DRAWN BY: RRA	REV. NO.	
				CHECKED BY: RAG	DATE : JULY 2021	

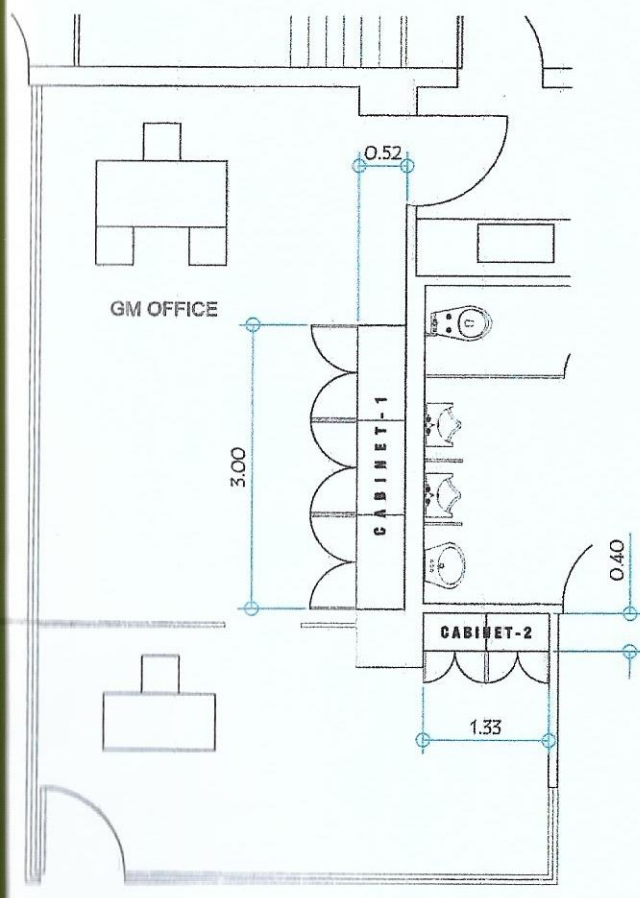


LOCATION PLAN
SCALE: 1:80 M

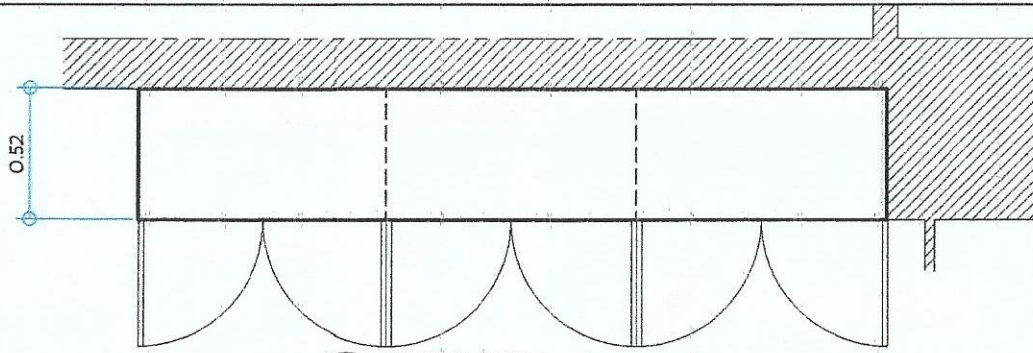

TOP VIEW (CABINET-1)
SCALE: 1:30 M

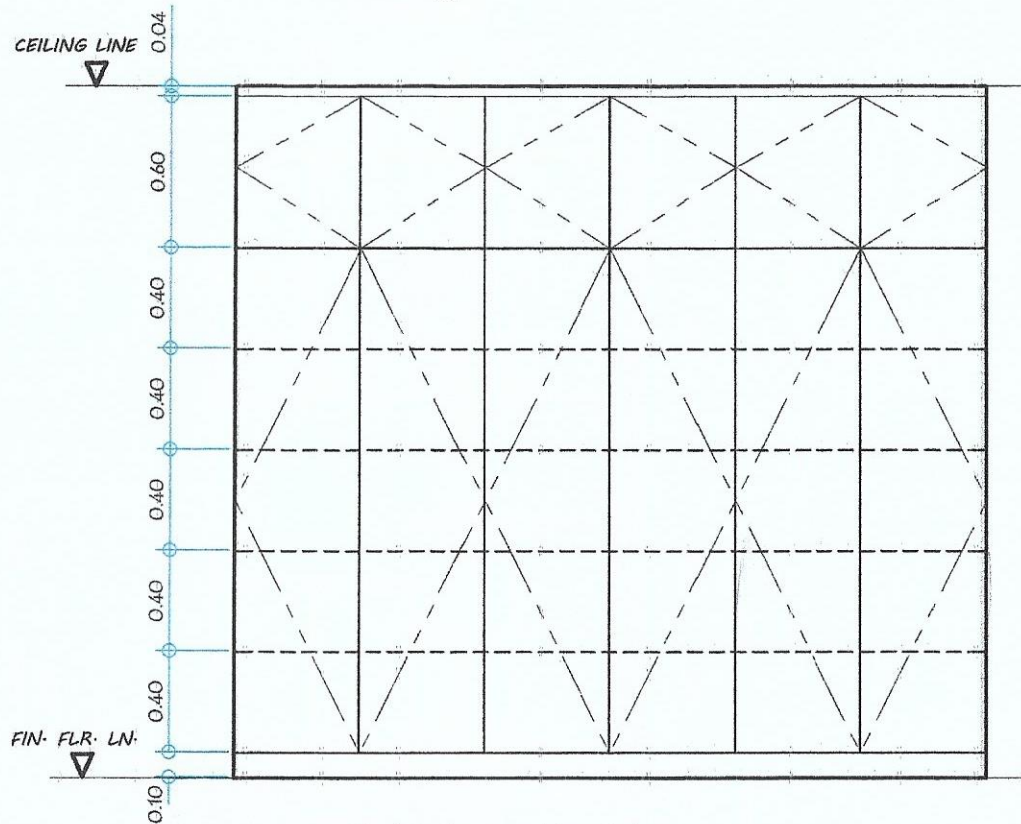


FRONT ELEVATION (CABINET-1)
SCALE: 1:30 M

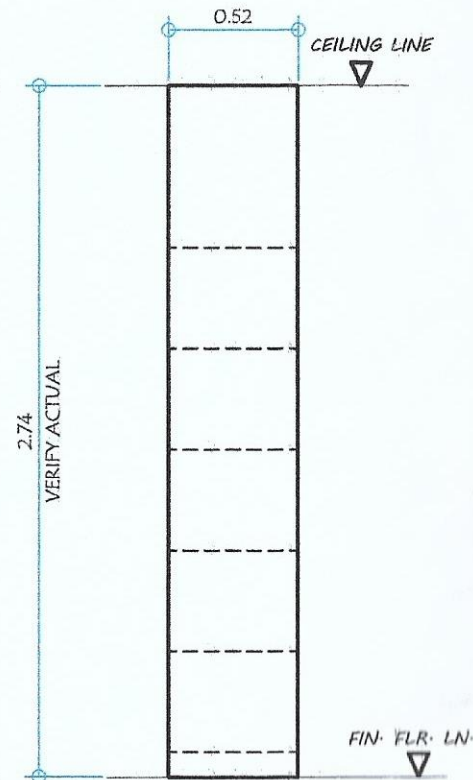


END ELEVATION (CABINET-1)
SCALE: 1:30 M

<p>GENERAL SANTOS CITY WATER DISTRICT E. FERNANDEZ STREET, BRGY. LAGAO, GEN. SANTOS CITY ENGINEERING & CONSTRUCTION DEPARTMENT PLANNING AND DESIGN DIVISION TEL. NO.: (083) 552 - 3824</p>	PROJECT AND LOCATION	CHECKED BY:	APPROVED:	SHEET CONTENTS		SHEET NO.
	CONSTRUCTION OF OGM'S MODULAR CABINETS	REVIE CHANNE F. TINIO SUPERVISING INTERNAL CONTROL OFFICER	ENGR. ARN B. GELLANGARIN GENERAL MANAGER A	AS SHOWN		2/3
	LOCATION: OGM., ADMIN BLDG.			DRAWN BY: RRA CHECKED BY: RAG	REV. NO. DATE: JULY 2021	

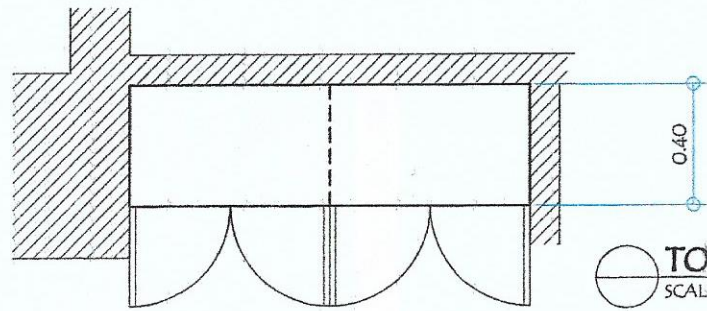

TOP VIEW (CABINET-2)
SCALE: 1:25 M

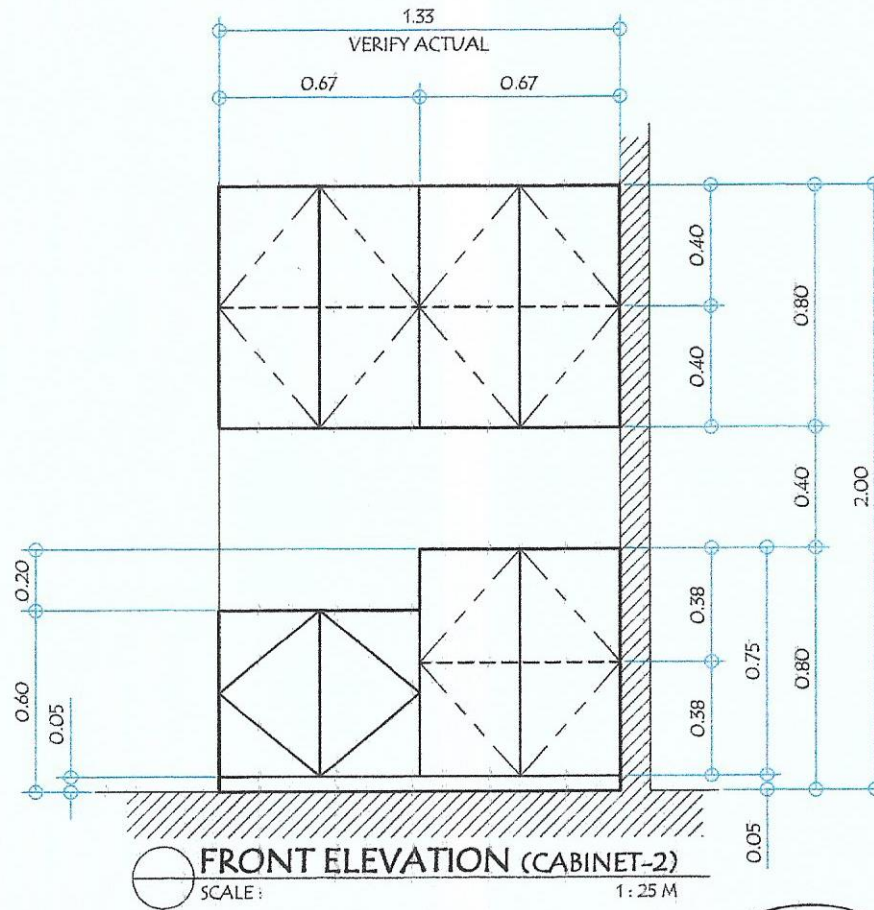

FRONT ELEVATION (CABINET-2)
SCALE: 1:25 M

GENERAL SANTOS CITY WATER DISTRICT
E. FERNANDEZ STREET, BRGY. LAGAO, GEN. SANTOS CITY
ENGINEERING & CONSTRUCTION DEPARTMENT
PLANNING AND DESIGN DIVISION
TEL. NO.: (083) 552 - 3024

PROJECT AND LOCATION	CHECKED BY:	APPROVED:	SHEET CONTENTS		SHEET NO.
CONSTRUCTION OF OGM'S MODULAR CABINETS	REVIE GIANNIE P. TINIO SUPERVISING INTERNAL CONTROL OFFICER	ENGR. ARN B. GELLANGARIN GENERAL MANAGER A	AS SHOWN		3/3
			DRAWN BY: RRA	REV. NO.	
LOCATION: OGM, ADMIN BLDG.			CHECKED BY: RAG	DATE: JULY 2021	