

OFFICE OF THE BUILDING OFFICIAL

LAND USE & ZONING

LINE AND GRADE

ARCHITECTURAL

STRUCTURAL


SANITARY

ELECTRICAL

MECHANICAL

ELECTRONICS

SHEET NO.		01	05
AS PER PLAN			
DRAWN BY:	TTP	REV. NO.	1ST
CHECKED BY:	MCID	DATE:	04/22/2022

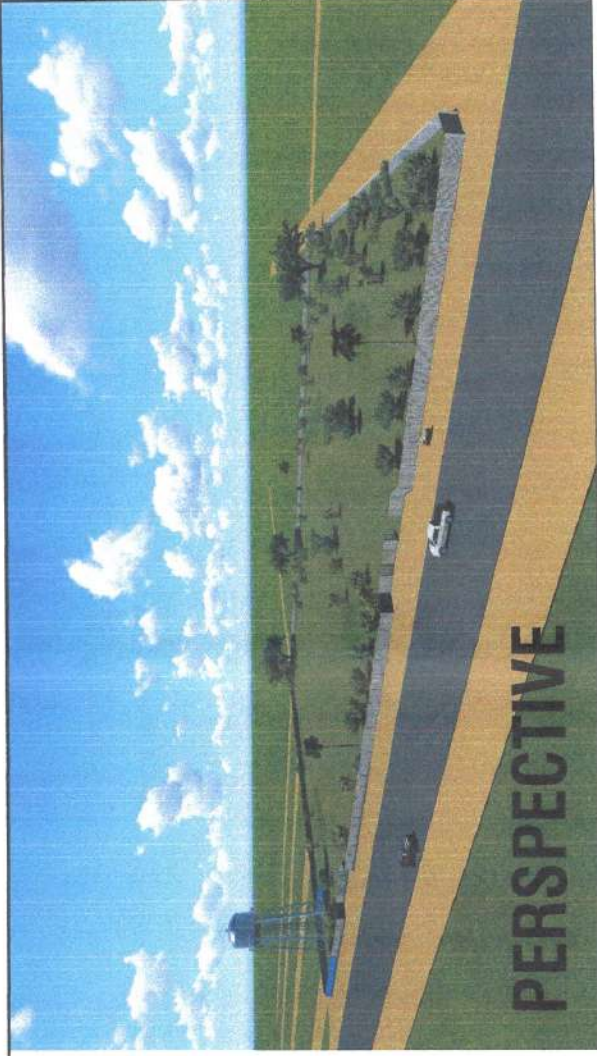

THIS SITE




LOCATION SITE

THIS LOT



VICINITY MAP

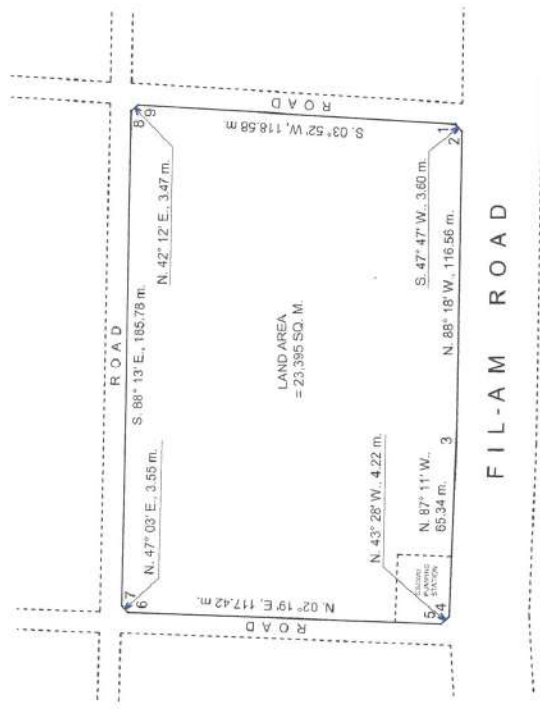


SITE DEVELOPMENT PLAN  
SCALE: 1:12,000  
MTRS

TITLE:	PROPOSED CONSTRUCTION OF PERIMETER FENCE	CHECKED:	ENGR. MARIA CELIA N. DANDAN	REVIEWED:	ENGR. ARN B. GELLANGARIN	APPROVED:	ENGR. ARN B. GELLANGARIN
REG. NO.	0107945	PTER. NO.	61673A	TIN. NO.	39-941-697	DATE:	01/12/2021
GENERAL SANTOS CITY WATER DISTRICT E. FERMANEZ STREET, BRGY. LAGAO, GEN. SANTOS CITY ENGINEERING & CONSTRUCTION DEPARTMENT PLANNING AND DESIGN DIVISION TEL. NO.: (083) 552-3824		DANILCO M. HORLADOR, JR. CIVIL ENGINEER		AGM - Operations & Technical Services			

GENERAL SANTOS CITY WATER DISTRICT  
- 1997 -


CONTENTS:

SHEET NO.		01	05
AS PER PLAN			
DRAWN BY:	TTP	REV. NO.	1ST
CHECKED BY:	MCID	DATE:	04/22/2022

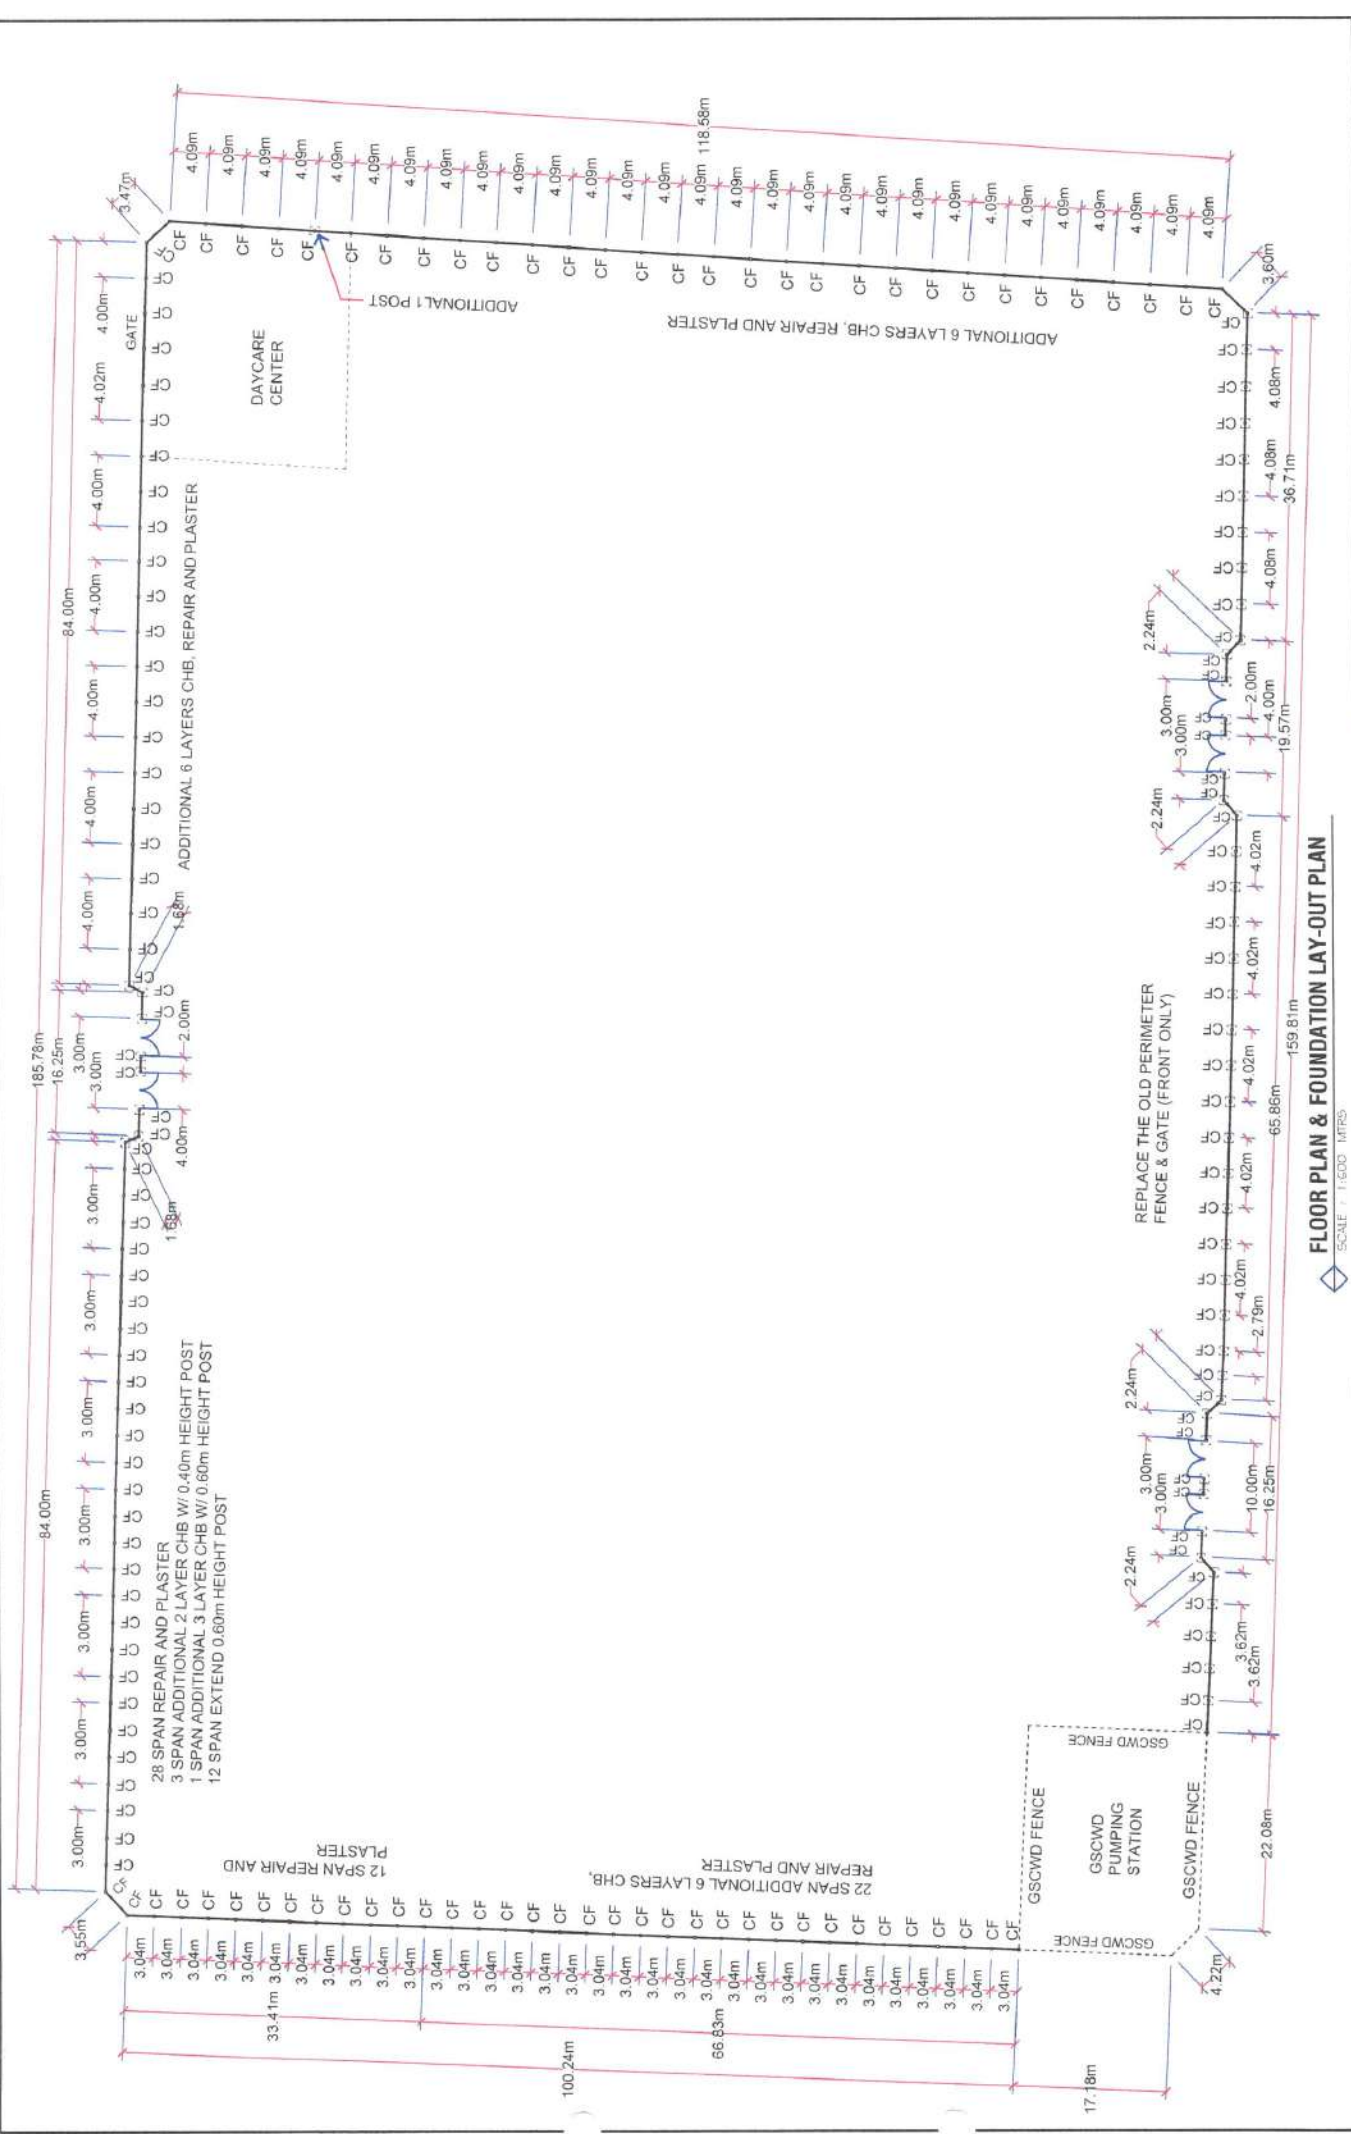


**FLOOR PLAN & FOUNDATION LAY-OUT PLAN**  
 SCALE: 1" = 100' MTRS


<p><b>GENERAL SANTOS CITY WATER DISTRICT</b>          E. FERNADEZ STREET, BRGY. LAGAO, GEN. SANTOS CITY          ENGINEERING &amp; CONSTRUCTION DEPARTMENT          PLANNING AND DESIGN DIVISION          TEL. NO.: (083) 552-3824</p>	<p><b>DANILO M. HORLADOR, JR.</b>          CIVIL ENGINEER</p> <p>REG. NO.: 0101546          PTR. NO.: 61873A</p>	<p>TIN. NO.: 391-841-997          DATE: 01/12/2021</p>	<p><b>PROPOSED CONSTRUCTION OF PERIMETER FENCE</b></p> <p>ENGR. MARY CELIA N. DANDAN          Designing &amp; Design Division</p>	<p>ENGR. ROGELIO A. BESANA, JR.          ACM - Operators &amp; Technical Services</p>	<p>ENGR. ARN B. GELLANGARIN          General Manager A</p>	<p>AS PER PLAN</p>	<p>SHEET NO. <b>02</b>  <b>05</b></p>
	<p>REG. NO.: 0101546          PTR. NO.: 61873A</p>	<p>TIN. NO.: 391-841-997          DATE: 01/12/2021</p>	<p>ENGR. MARY CELIA N. DANDAN          Designing &amp; Design Division</p>	<p>ENGR. ROGELIO A. BESANA, JR.          ACM - Operators &amp; Technical Services</p>	<p>ENGR. ARN B. GELLANGARIN          General Manager A</p>	<p>AS PER PLAN</p>	<p>SHEET NO. <b>02</b>  <b>05</b></p>

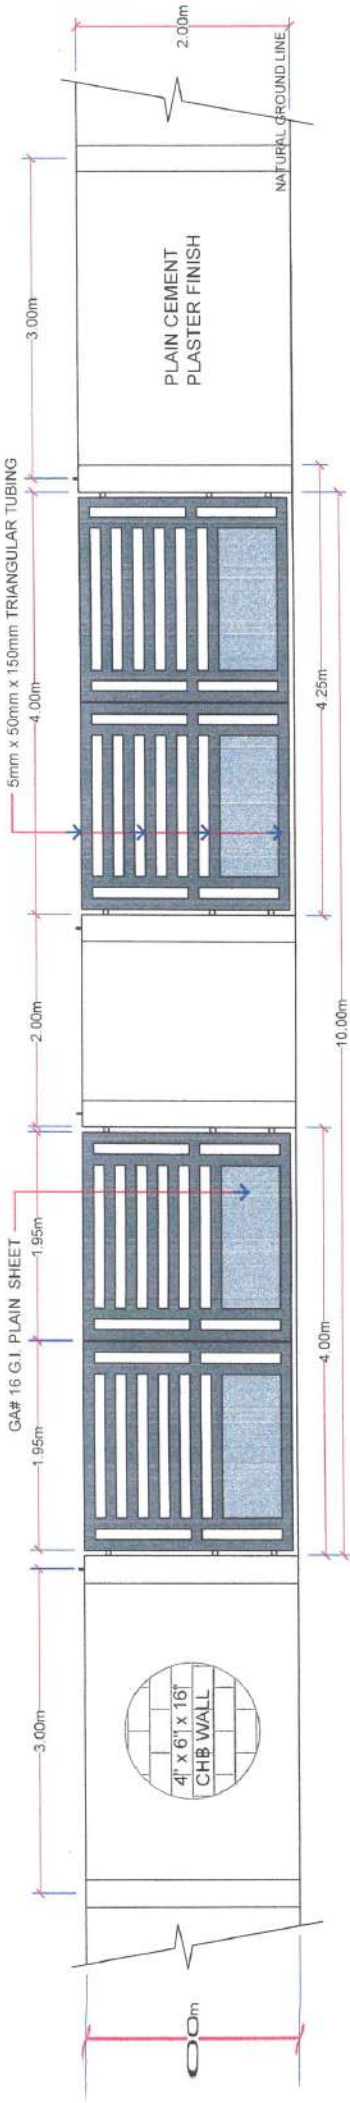


**GATE ELEVATION PLAN**  
SCALE: 1/150' M/FPS

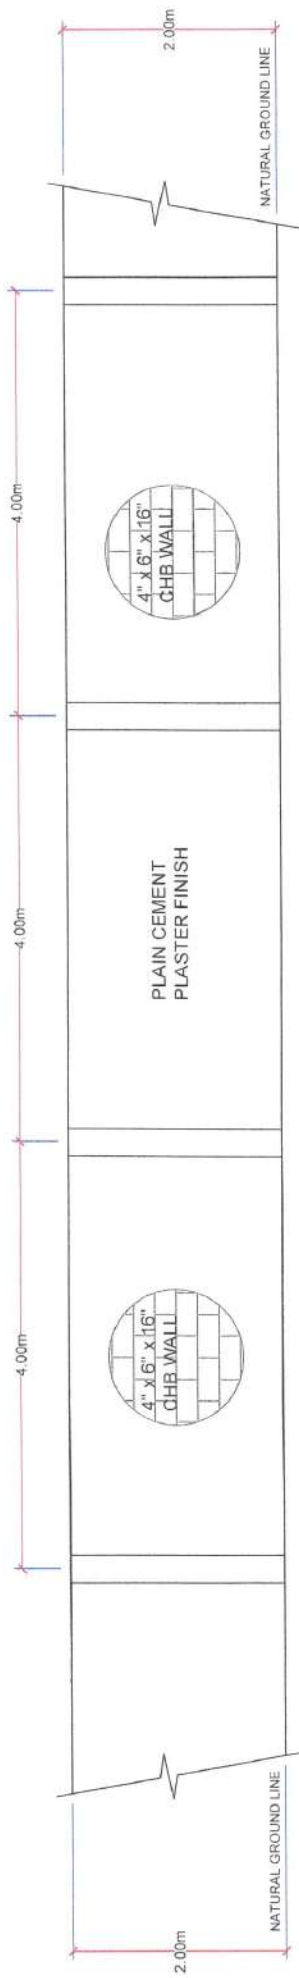


**WALL ELEVATION**  
SCALE: 1/150' M/FPS

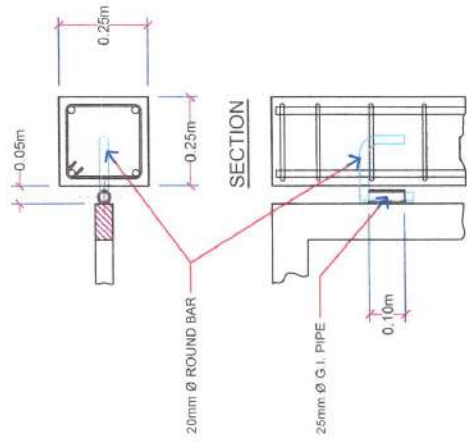

**DETAIL "C" FAB. HINGES**  
SCALE: 1/25' M/FPS

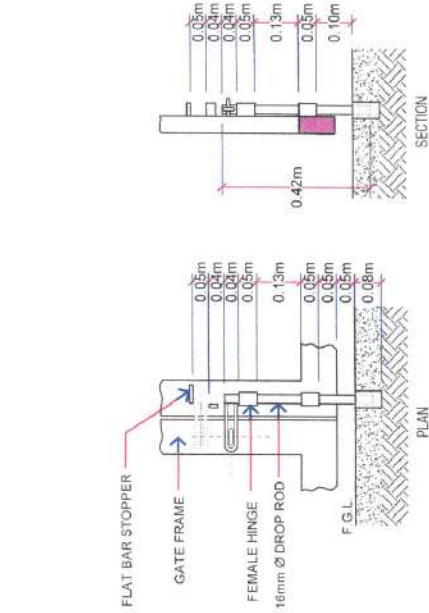

**DETAIL "A" FAB. BARREL BOLT**

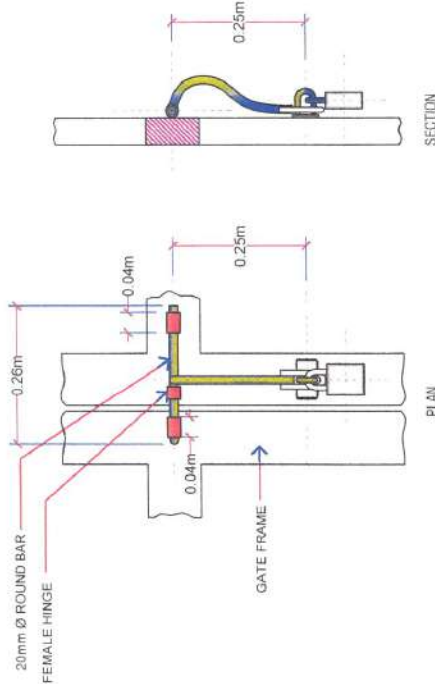

**DETAIL "B" FAB. BARREL BOLT**



**GENERAL SANTOS CITY WATER DISTRICT**  
E. FERNANDEZ STREET, BRGY. LAGAO, GEN. SANTOS CITY  
ENGINEERING & CONSTRUCTION DEPARTMENT  
PLANNING AND DESIGN DIVISION  
TEL. NO.: (083) 552-3824

REG. NO. 010745  
PTR. NO. 61873A  
DATE: 01/12/2021

**DANILO HORLADOR, JR.**  
CIVIL ENGINEER  
TIN NO. 291-841-987  
DATE: 01/12/2021

TITLE: **PROPOSED CONSTRUCTION OF PERIMETER FENCE**  
ZONE 11.8: BRGY. FATIMA, GENERAL SANTOS CITY.


CHECKED: *[Signature]*  
ENGR. MARIA CELIA N. DANDAN  
DC - Planning & Design Division

REVIEWED: *[Signature]*  
ENGR. ROGELIO A. BESANA, JR.  
AGM - Operations & Technical Services


APPROVED: *[Signature]*  
General Manager A  
ENGR. ARN B. GELLANGAPIN  
DESIGN BY: TTP  
CHECKED BY: MAND  
DATE: 04/22/2022

AS PER PLAN  
REV. NO. 1ST  
DATE: 04/22/2022


SHEET NO. **03**  
**05**

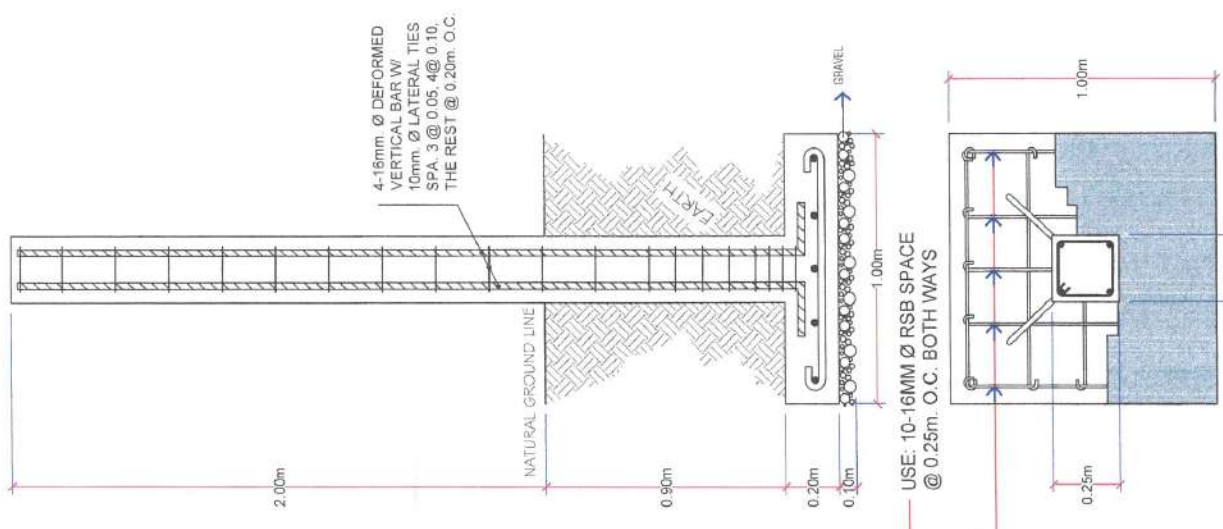

**CF DETAIL**  
SCALE: 1:120 METERS

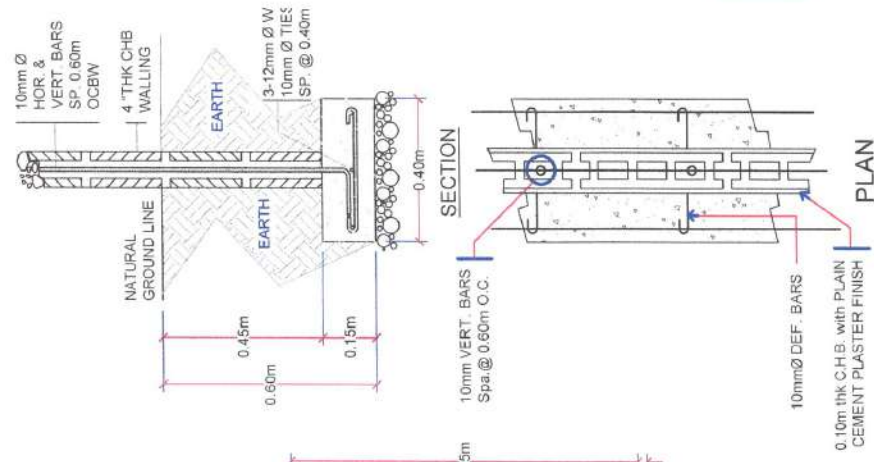

**WF DETAIL**  
SCALE: 1:15 METERS

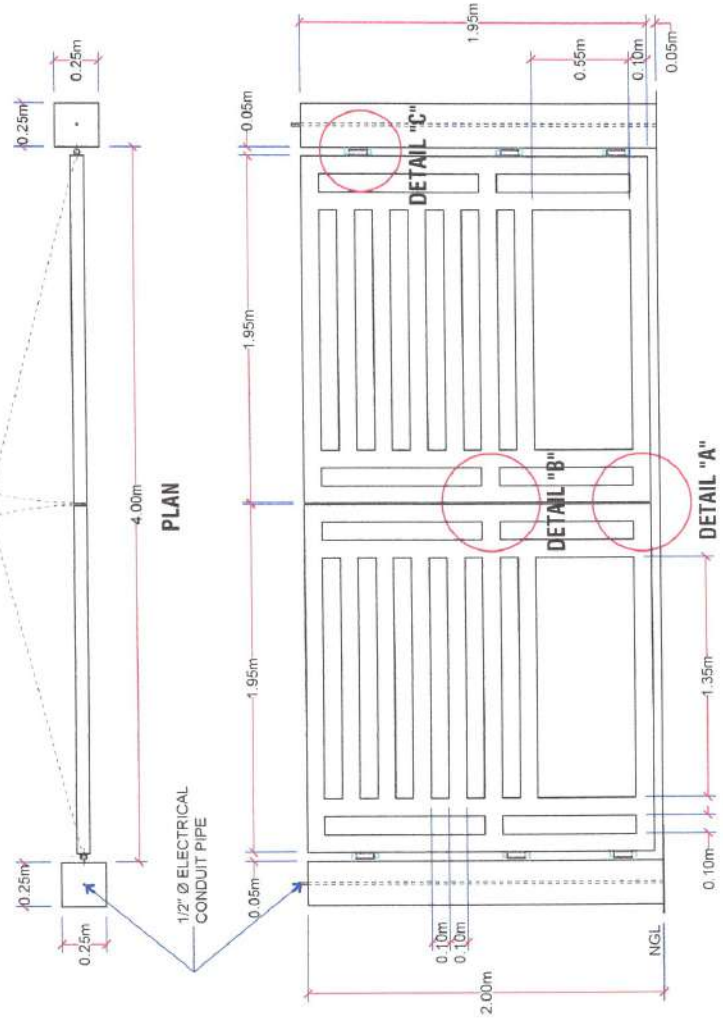

**SWING GATE ELEVATION**  
SCALE: 1:130 METERS

**LEGEND:**  
WF - WALL FOOTING  
CF - COLUMN FOOTING  
RSB - REINFORCE STEEL BAR  
CHB - CONCRETE HOLLOW BLOCK  
NGL - NATURAL GROUND LINE

<p><b>GENERAL SANTOS CITY WATER DISTRICT</b> E. FERNANDEZ STREET, BRGY. LAGAO, GEN. SANTOS CITY ENGINEERING &amp; CONSTRUCTION DEPARTMENT PLANNING AND DESIGN DIVISION TEL. NO.: (883) 582-3821</p>	<p>REG. NO. 018745 PTR. NO. 61873A</p>	<p>TIN. NO. 291-861597 DATE: 01/11/2021</p>	<p><b>DANILAW HORLADOR, JR.</b> CIVIL ENGINEER</p>	<p>TITLE: <b>PROPOSED CONSTRUCTION OF PERIMETER FENCE</b></p>	<p>CHECKED: <i>[Signature]</i> ENGR. MARIA CELIA N. DANDAN</p>	<p>REVIEWED: <i>[Signature]</i> ENGR. ROGELIO A. BESANA, JR.</p>	<p>APPROVED: <i>[Signature]</i> ENGR. ARN B. GELLANGARIN</p>	<p>AS PER PLAN</p>	<p>REV. NO. 1ST DATE: 04/22/2022</p>	<p>SHEET NO. <b>04</b> OF <b>05</b></p>
	<p>ZONE 11-B BRGY. FATMA, GENERAL SANTOS CITY</p>		<p>ADP - Operations &amp; Technical Services</p>	<p>ADP - Planning &amp; Design Division</p>	<p>General Manager A</p>	<p>Checked By: MEND</p>	<p>Drawn By: TFP</p>	<p>General Manager A</p>	<p>Checked By: MEND</p>	<p>DATE: 04/22/2022</p>

