



Republic of the Philippines
GENERAL SANTOS CITY WATER DISTRICT
 E. Fernandez Street, Barangay Lagao General Santos
 Telephone No.: 552-3824; Telefax No.: 553-4960
 Email Address: gscwdprocurement@yahoo.com

GPM-014-4

REQUEST FOR QUOTATION

RFQ #: 3-0124-137 DATE: 1/26/2024

SUPPLIER: _____
 ADDRESS: _____
 TELEPHONE NO. : _____
 TIN NO. : _____

Dear Sir/Madam,

Pls. quote your lowest price on the item/s listed below subject to general condition stating the shortest time of delivery and submit your quotation duly signed by your representative not later than 1/30/2024, Pls. furnish this office the following articles subject to the terms and conditions contained therein.

Instructions :

1. Accomplish this Request for Quotation duly, correctly, and completely.
2. Do not alter the contents of this form in any way.
3. If Technical Specifications/ Terms of Reference is provided, prospect bidder (supplier / service provider) must indicate and signify compliance to every parameter in the specification.

ITEM NO.	DESCRIPTION	QTY.	UNIT	UNIT PRICE
1	LABOR AND MATERIALS : PLEASE SEE ATTACHED PLAN AND DESIGN-ABC: PHP 99,995.97 ##### nothing follows #####	1	LOT	P

Date of Delivery: _____
 Price Validity : _____
 Mode of Payment: _____

Place of Delivery: GSCWD Bodega

****No partial delivery allowed****

Note: 6% WITHHOLDING TAX DEDUCTION

PR NO.: 0124-147

Requested by:

ANDREW H. NADAI, JR.
 Material Procurement Officer A

Price quoted by:

 Supplier

 Date



Republic of the Philippines
GENERAL SANTOS CITY WATER DISTRICT
 E. Fernandez St., Brgy. Lagao, General Santos City
 Telephone No.: 552-3824; Telefax No.: 553-4960
 Email Address: gscwaterdistrict@yahoo.com

Project: **PROPOSED STUDIO ROOM OF GENERAL SANTOS CITY WATER DISTRICT**
 Location: **GSCWD ADMIN BUILDING ROOFDECK, E. FERNANDEZ ST., LAGAO, GSC**
 Owner: **GENERAL SANTOS CITY WATER DISTRICT**
 Subject: **BILL OF QUANTITIES**

ITEM NO.	DESCRIPTION	QUANTITY	UNIT	UNIT COST	AMOUNT
A MOBILIZATION					
A.1	MOBILIZATION	1.00	LOT		
B CONSTRUCTION					
B.1	WALL WORKS	1.00	LOT		
B.1.1	Installation of 32mm x 102mm x 0.6mm thk x 3m. C Metal Studs and Metal Tracks for wall framing				
B.1.2	Installation of 3/16" thickness Hardiflex				
B.2	TILE WORKS				
B.2.1	Installation of 0.30m x 0.30m Vinyl Tiles				
B.3	PAINTING WORKS				
B.3.1	Application of Skimcoat on installed Hardiflex				
B.3.2	Application of Glossy Paint (white) for interior and Elastomeric Paint (ocean blue) for exterior in installed Hardiflex				
B.4	ELECTRICAL WORKS				
B.4.1	Installation of electrical materials				
B.4.2	Installation of Window Type Aircon 1.5 HP				
C DEMOLITION					
C.1	DEMOLITION	1.00	LOT		
C.1.1	Removal of Existing Structures (Concrete table, and kitchen counter)				
TOTAL PROJECT COST					

Note:

PLEASE REFER TO APPROVED PLAN FOR FURTHER DETAILS

Submitted by _____


Date: _____

Name of representative of Bidder : _____


Position: _____

Name of Bidder : _____


Issued on :

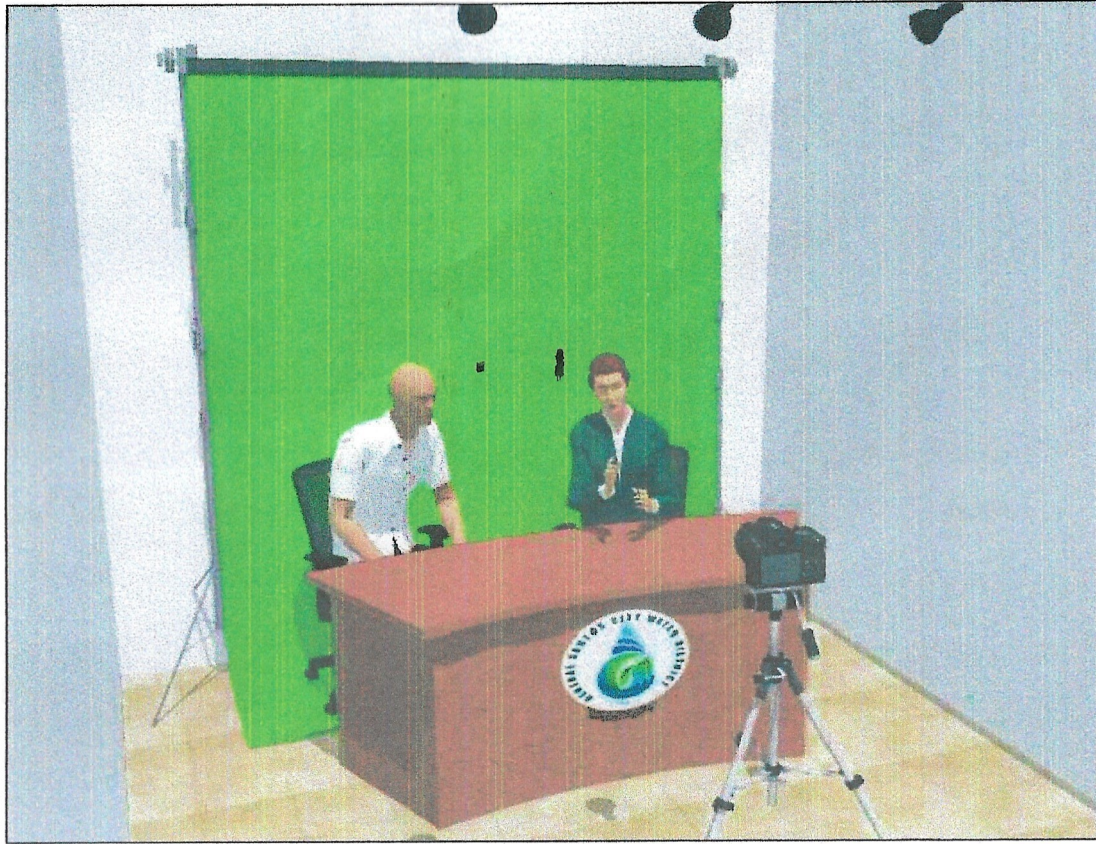


PERSPECTIVE
SCALE: NTS

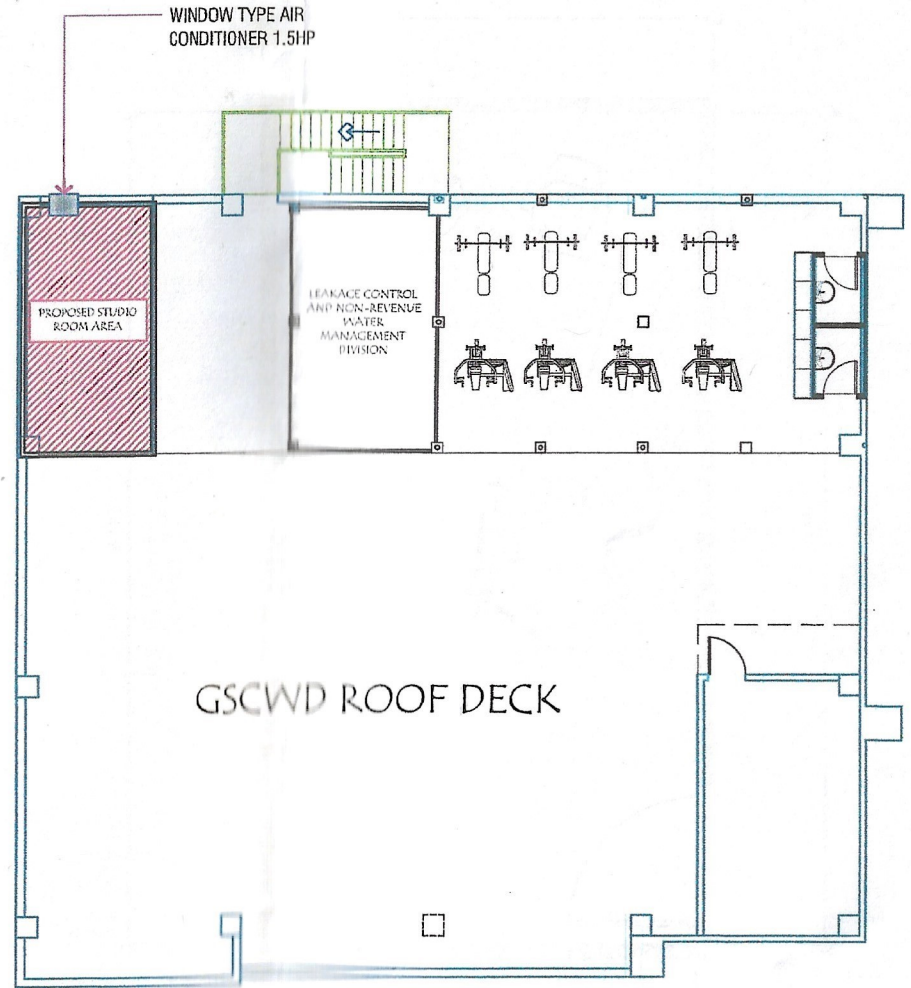


LOCATION PLAN
SCALE: NTS

 GENERAL SANTOS CITY WATER DISTRICT 15 FERMINDAO STREET, 8007, GENERAL SANTOS CITY ENGINEERING & CONSTRUCTION DEPARTMENT PLANNING AND DESIGN DIVISION TEL. NO. (083) 876-8804	PROJECT TITLE:	PREPARED BY:	CHECKED BY:	REVIEWED BY:	DESIGNED FOR APPROVAL BY:	APPROVED BY:	Contents:	SHEET NO.
	PROPOSED STUDIO ROOM OF GENERAL SANTOS CITY WATER DISTRICT	JOSHER C. GUILLERO, CE	DANILO M. HORLADOR, CE	MARIA CELIA N. DANIGAN, PE	FRANCISCA BEBANA, JR. CE./RMP	FERDINAND S. FERRER, MPA	AS SHOWN	1
	GENERAL SANTOS CITY WATER DISTRICT BLDG.	ENGINEERING ASSISTANT	PROJECT PLANNING & DEVT OFFICER A	ACTING DEPT. MANAGER	GENERAL MANAGER - OTS	ACTING GENERAL MANAGER	REVISION:	4
							DATE:	09/19/2023

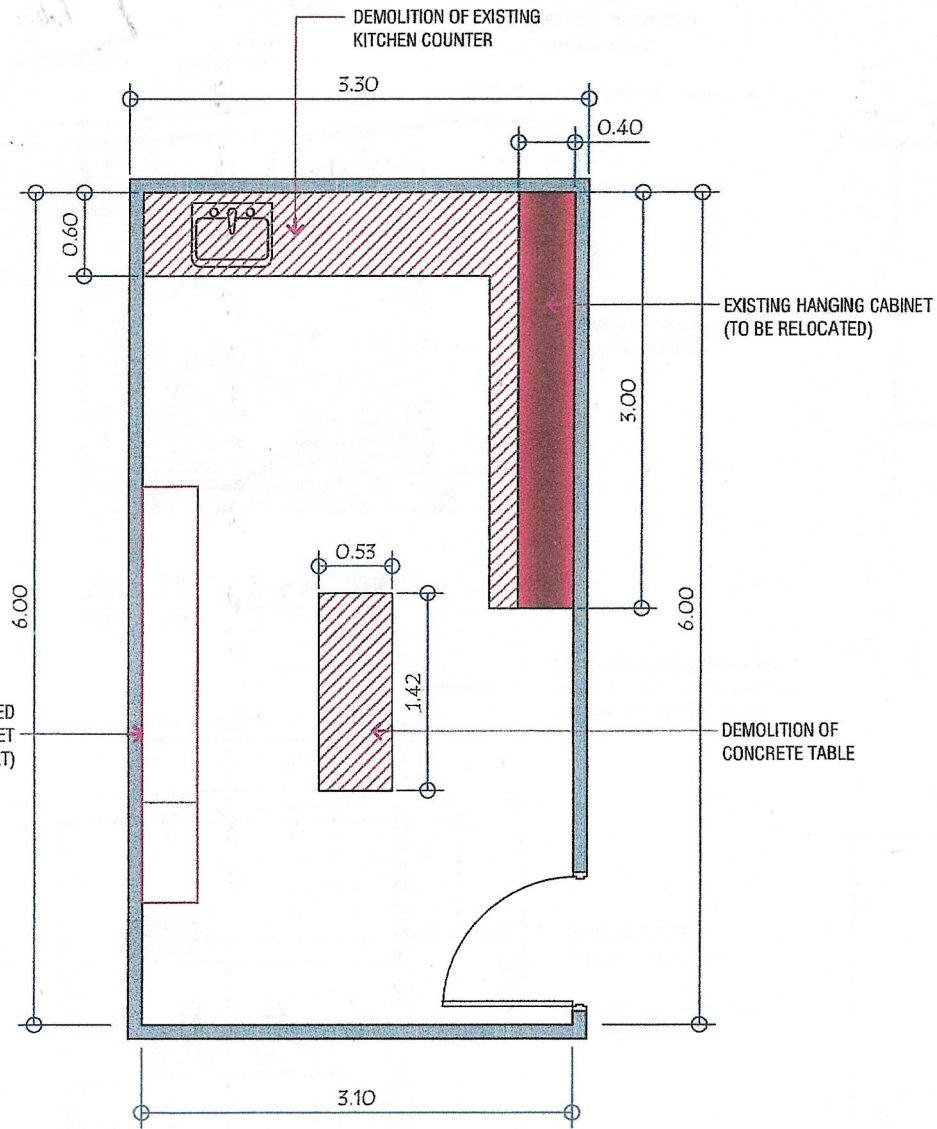


EXISTING FLOOR PLAN
SCALE: 20:1 M

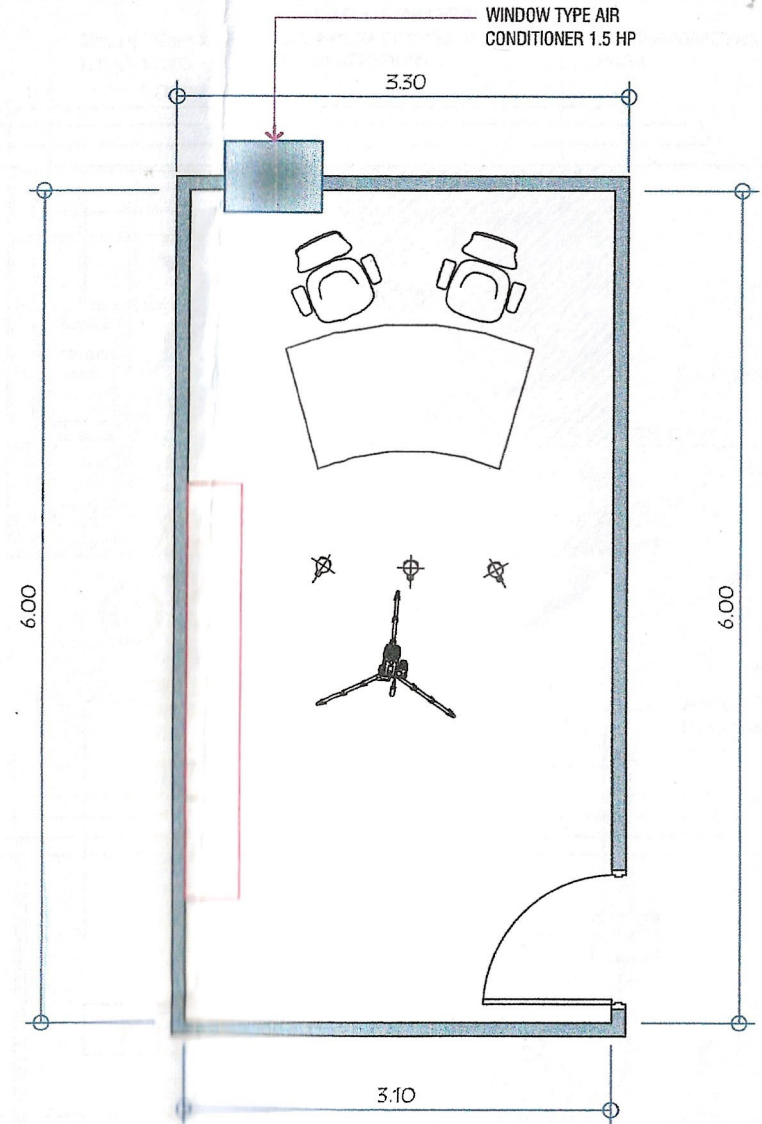


PROPOSED FLOOR PLAN
SCALE: 20:1 M


PROJECT TITLE:	PREPARED BY:	CHECKED BY:	REVIEWED BY:	DESIGNED FOR APPROVAL BY:	APPROVED BY:	Contents:	SHEET NO.
PROPOSED STUDIO ROOM OF GENERAL SANTOS CITY WATER DISTRICT	JONER C. GUILLERO, CE	DAMILO M. HORLADOR, CE	MARY CELIA N. DAVAN, CE	ROBERTO BRUANA, JR. CE./RMP	FEROJHAND S. FERRER, MPA	AS SHOWN	2
GENERAL SANTOS CITY WATER DISTRICT BLDG.	ENGINEERING ASSISTANT	PROJECT PLANNING & DEVT OFFICER A	ACTING DEPT. MANAGER - EEI	GENERAL MANAGER - OTS	ACTING GENERAL MANAGER	REVISION:	4
						DATE: 09/18/2023	

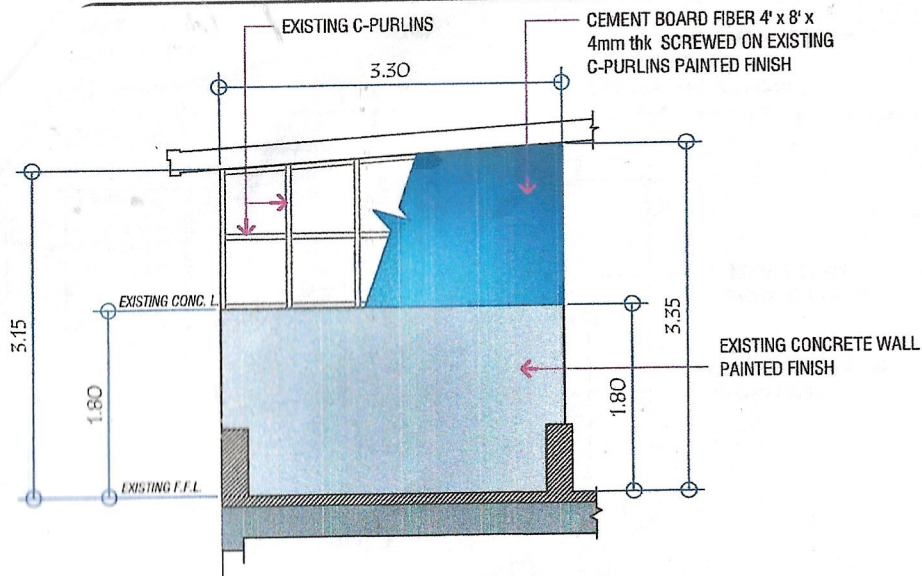


FRONT ELEVATION
SCALE: 14 : 1 M

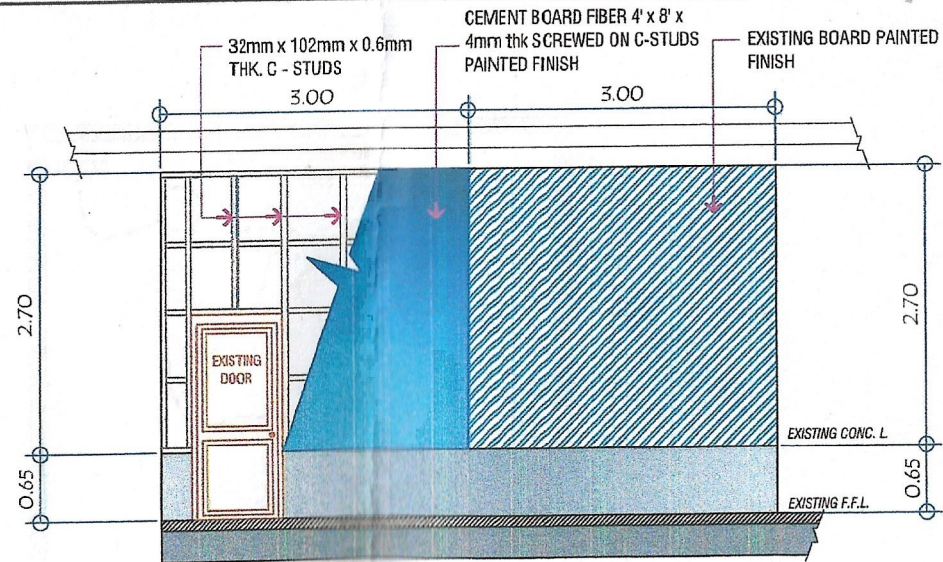

RIGHT SIDE ELEVATION
SCALE: 14 : 1 M

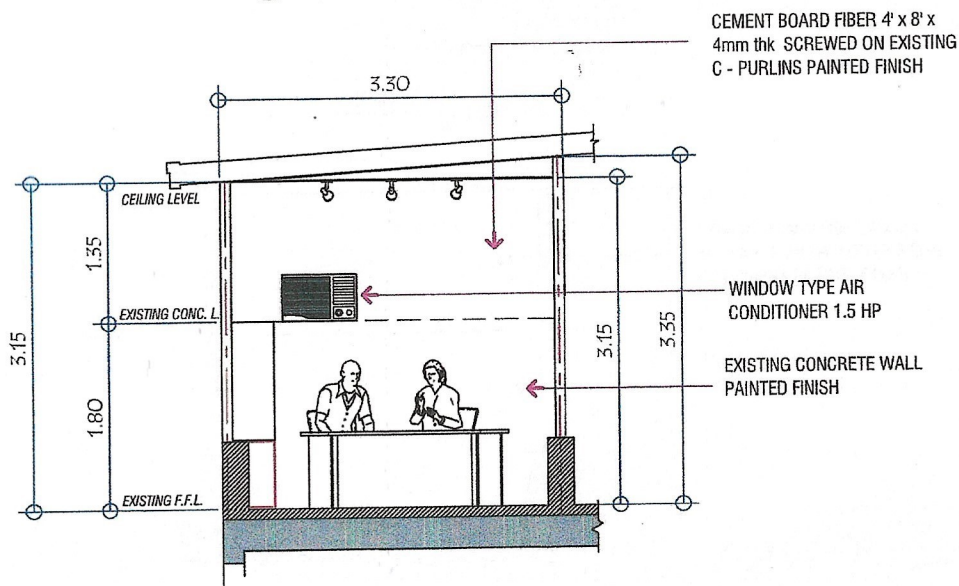

FRONT CROSS-SECTION
SCALE: 14 : 1 M

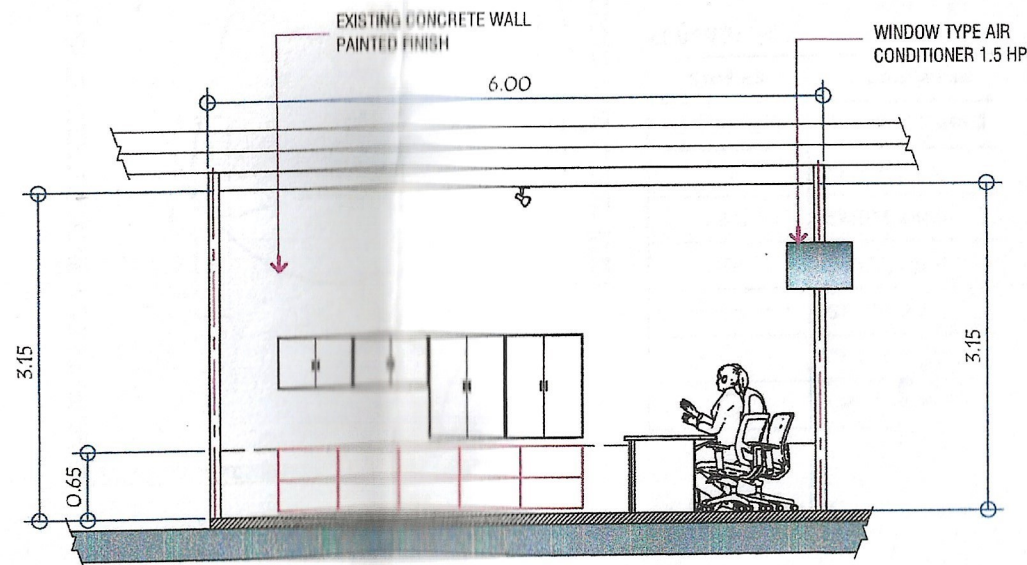

RIGHT SIDE CROSS-SECTION
SCALE: 14 : 1 M



GENERAL SANTOS CITY WATER DISTRICT

N. FERNANDEZ STREET, BRGY. LAGDA, GENERAL SANTOS CITY
ENGINEERING & CONSTRUCTION DEPARTMENT
91 MYING AND ENGINEERING DISTRICT
TEL. NO. 1 (809) 880-2824

PROJECT TITLE:

PROPOSED STUDIO ROOM OF
GENERAL SANTOS CITY WATER
DISTRICT

GENERAL SANTOS CITY WATER DISTRICT BLDG.

PREPARED BY:

JONER C. GUILLERO, CE
ENGINEERING ASSISTANT

CHECKED BY:

DANILO M. HORLADOR, CE
PROJECT PLANNING & DEVT OFFICER A

REVIEWED BY:

MARIA DELIA N. DANGAN, CE
ACTING DEPT. MANAGER - E&C

APPROVED FOR APPROVAL BY:

REBANA, JR. CE, R/MP
GENERAL MANAGER - OTS

APPROVED BY:

FERDINAND S. FERRE, MPA
ACTING GENERAL MANAGER

Contents:

AS SHOWN


REVISION:

DATE: 09 / 15 / 2023


SHEET NO.

3


4

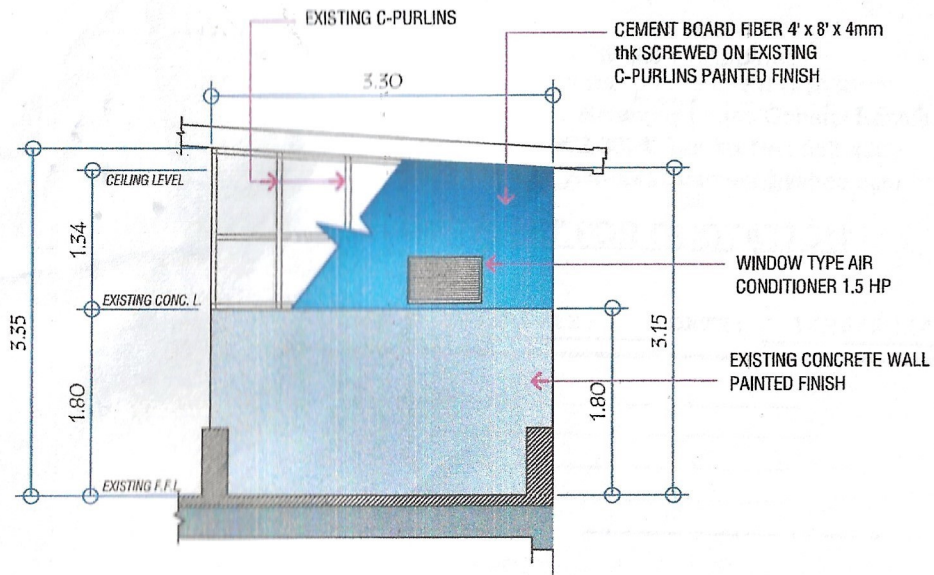

REAR ELEVATION
SCALE: 14 : 1 M

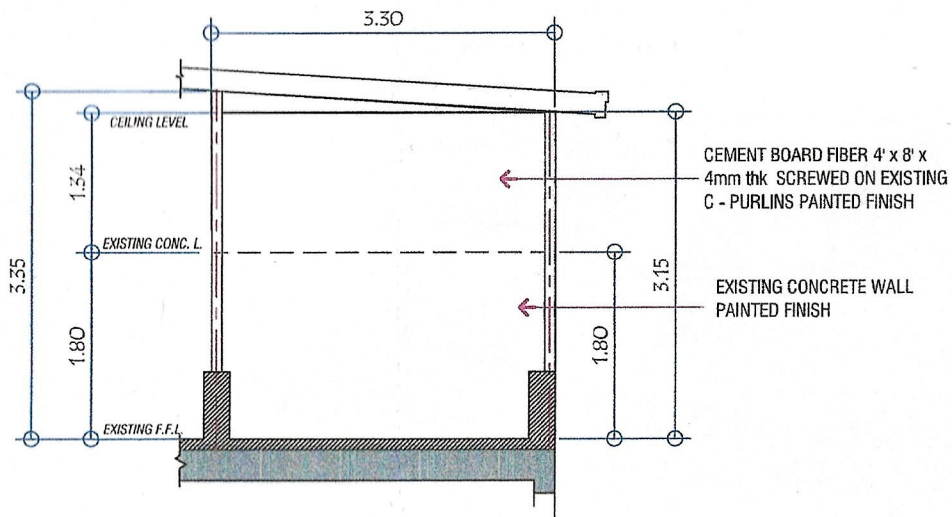

REAR CROSS-SECTION
SCALE: 14 : 1 M

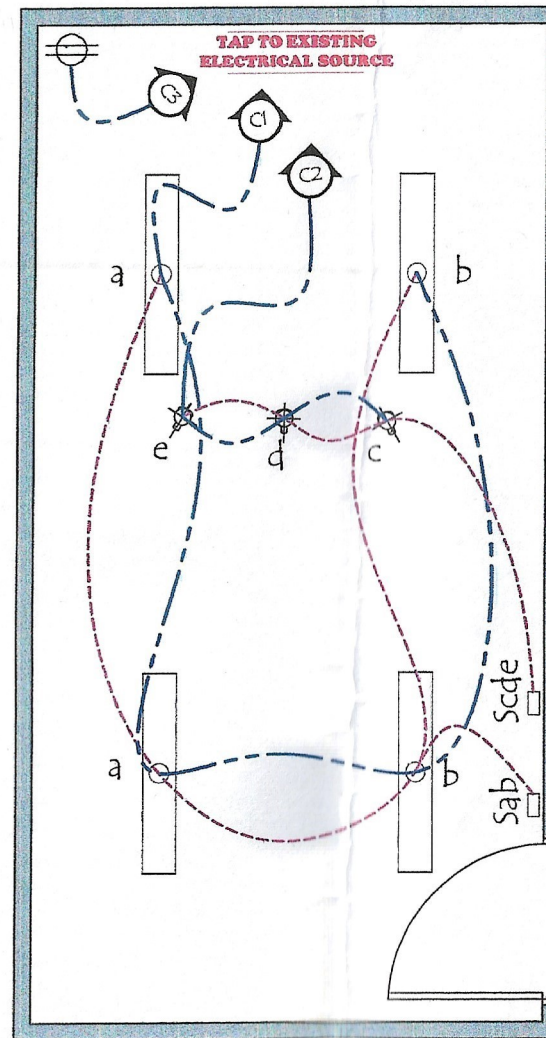

LEGEND:

SYMBOLS	DESCRIPTION
	LED TUBELIGHT DAYLIGHT
Sab	SWITCH, 2 gang
Scde	SWITCH, 3 gang
	OUTLET, 1 gang
	SWITCH LINE
	CIRCUIT LINE
	CIRCUIT HOMERUN

ELECTRICAL LAY-OUT
SCALE: 24 : 1 M

<p>GENERAL SANTOS CITY WATER DISTRICT 8, FERRELLA STREET, 8501, LAGAO, GENERAL SANTOS CITY ENGINEERING & CONSTRUCTION DEPARTMENT PLANNING AND DESIGN DIVISION TEL. NO.: (083) 825-3424</p>	PROJECT TITLE:	PREPARED BY:	CHECKED BY:	REVIEWED BY:	RECOMMENDING FOR APPROVAL BY:	APPROVED BY:	Contents:	SHEET NO.
	PROPOSED STUDIO ROOM OF GENERAL SANTOS CITY WATER DISTRICT	JOSHER C. GUILLERO, CE	DANLO M. HORLADOR, CE	MARIA CELIA N. DAYDAN, CE	RODOLFO A. BESANA, JR. CE./RMP	FERDINAND S. FERRER, MPA	AS SHOWN	4
	GENERAL SANTOS CITY WATER DISTRICT BLDG.	ENGINEERING ASSISTANT	PROJECT PLANNING & DEPT OFFICER A	ACTING DEPT. MANAGER - ECD	ASSISTING GENERAL MANAGER - OTS	ACTING GENERAL MANAGER	REVISION:	4
							DATE	09 / 18 / 2023