



Republic of the Philippines
GENERAL SANTOS CITY WATER DISTRICT
E. Fernandez Street, Barangay Lagao General Santos
Telephone No.: 552-3824; Telefax No.: 553-4960
Email Address: gscwdprocurement@yahoo.com

GPM-014-2

REQUEST FOR QUOTATION

RFQ #: 3-0422-074 DATE: 04/20/2022

SUPPLIER: _____
ADDRESS: _____
TELEPHONE NO. : _____
TIN NO. : _____

Dear Sir/Madam,

Pls. quote your lowest price on the item/s listed below subject to general condition stating the shortest time of delivery and submit your quotation duly signed by your representative not later than 04/26/2022, Pls. furnish this office the following articles subject to the terms and conditions contained therein.

ITEM NO.	DESCRIPTION	QTY.	UNIT	UNIT PRICE
1	CONSTRUCTION/LABOR AND MATERIALS : PLEASE SEE ATTACHED SCOPE OF WORK-ABC: PHP 78,277.43 ##### nothing follows #####	1	LOT	P

Date of Delivery: _____
Price Validity : _____
Terms of Payment: _____

Place of Delivery: GSCWD Bodega
****No partial delivery allowed****
Note: 6% WITHHOLDING TAX DEDUCTION
PR NO.: 0422-044




Requested by: _____

GESEM R. CAYANERO
MATERIAL PROCUREMENT
OFFICER A


Price quoted by:

Supplier


Date

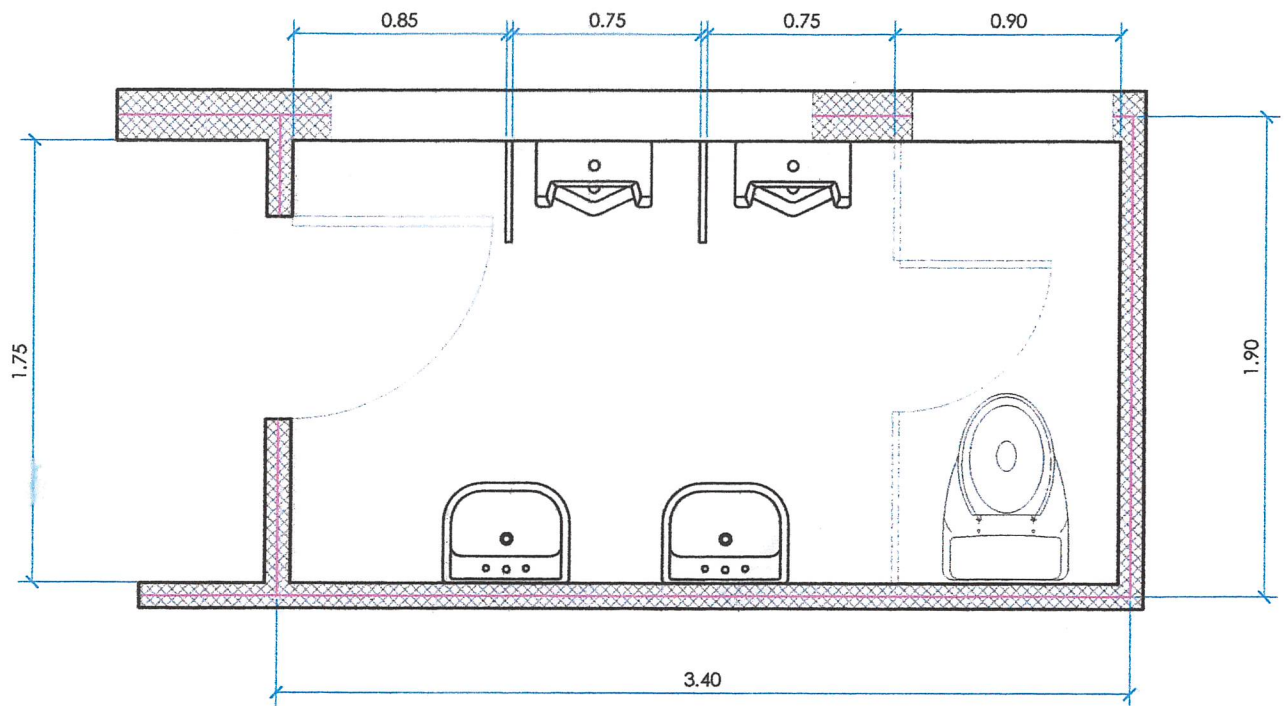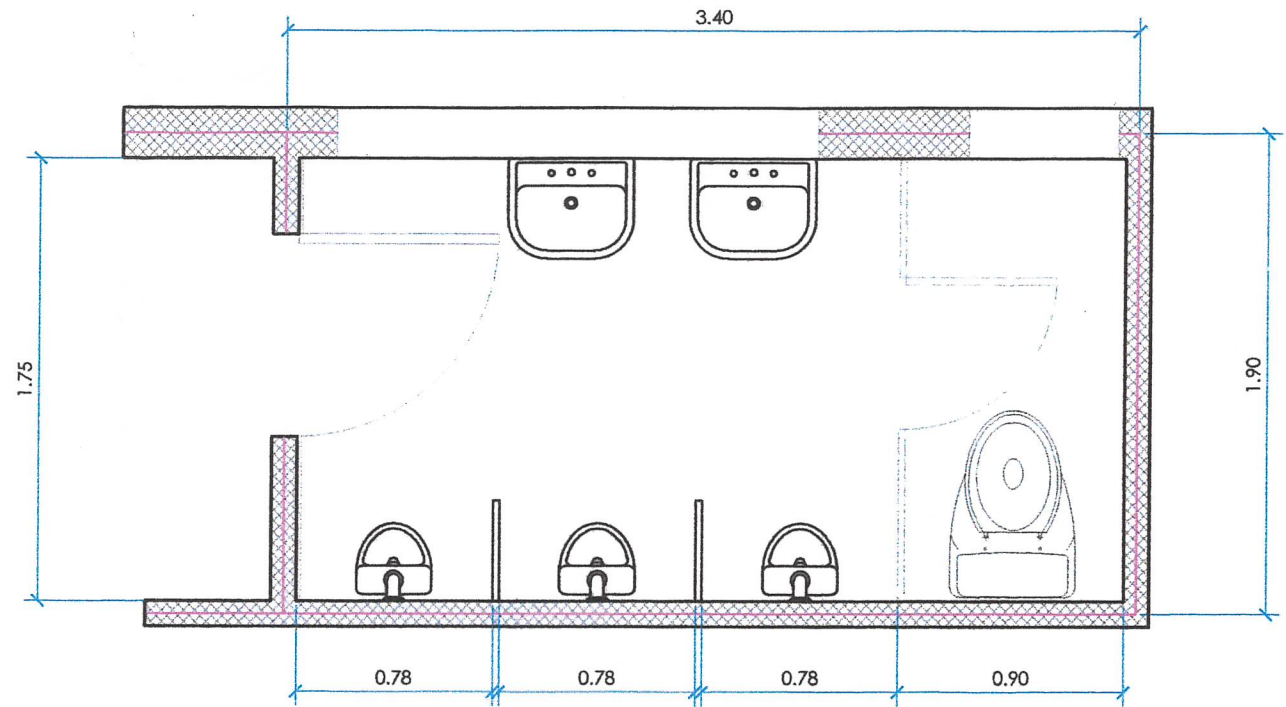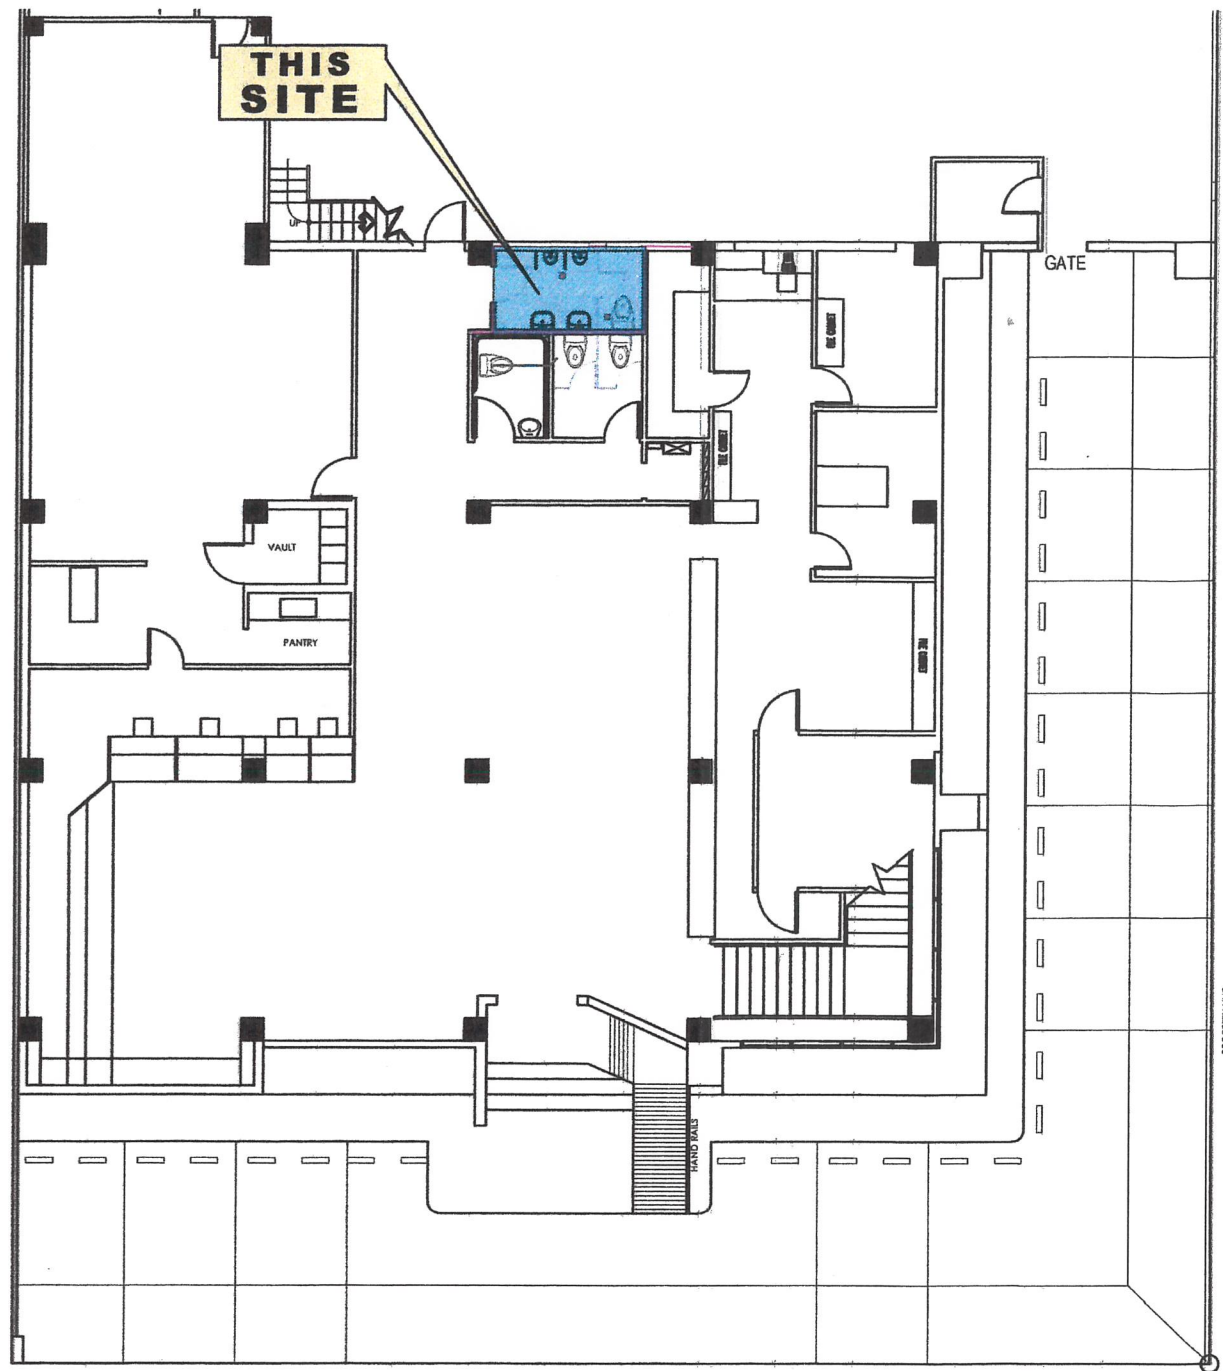


TITLE: PROPOSED REHABILITATION OF GSCWD ADMIN BUILDING MALE COMFORT ROOM	CHECKED & REVIEWED: MICHAEL G. SABALES, REP OIC Department Manager- ICTD	RECOMMENDING APPROVAL: JEREMIAS A. REYES JR, MPA OIC Department Manager- GSPMMD	APPROVED: FERDINAND S. FERRER, MPA Assistant General Manager - Administration	APPROVED: ARN-B. GELLANGARIN, PME General Manager	SHEET CONTENTS: AS SHOWN DRAWN BY: CJR CHECKED BY: RRB	REV. NO. 1 DATE: 03 / 09 / 2022	SHEET NO. A-01 1 4
--	---	--	--	--	--	------------------------------------	--

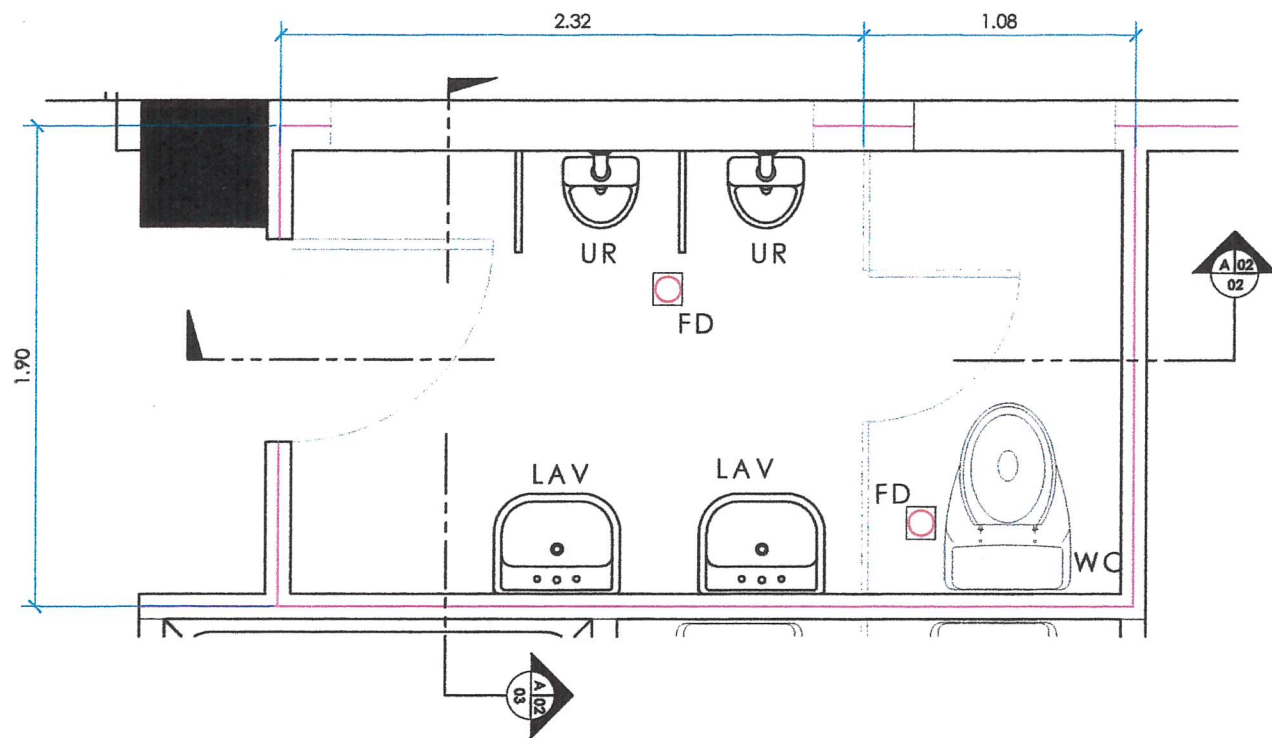

01
A-02
DETAIL PLAN (TOILET)
SCALE : NTS

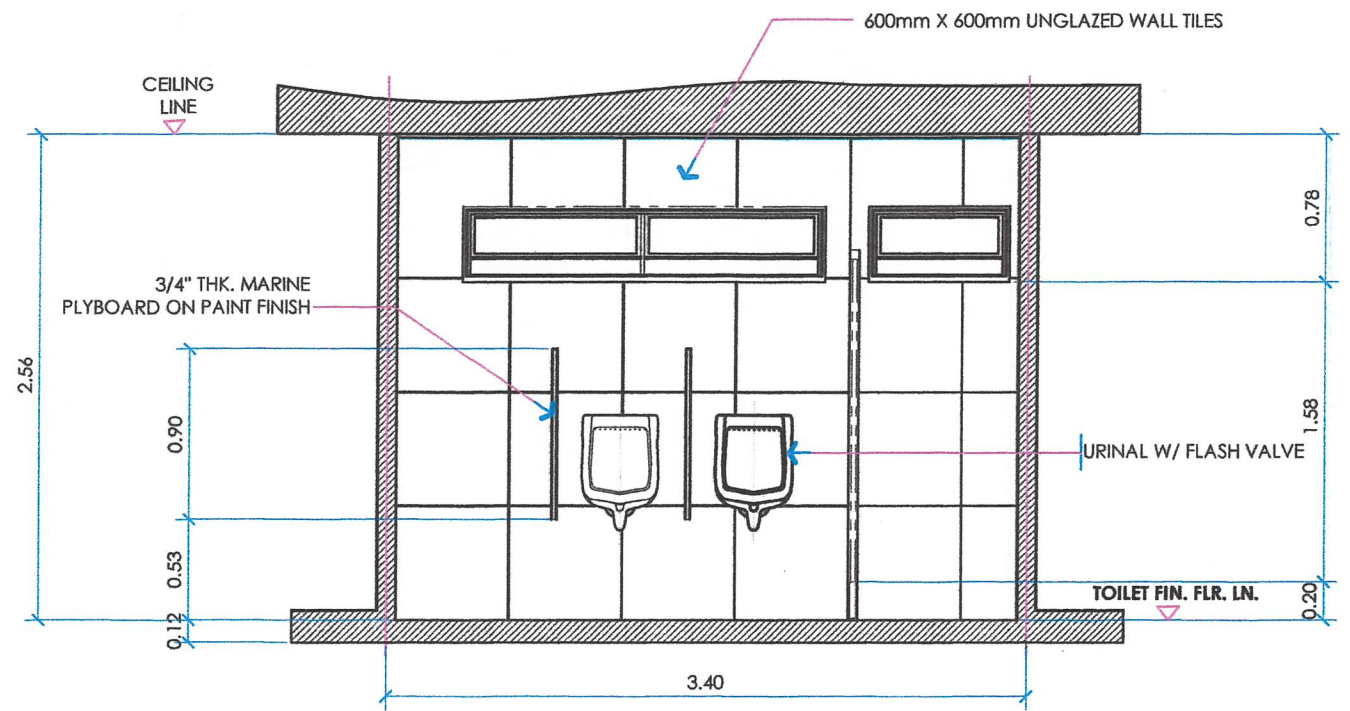

02
A-02
DETAIL SECTION (MEN'S TOILET)
SCALE : 1:40

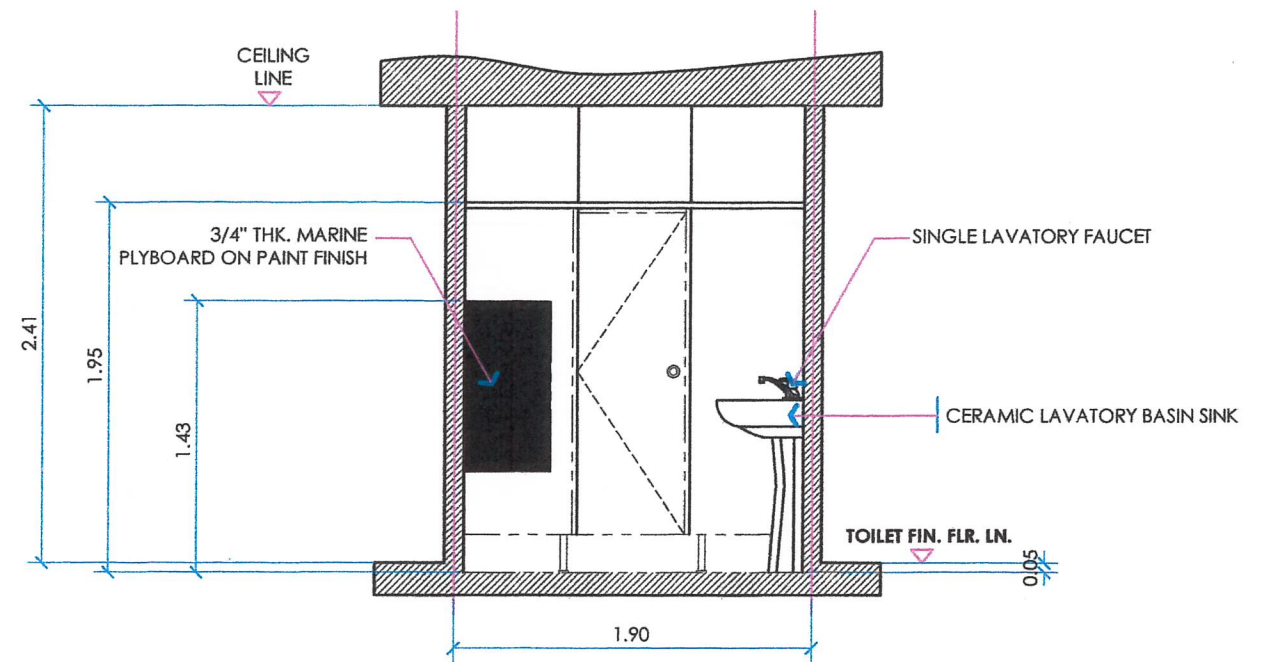


03
A-02
DETAIL SECTION (MEN'S TOILET)
SCALE : 1:40

LEGEND:


- CO - CLEAN OUT
 - UR - URINAL
 - FD - FLOOR DRAIN
 - LAV - LAVATORY
 - SV - SEPTIC VAULT
 - CB - CATCH BASIN
 - SP - STACK PIPE
- SANITARY LINE (4"Ø)
 - - - SANITARY LINE (2"Ø)
 - WATER SUPPLY LINE (½"Ø G.I. PIPE)

NOTE:

1. PROVIDE CHROME URINAL FLUSH VALVE (HEAVY DUTY)
2. PROVIDE STAINLESS STEEL FAUCET FOR LAVATORY

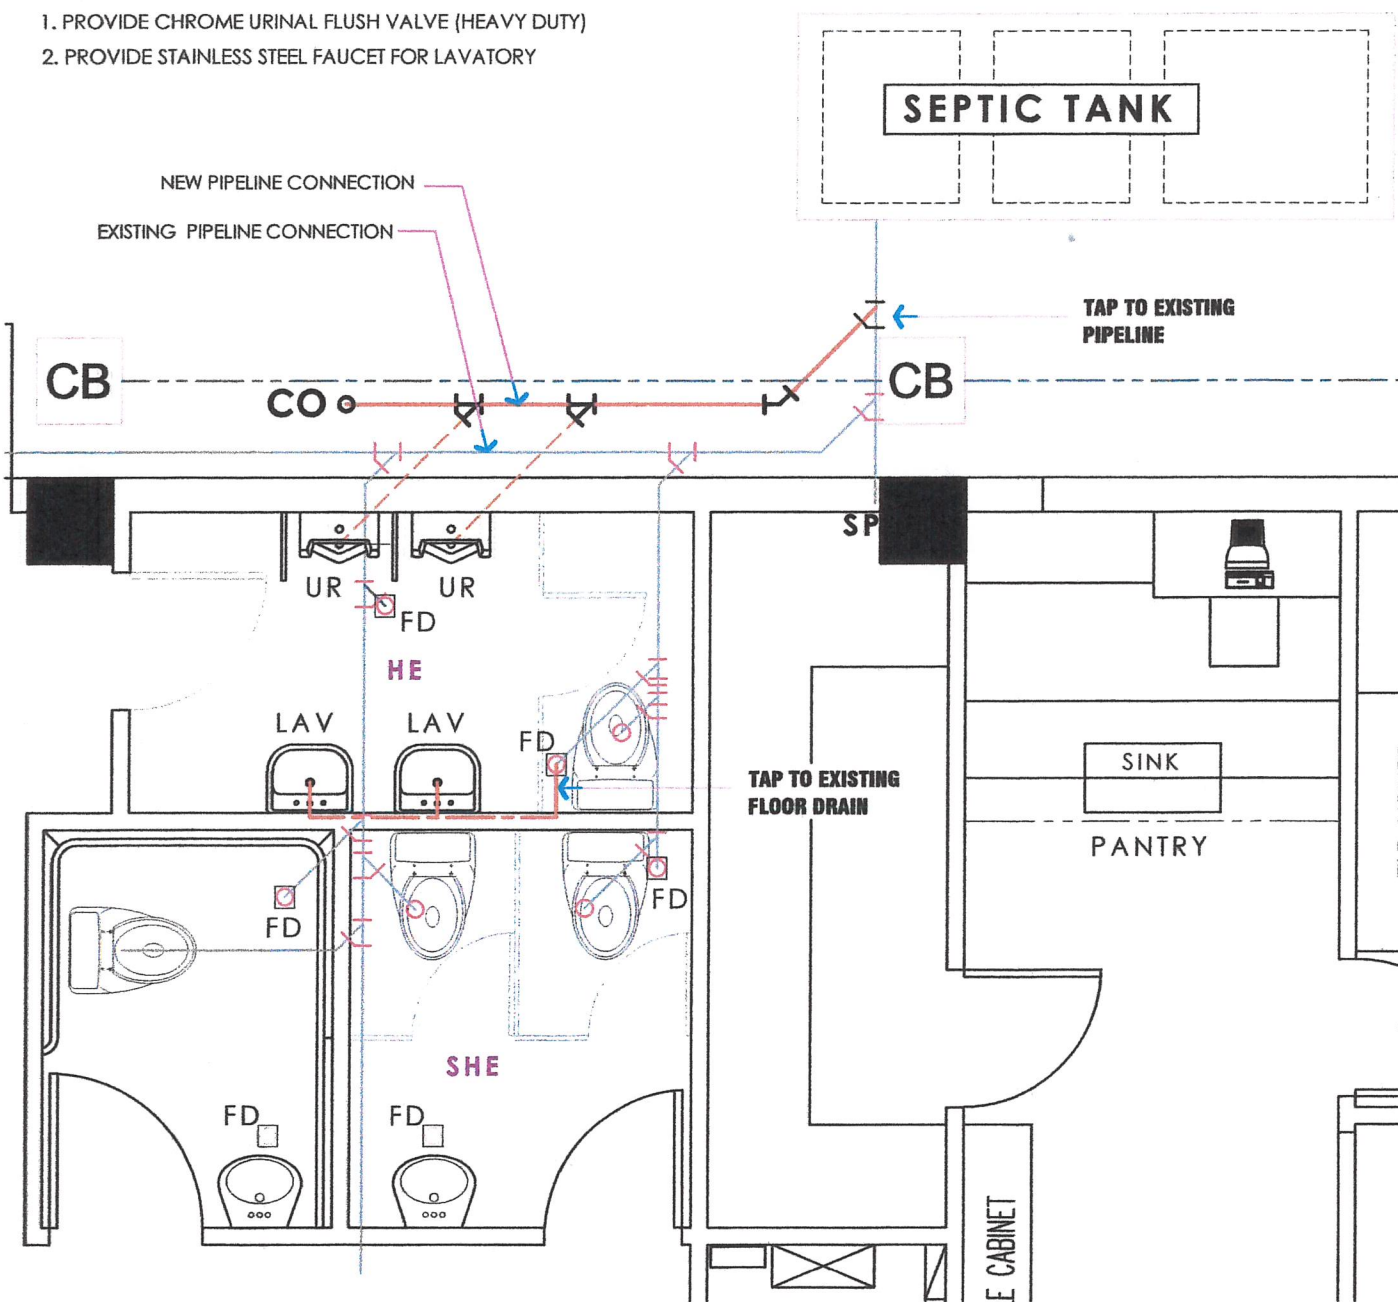

01 FLOOR PLAN (SEWER & DRAINAGE LAYOUT)
SCALE : NTS

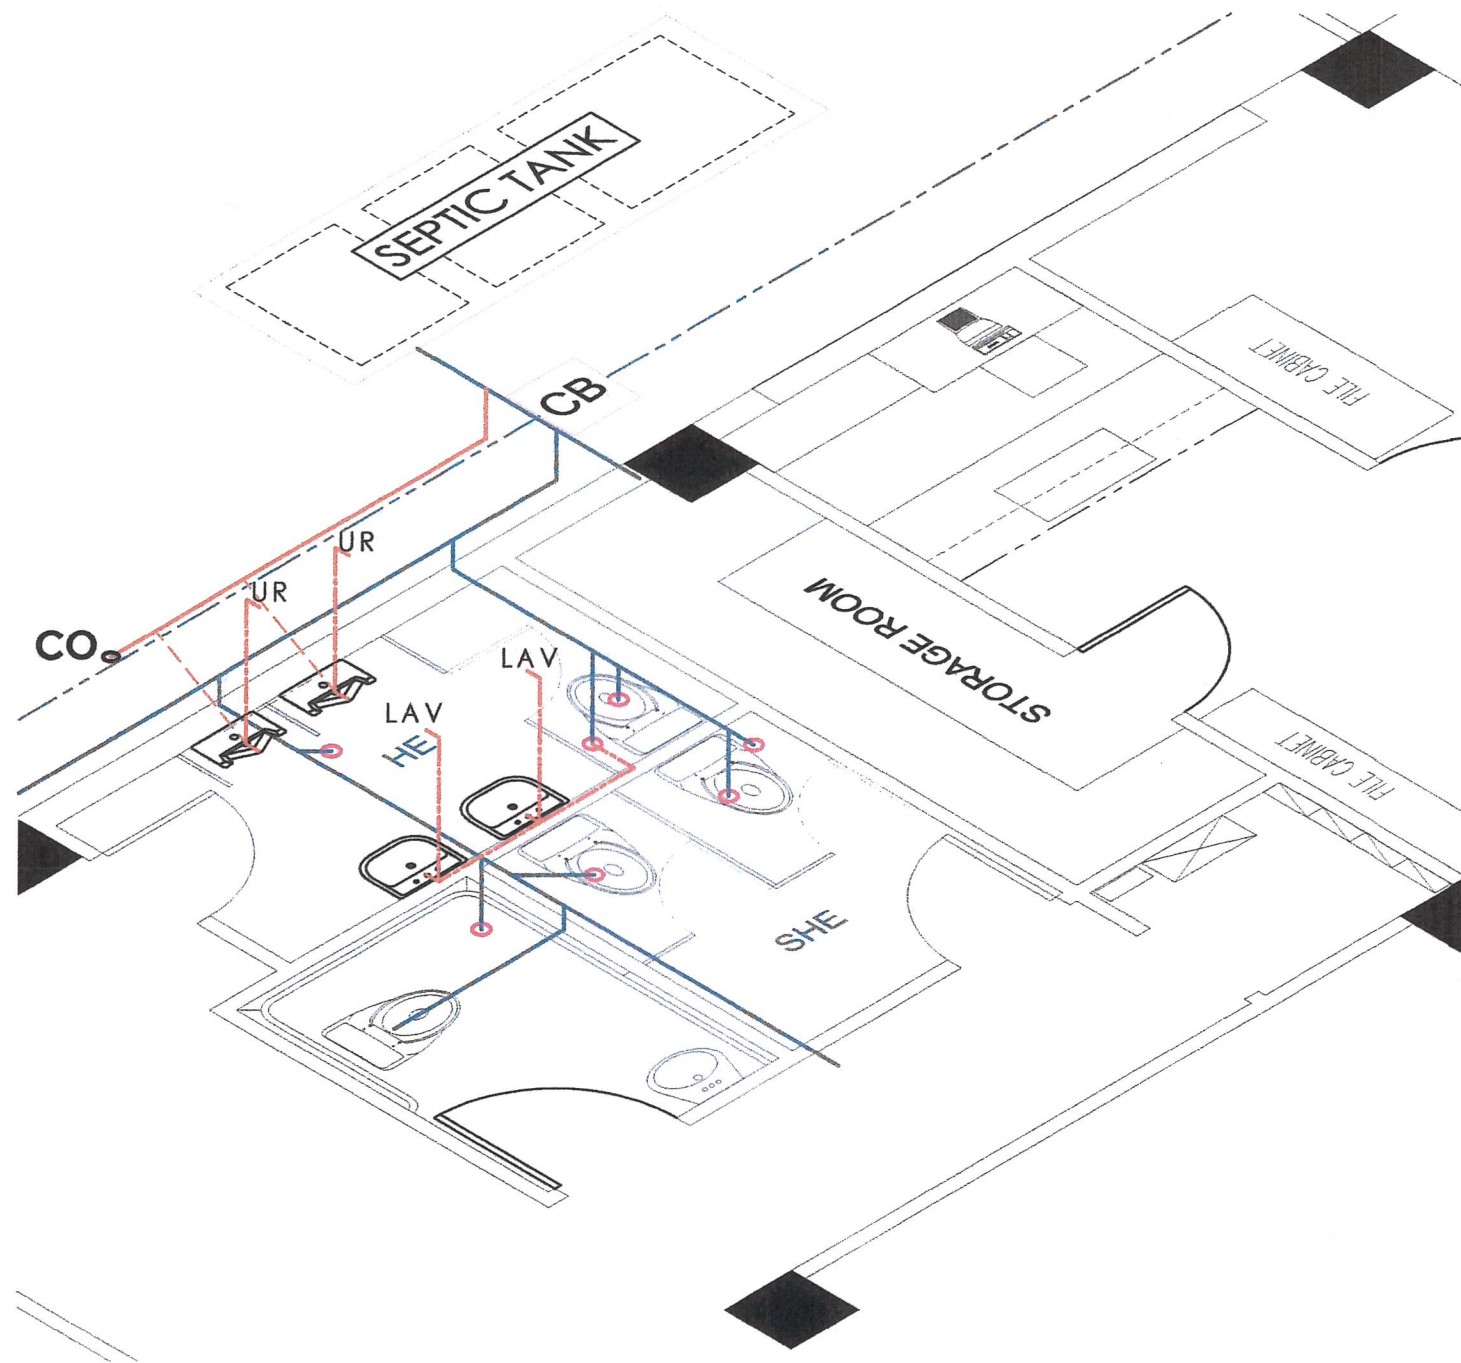

02 ISOMETRIC DIAGRAM (SEWER & DRAINAGE LAYOUT)
SCALE : NTS


TITLE: PROPOSED REHABILITATION OF GSCWD ADMIN BUILDING MALE COMFORT ROOM	CHECKED & REVIEWED: <i>[Signature]</i> MICHAEL O. GALALES, REE OIC Department Manager- ICTD	RECOMMENDING APPROVAL: <i>[Signature]</i> JEREMIAS A. REYES JR, MPA OIC Department Manager- GSPMMD	APPROVED: <i>[Signature]</i> FERDINAND S. FERRER, MPA Assistant General Manager - Administration	APPROVED: <i>[Signature]</i> ARN B. GELLANGARIN, PME General Manager	SHEET CONTENTS: AS SHOWN	SHEET NO. P-01
E. FERNANDEZ ST. BRGY. LAGAO, GENERAL SANTOS CITY					DRAWN BY: CJR CHECKED BY: RRB	REV. NO. 1 DATE: 03 / 09 / 2022

LEGEND:


- CO - CLEAN OUT
 - UR - URINAL
 - FD - FLOOR DRAIN
 - LAV - LAVATORY
 - WC - WATER CLOSET
 - SV - SEPTIC VAULT
 - CB - CATCH BASIN
 - SP - STACK PIPE
- - - - - SANITARY LINE (4"Ø)
 - - - - - SANITARY LINE (2"Ø)
 - - - - - WATER SUPPLY LINE (½"Ø G.I. PIPE)

NOTE:

1. PROVIDE CHROME URINAL FLUSH VALVE (HEAVY DUTY)
2. PROVIDE STAINLESS STEEL FAUCET FOR LAVATORY

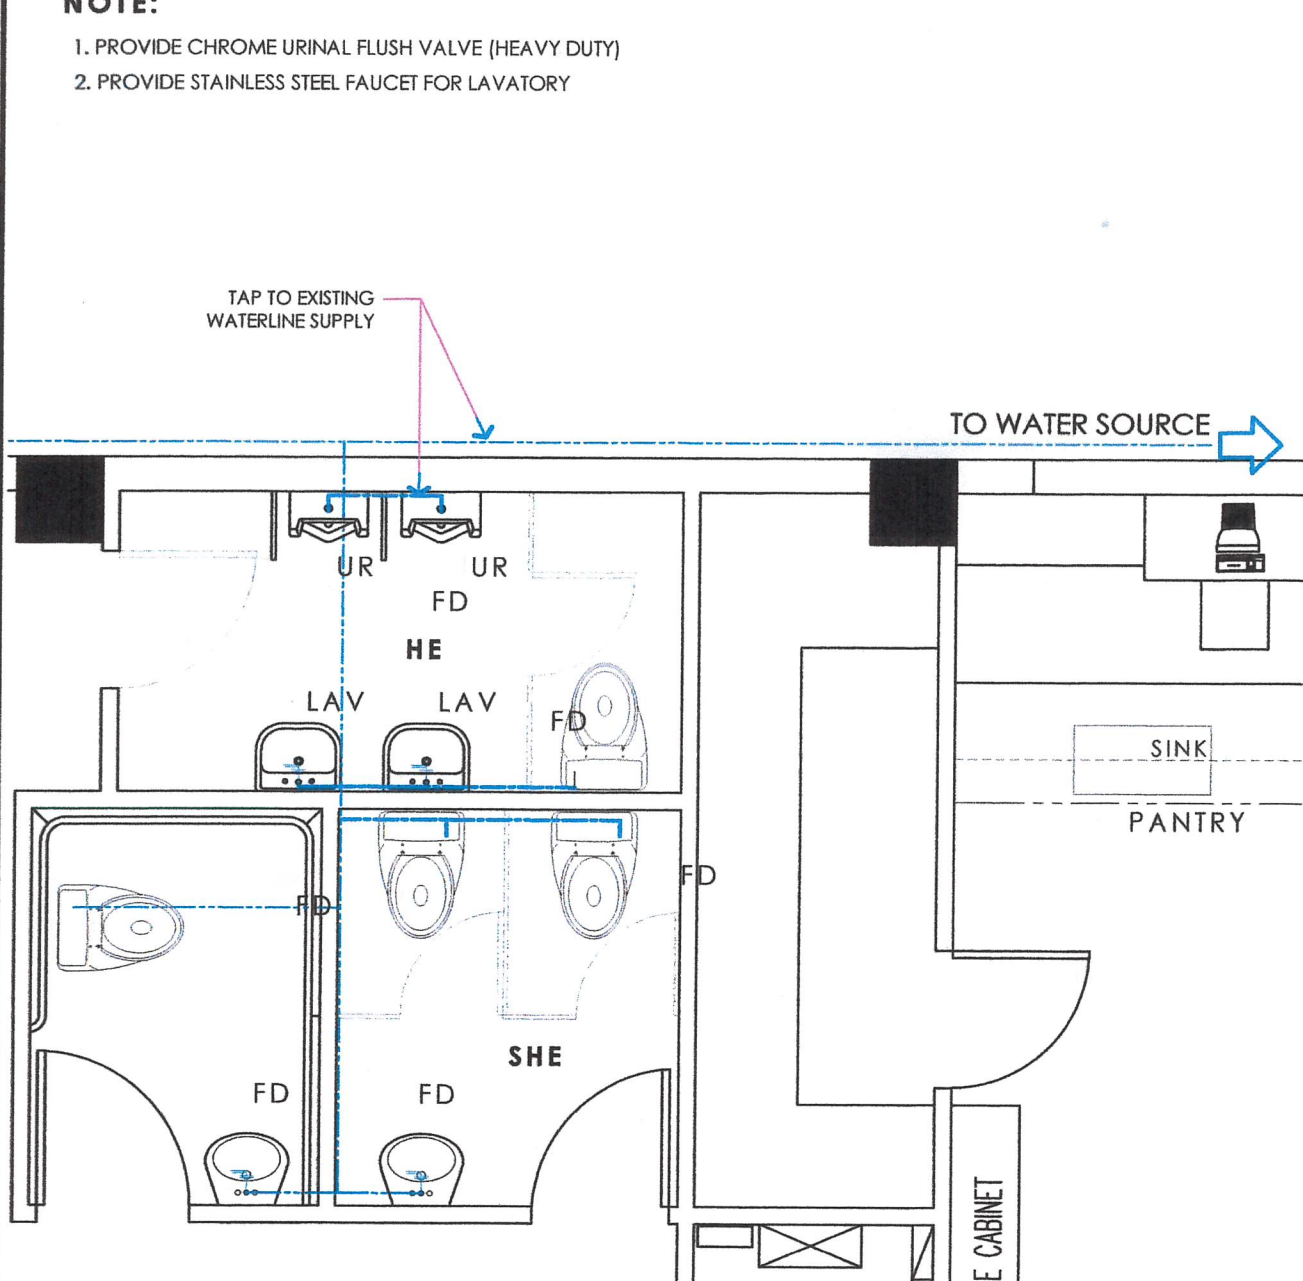

01
P 02
FLOOR PLAN (WATERLINE LAYOUT)
SCALE : NTS

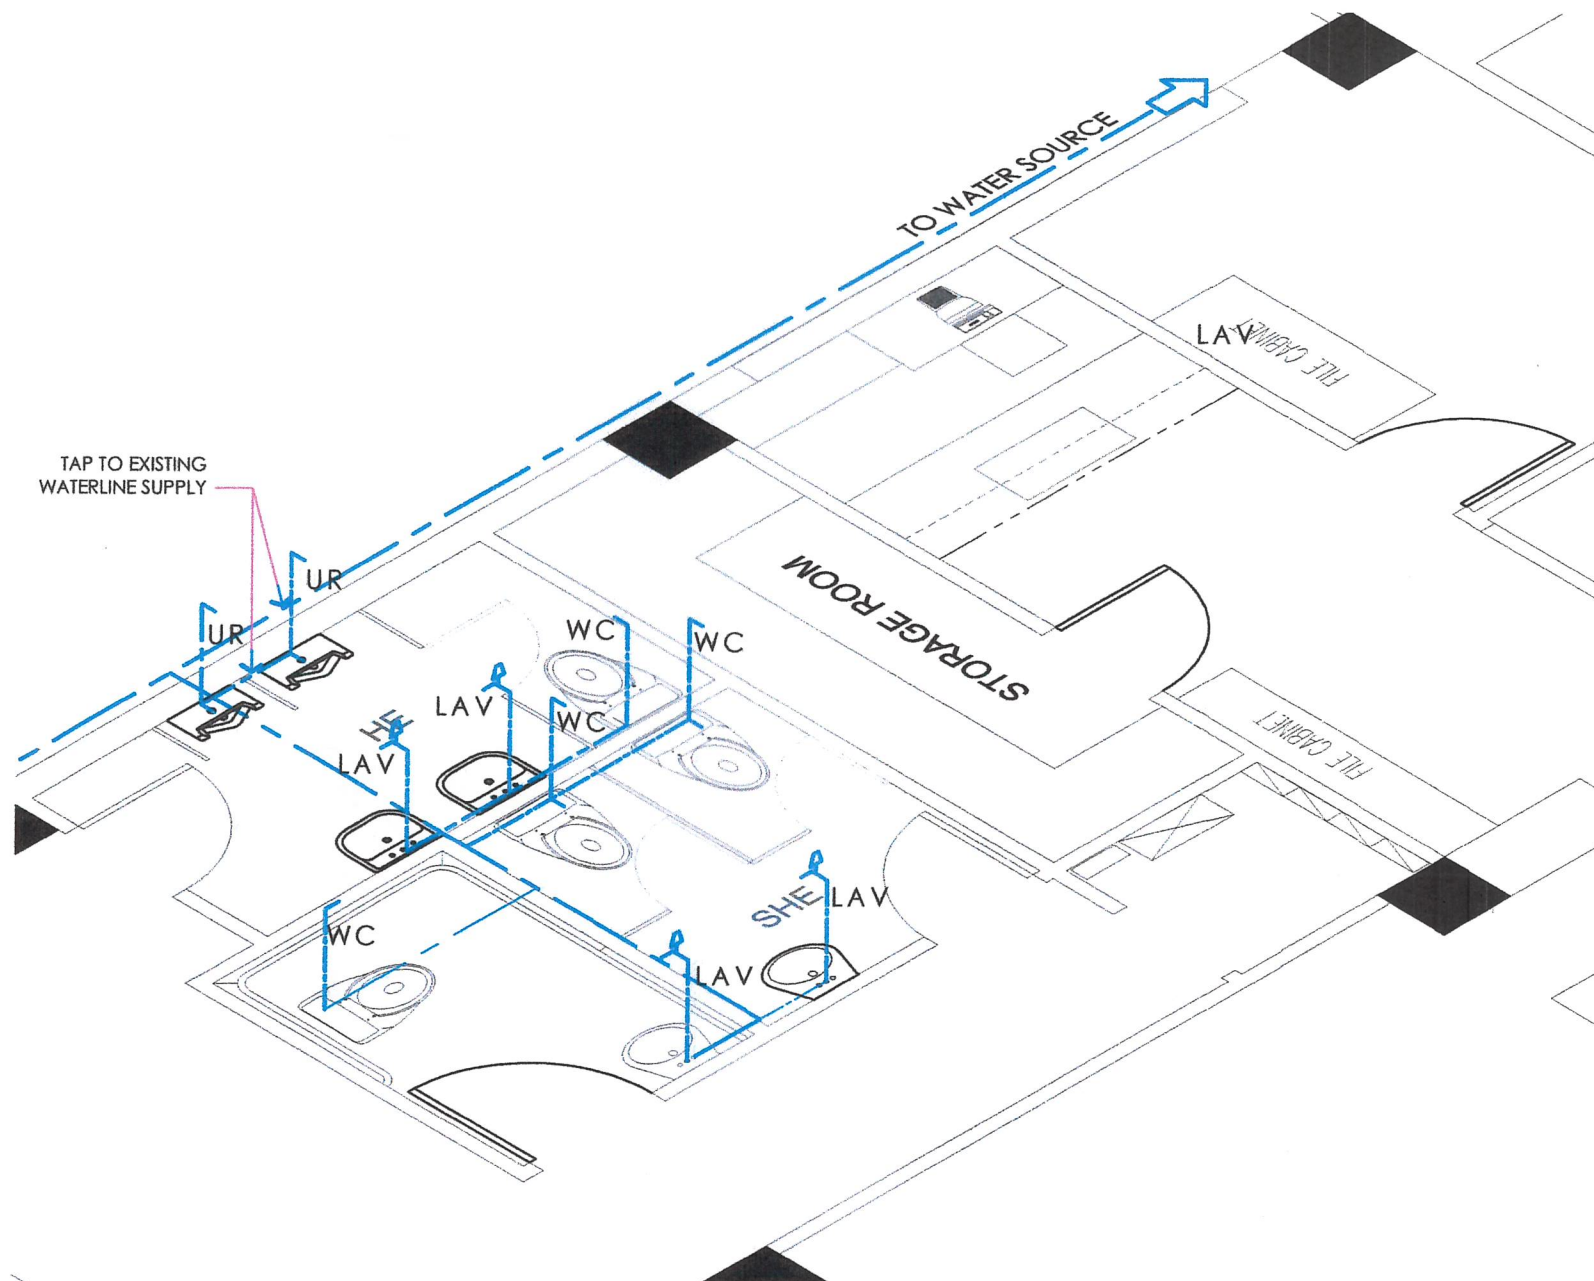

02
P 02
ISOMETRIC DIAGRAM (WATERLINE LAYOUT)
SCALE : NTS

TITLE: PROPOSED REHABILITATION OF GSCWD ADMIN BUILDING MALE COMFORT ROOM	CHECKED & REVIEWED: MICHAEL G. GABALES, REE OIC Department Manager- ICTD	RECOMMENDING APPROVAL: JEREMIAS A. REYES JR, MPA OIC Department Manager- GSPMMD	APPROVED: FERNANDO S. FERRER, MPA Assistant General Manager - Administration	APPROVED: ARN B. GELLANGARIN, PME General Manager	SHEET CONTENTS: AS SHOWN DRAWN BY: CJR CHECKED BY: RRB	REV. NO. 1 DATE: 03 / 09 / 2022	SHEET NO. P-02 4 4
--	---	--	---	--	---	------------------------------------	--