





01 PERSPECTIVE
A-01 NOT TO SCALE

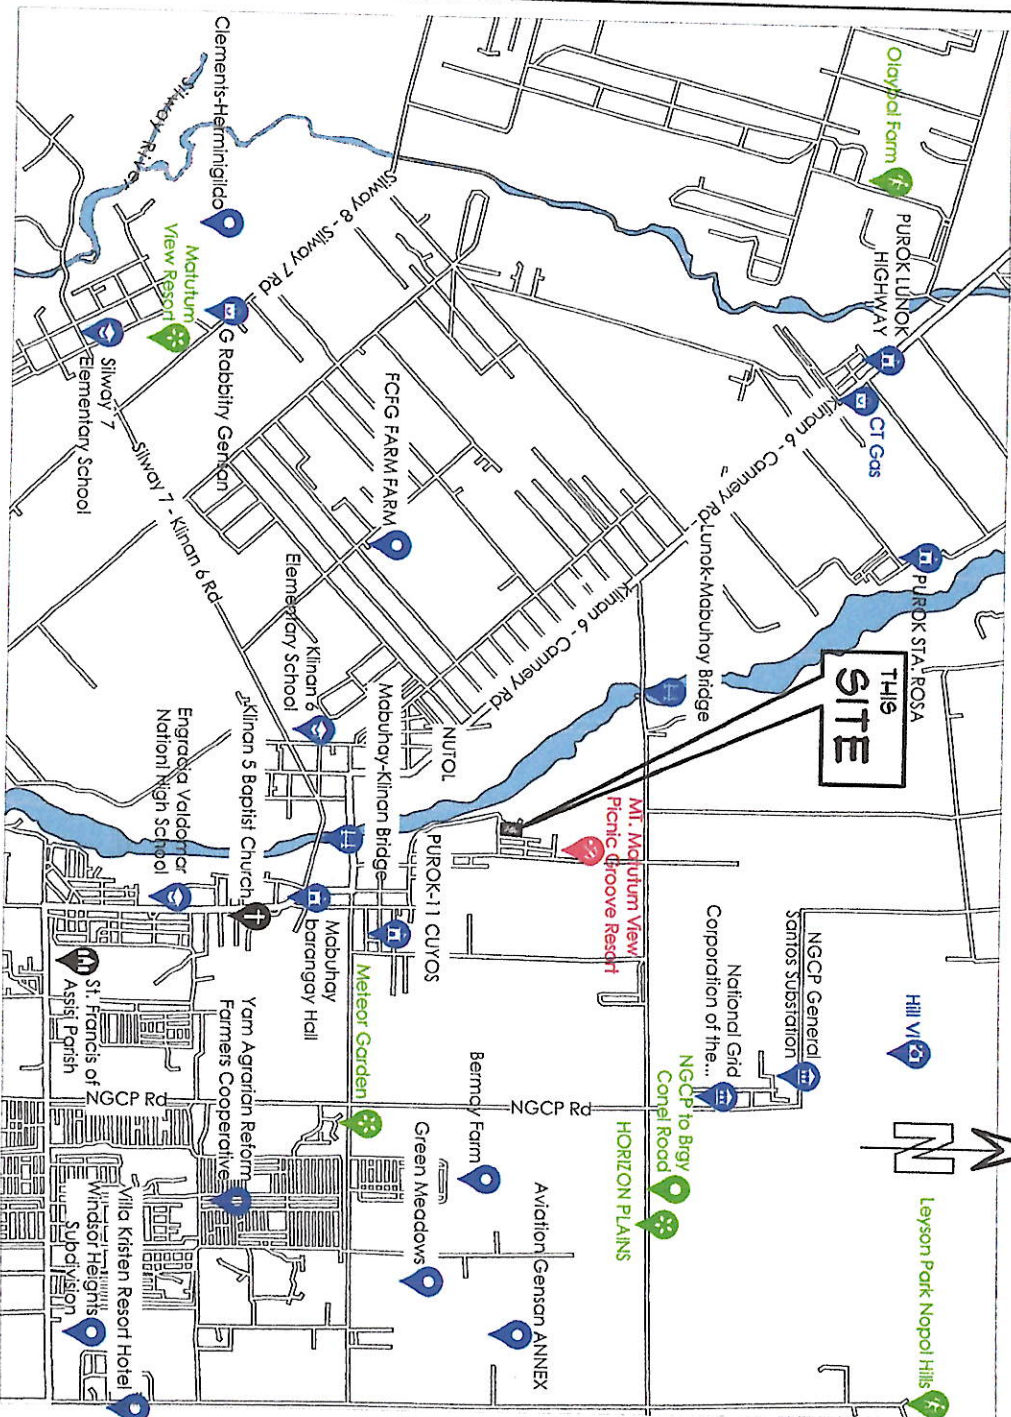

02 VICINITY MAP
A-01 NOT TO SCALE

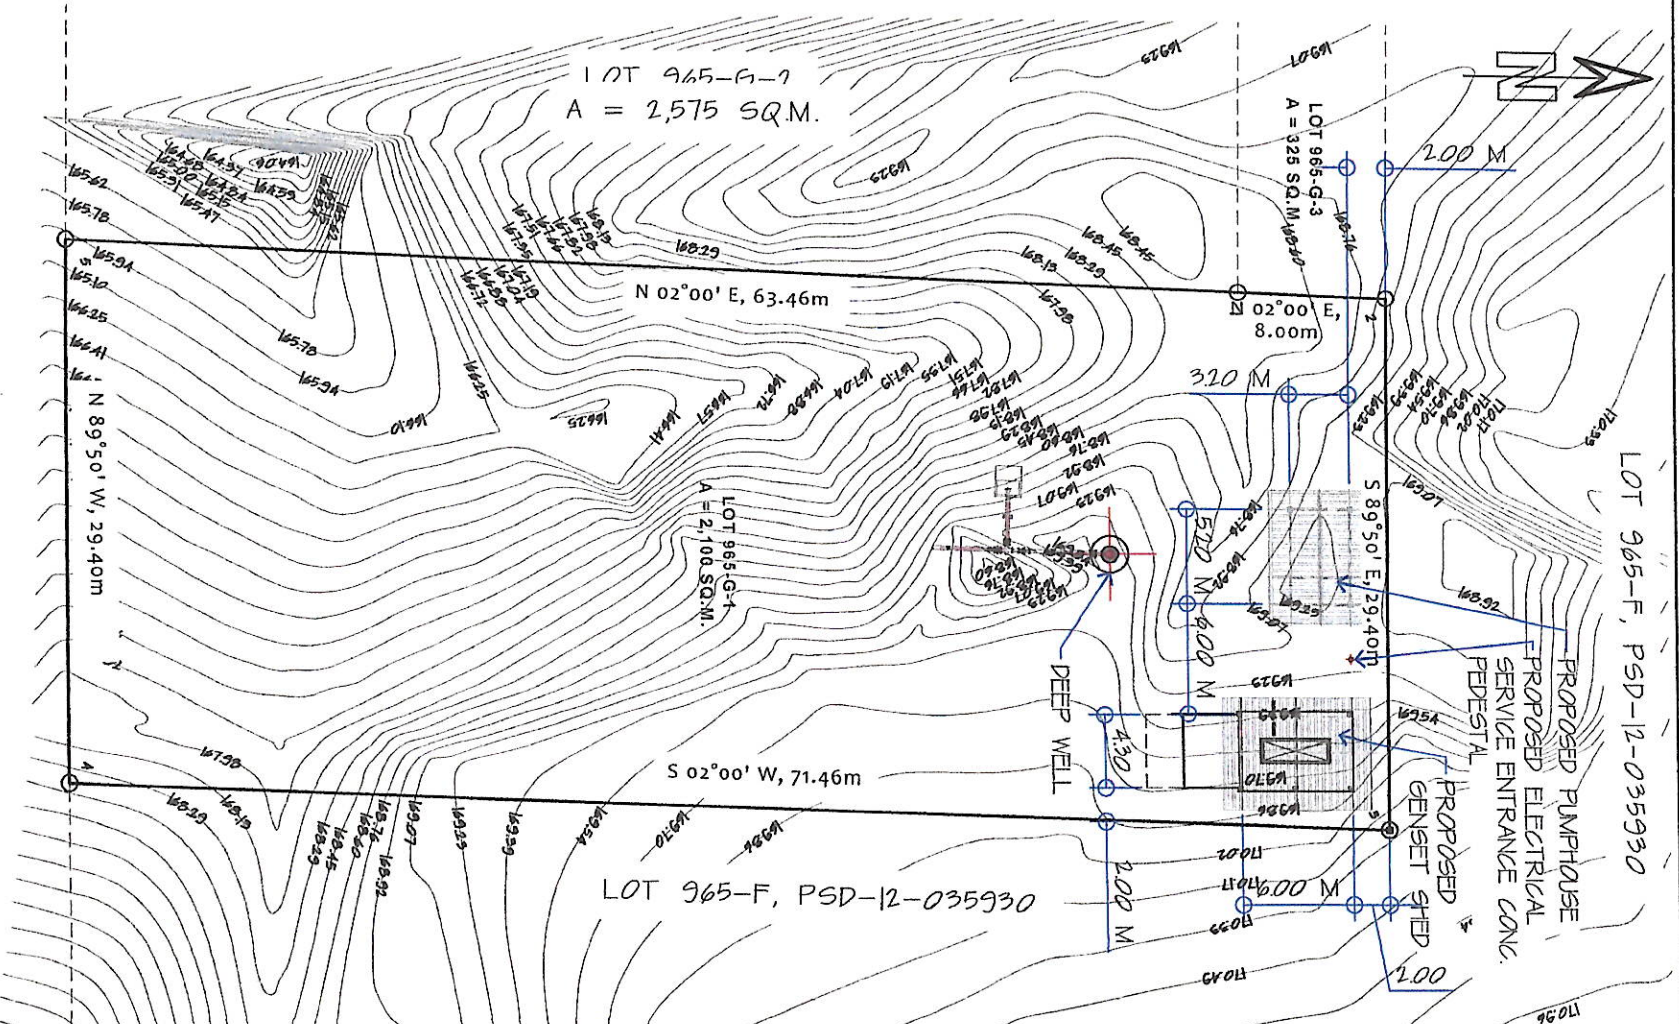

03 SITE DEVELOPMENT PLAN
A-01 SCALE: 1 : 800

GENERAL SANTOS CITY WATER DISTRICT E. FERNANDEZ STREET, BRGY. LAGA, GEN. SANTOS CITY ENGINEERING & CONSTRUCTION DEPARTMENT PLANNING AND DESIGN DIVISION TEL. NO. (083) 582-3824		NOELLE JUSTINE O. ESPESOR REGISTERED ARCHITECT PRC REG. NO. 0052090 ISSUED ON: JAN. 2, 2025 DATE: JAN. 2, 2025		PROJECT AND LOCATION PROPOSED CONSTRUCTION OF PUMP HOUSE & GENSET SHED LOT 965-G-1, BRGY. MABUHAY, GEN. SANTOS CITY		REVIEWED: ENGR. MARIA CELIA N. DANDAN DEPARTMENT MANAGER, ECD		RECOMMENDED APPROVAL: ENGR. ROGELIO A. BEBANA, JR. JAGM, OTS		APPROVED: FRANCISCO F. [Signature] CPA, CESE ACTING GENERAL MANAGER		SHEET CONTENTS AS SHOWN DRAWN BY: [Signature] CHECKED BY: [Signature] DATE: Apr 2025		SHEET NO. A-01 01 15	
--	--	---	--	---	--	--	--	---	--	---	--	---	--	--------------------------------------	--

REPUBLIC OF THE PHILIPPINES
CITY OF GENERAL SANTOS
OFFICE OF THE CITY ENGINEER

OFFICE OF THE BUILDING OFFICIAL

SCHEDULE OF FINISH
FLOORS:


(FL1) PLAIN CEMENT FLOOR FINISH

WALLS:



(WFI) 100mm thk. MACHINE MADE CHB W/ PLAIN CEMENT PLASTER (ACRYLIC PAINT FINISH)

CEILING:


(CL1) 35mm thk FIBER CEMENT BOARD (PAINT FINISH) ON METAL FLURRING CEILING FRAMES. USE 0.6mm thk. x 15mm x 50mm x 5000mm DOUBLE FLURRING CHANNELS @ 0.40m ON CENTER W/ 0.6mm thk. x 38mm x 5000mm CARRYING CHANNELS @ 1.20m ON CENTERS & ROD JOINER (HANGERS/SUPPORTS) @ 1.20m O.C., SHORTER SPAN

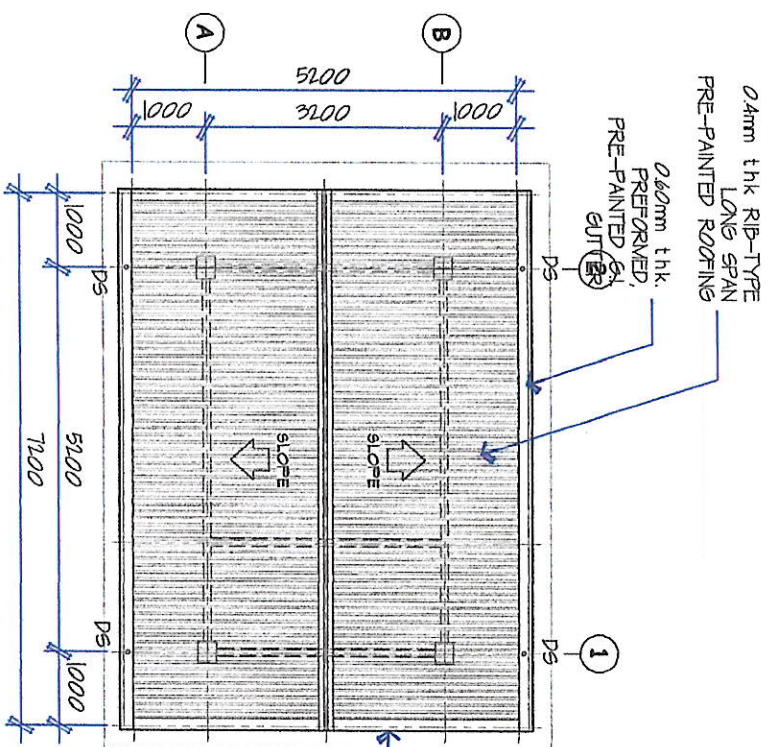


06 ROOF PLAN (PUMPHOUSE)
1:100 M

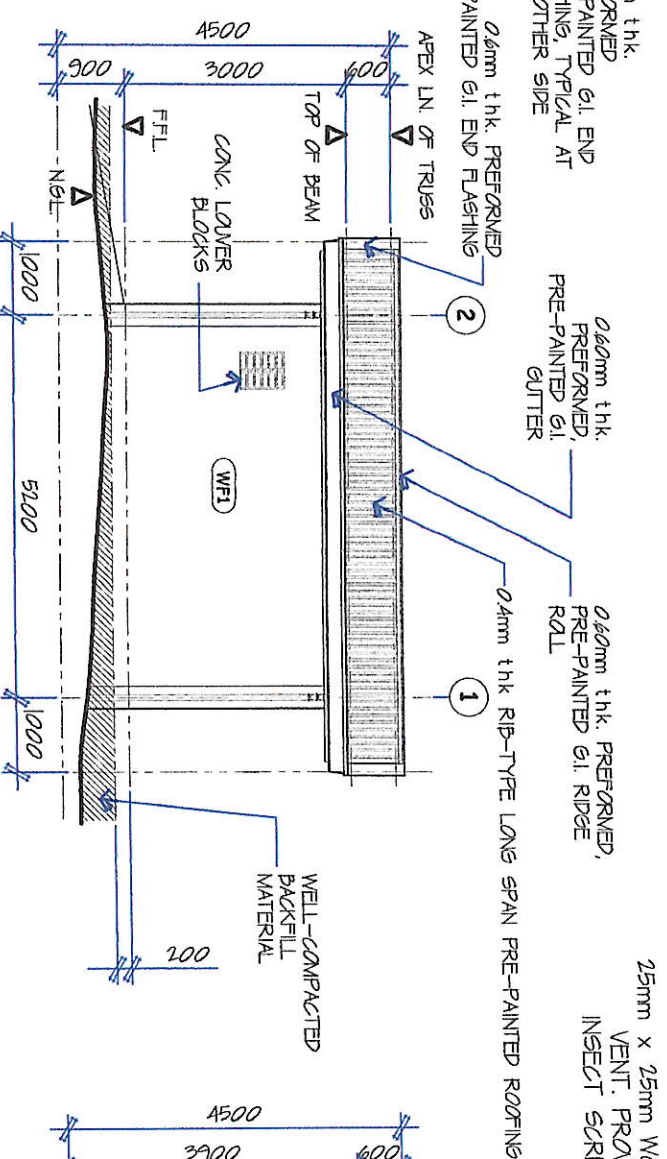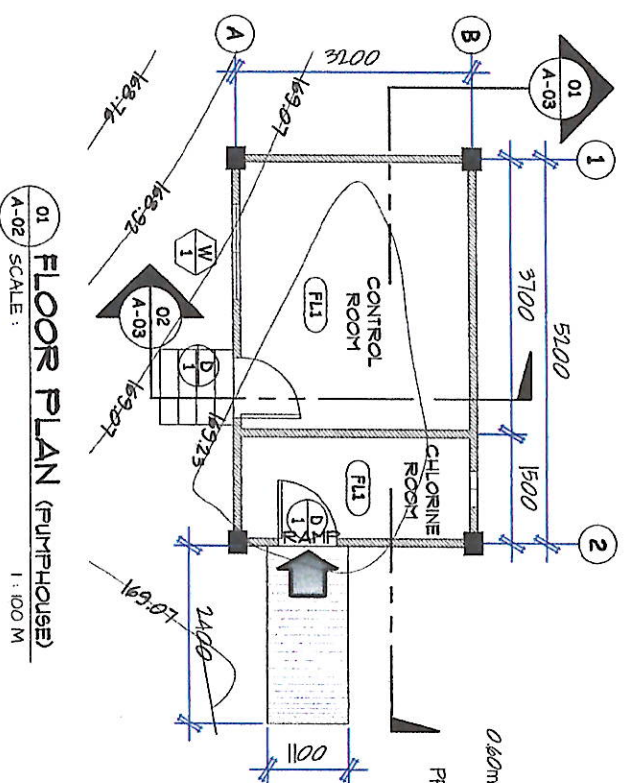


05 REAR ELEVATION (PUMPHOUSE)
1:100 M

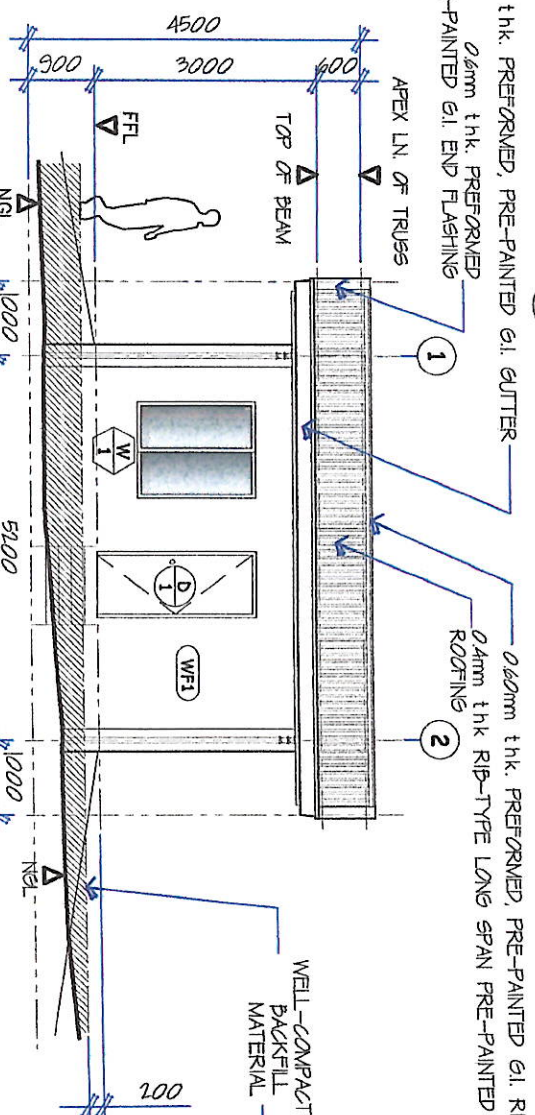


02 FRONT ELEVATION (PUMPHOUSE)
1:100 M

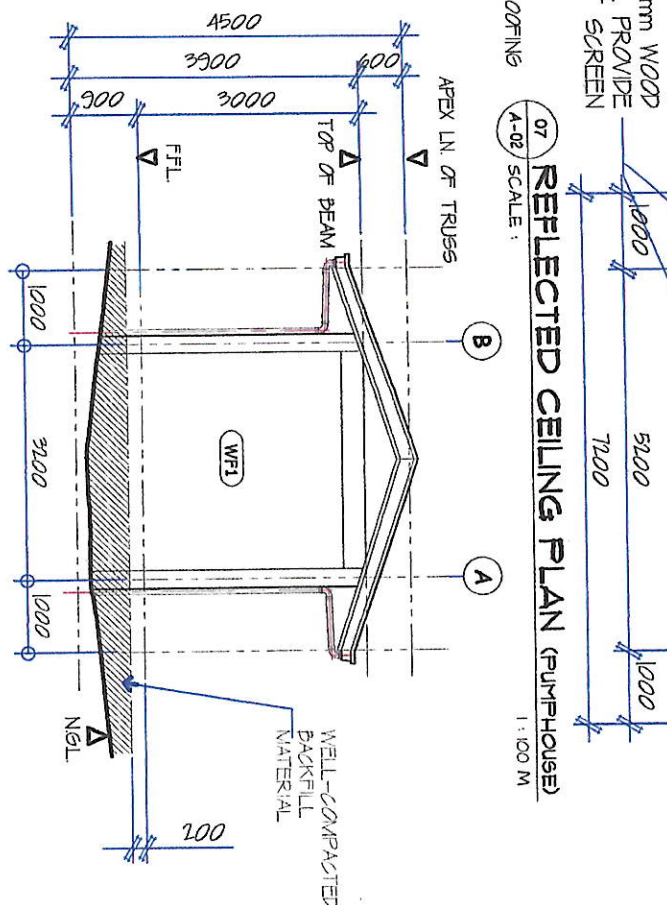

04 LEFT SIDE ELEVATION (PUMPHOUSE)
1:100 M

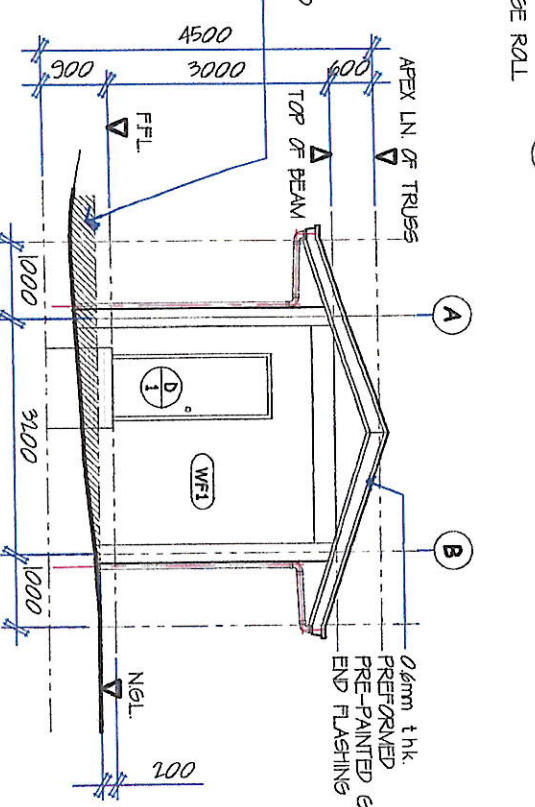

03 RIGHT SIDE ELEVATION (PUMPHOUSE)
1:100 M

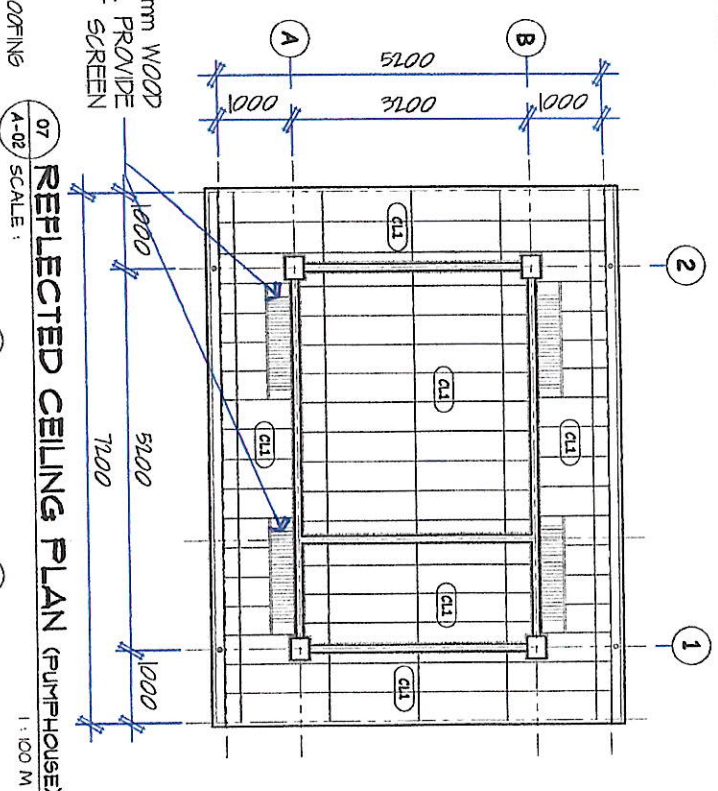

07 REFLECTED CEILING PLAN (PUMPHOUSE)
1:100 M



GENERAL SANTOS CITY WATER DISTRICT
E. FERNANDEZ STREET, BRGY. LAGAO, GEN. SANTOS CITY
ENGINEERING & CONSTRUCTION DEPARTMENT
PLANNING AND DESIGN DIVISION
TEL. NO. (093) 582-3824

NOELLE JUSTINE B. ESPESOR
REGISTERED ARCHITECT
P.R.C. Reg. No. 0052090
P.E. No. 0433757614
ISSUED ON: JAN 2, 2025
ISSUED AT: GENERAL SANTOS CITY

PROJECT AND LOCATION
PROPOSED CONSTRUCTION OF
PUMPHOUSE & GENSET SHED
LOT 965-G-1, BRGY. MABUHAY, GEN. SANTOS CITY


REVIEWED:
ENGINEER MARIA CELIA N. DANDAN
DEPARTMENT MANAGER, ECD

RECOMMEND APPROVAL:
ENGINEER ROGELIO A. BESANA, JR.
AGM, OTS


APPROVED:
FRANCISCO R. ALONSO, JR., CPA, CEBE
ACTING GENERAL MANAGER

SHEET CONTENTS
AS SHOWN
DRAWN BY: [Signature]
REV. NO.
CHECKED BY: [Signature]
DATE: Apr 2025


SHEET NO.
A-02
02
15

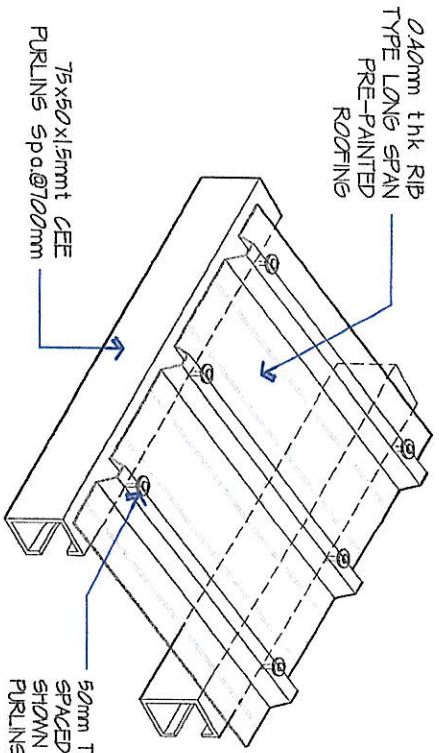


07 ISOMETRIC VIEW OF ROOFING TO PURLINS CONNECTION
A-03 NOT TO SCALE

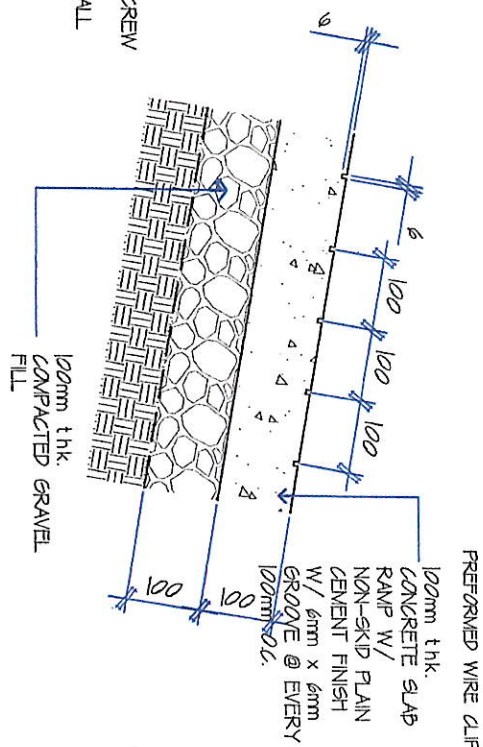


05 SPOT DETAIL
A-03 SCALE: 1:10M

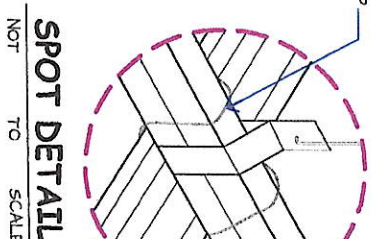



SPOT DETAIL
NOT TO SCALE

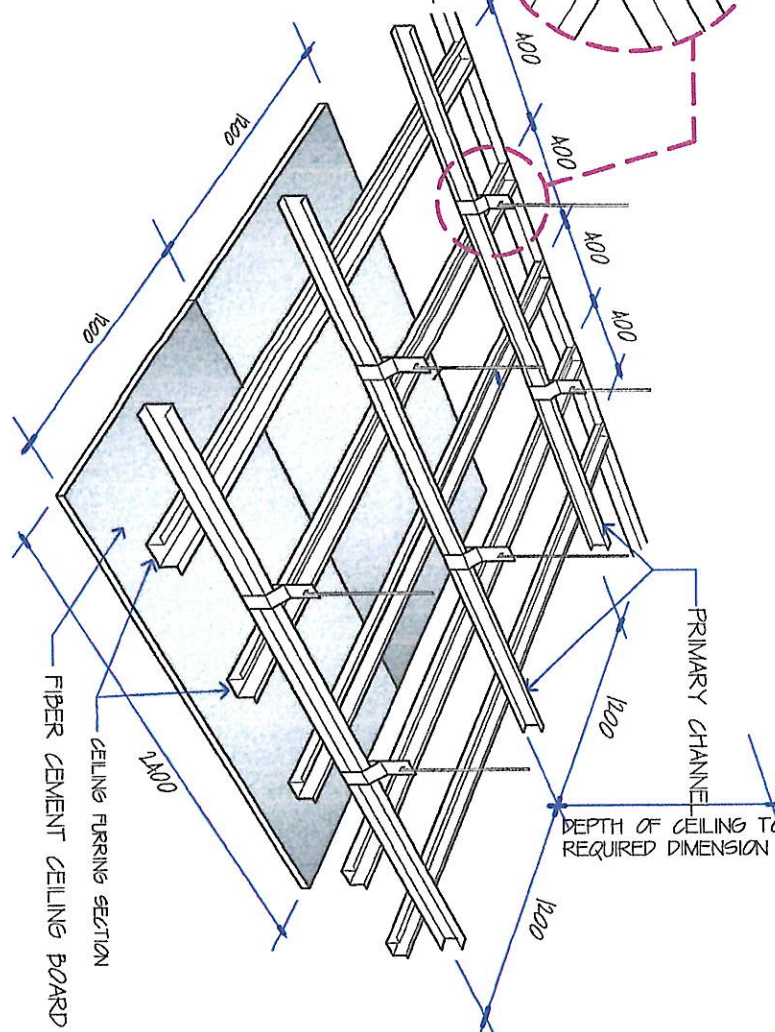

06 PERSPECTIVE, CLI (PUMPHOUSE)
A-03 NOT TO SCALE

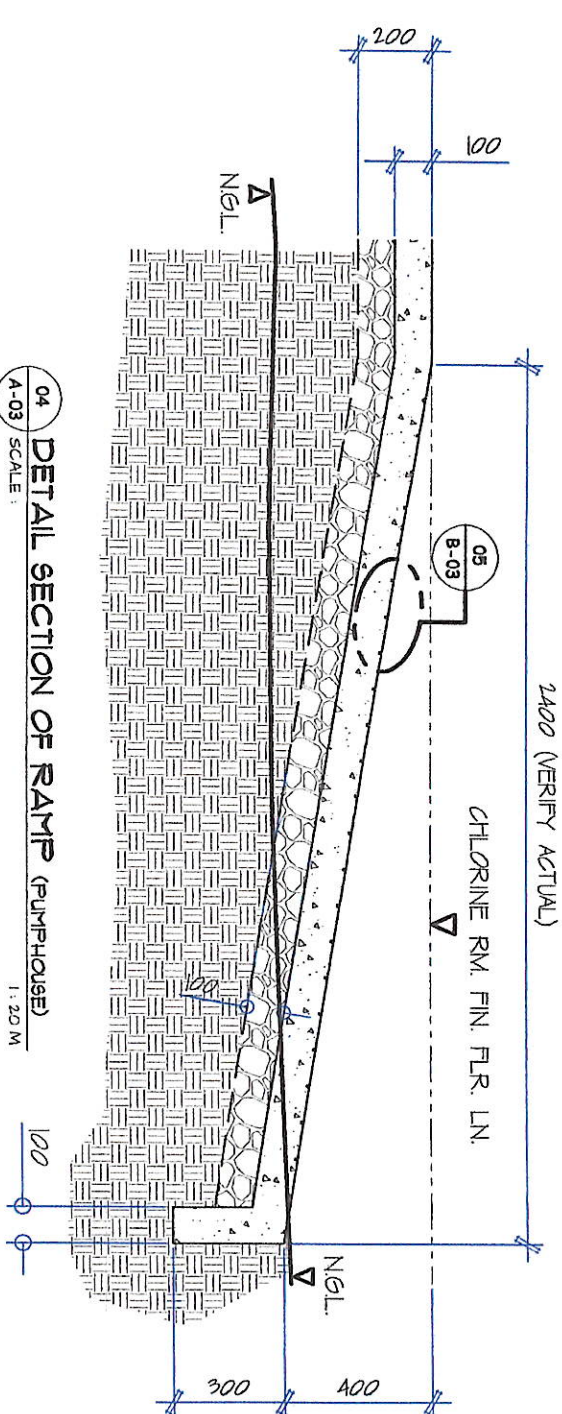

04 DETAIL SECTION OF RAMP (PUMPHOUSE)
A-03 SCALE: 1:20M

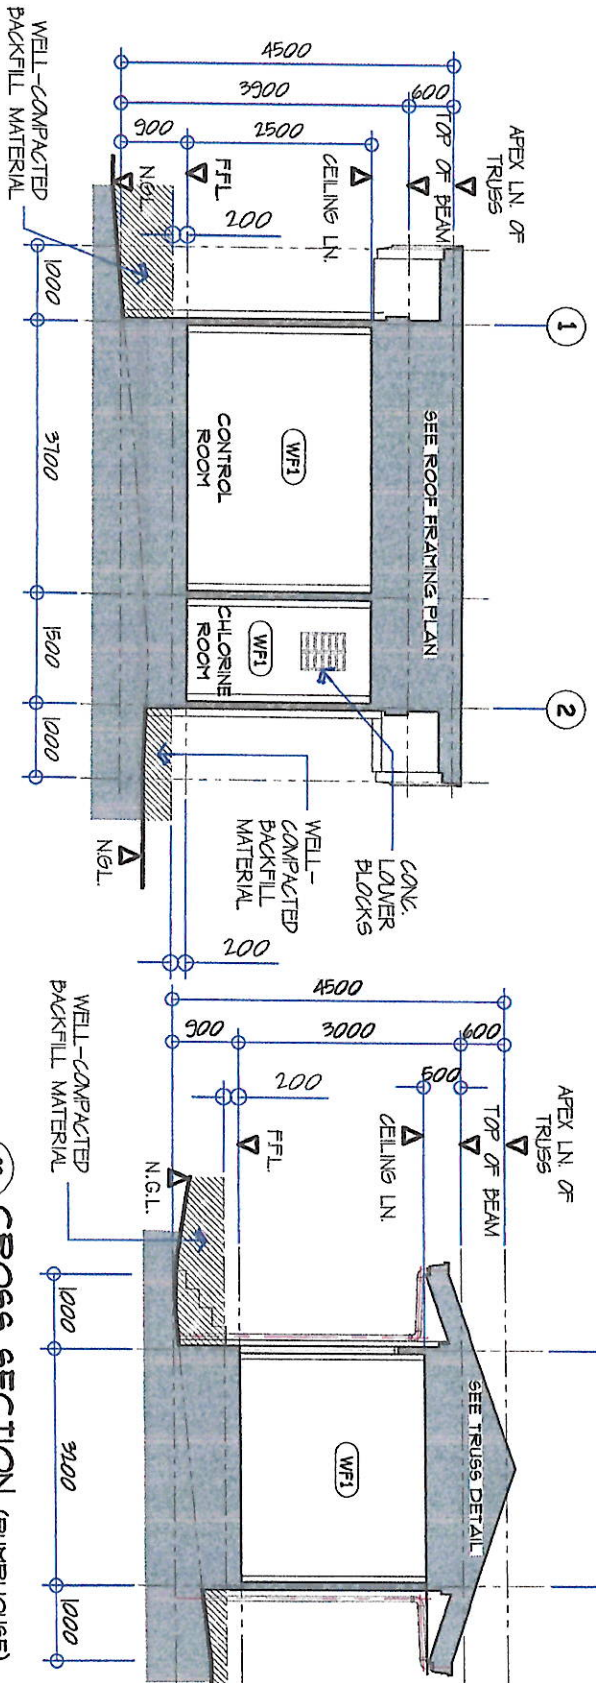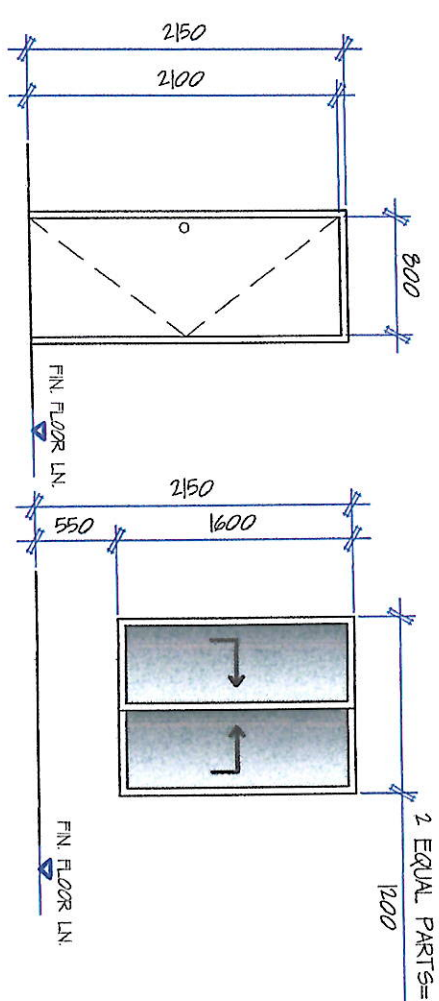

01 LONGITUDINAL SECTION (PUMPHOUSE)
A-03 SCALE: 1:100M

02 CROSS SECTION (PUMPHOUSE)
A-03 SCALE: 1:100M

MARK	DESCRIPTION	LOCATION	QUANTITY
D-1	40mm thick hollow core flush door type in 50 x 150 NO DOOR JAMB WITH 6mm thick MARINE PLYWOOD DOUBLE FACING PAINT FINISH WITH COMPLETE ACCESSORIES	CONTROL ROOM, CHLORINE ROOM	TWO (2) SETS
W-1	SLIDING WINDOW IN POWDER COATED FINISH ALUMINUM FRAME WITH 6mm thick TINTED GLASS PANEL WITH COMPLETE ACCESSORIES	CONTROL ROOM	ONE (1) SET

03 SCHEDULE OF DOORS & WINDOWS (PUMPHOUSE)
A-03 SCALE: 1:50M

GENERAL SANTOS CITY WATER DISTRICT
E. FERNANDEZ STREET BRGY. LUGAO, GEN. SANTOS CITY
ENGINEERING & CONSTRUCTION DEPARTMENT
PLANNING AND DESIGN DIVISION
TEL. NO. (093) 582-3824

NOEL JUSTINE B. ESPESOR
REGISTERED ARCHITECT
PRC Reg. No. 0052090
REGISTERED ARCHITECT
P.R. No. 0052090
DATE: JAN 2, 2025

PROJECT AND LOCATION
PROPOSED CONSTRUCTION OF PUMPHOUSE & GENSET SHED
LOT 965-G-1, BRGY. MABUHAY, GEN. SANTOS CITY

REVIEWED:
ENGR. MARIA CELIA N. DAUDAN
DEPARTMENT MANAGER, ECD

RECOMMEND APPROVAL:
ENGR. ROGELIO A. BESPANA, JR.
AGM, OTS

APPROVED:
FRANCISCO R. BESPANA, JR., CPA, CEEB
ACTING GENERAL MANAGER

SHEET CONTENTS
AS SHOWN



SHEET NO.
A-03

Issued At : GENERAL SANTOS CITY
TIN : 737-426-913-000

DATE : Apr 2025

03




15

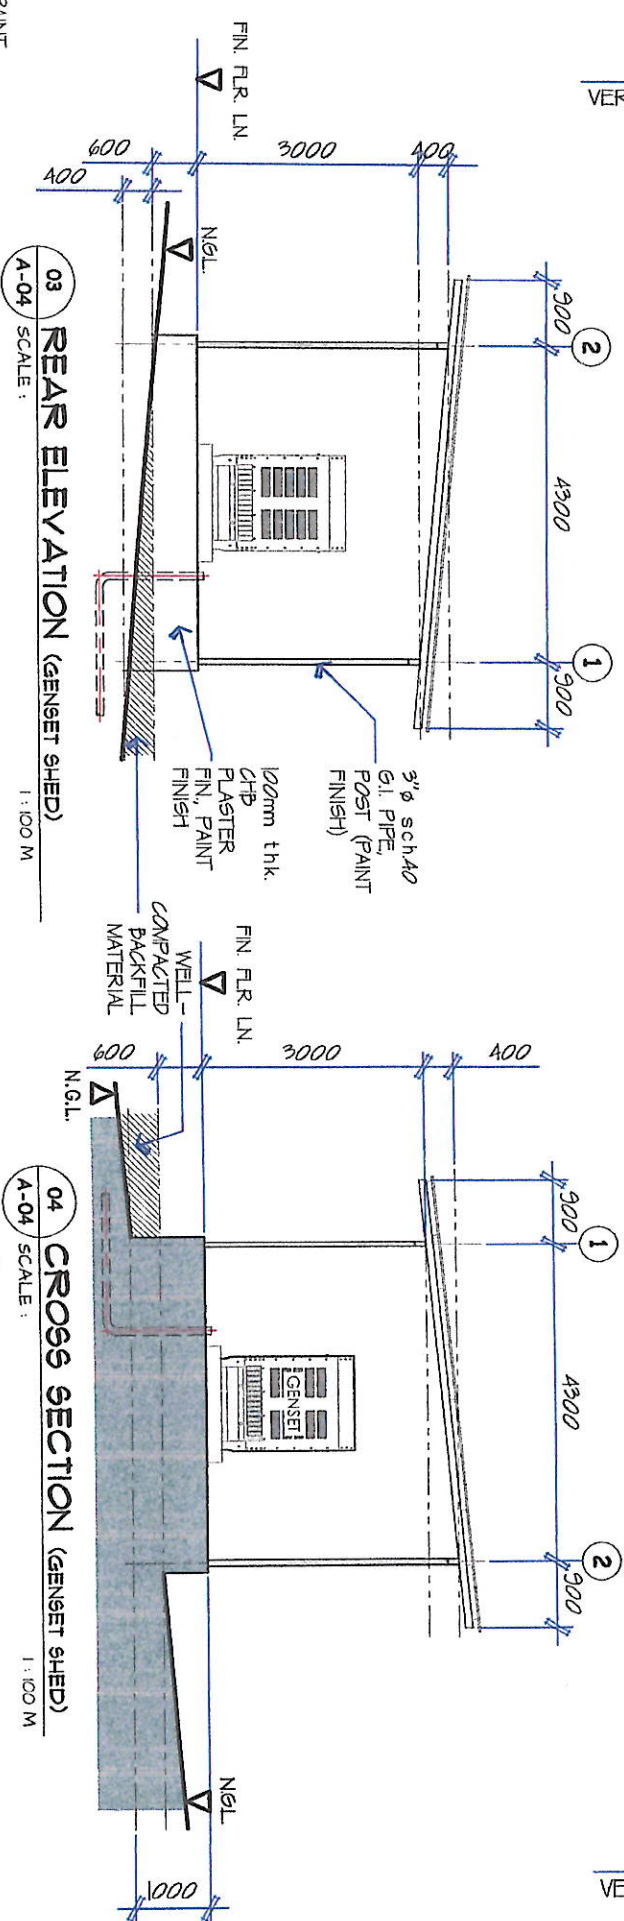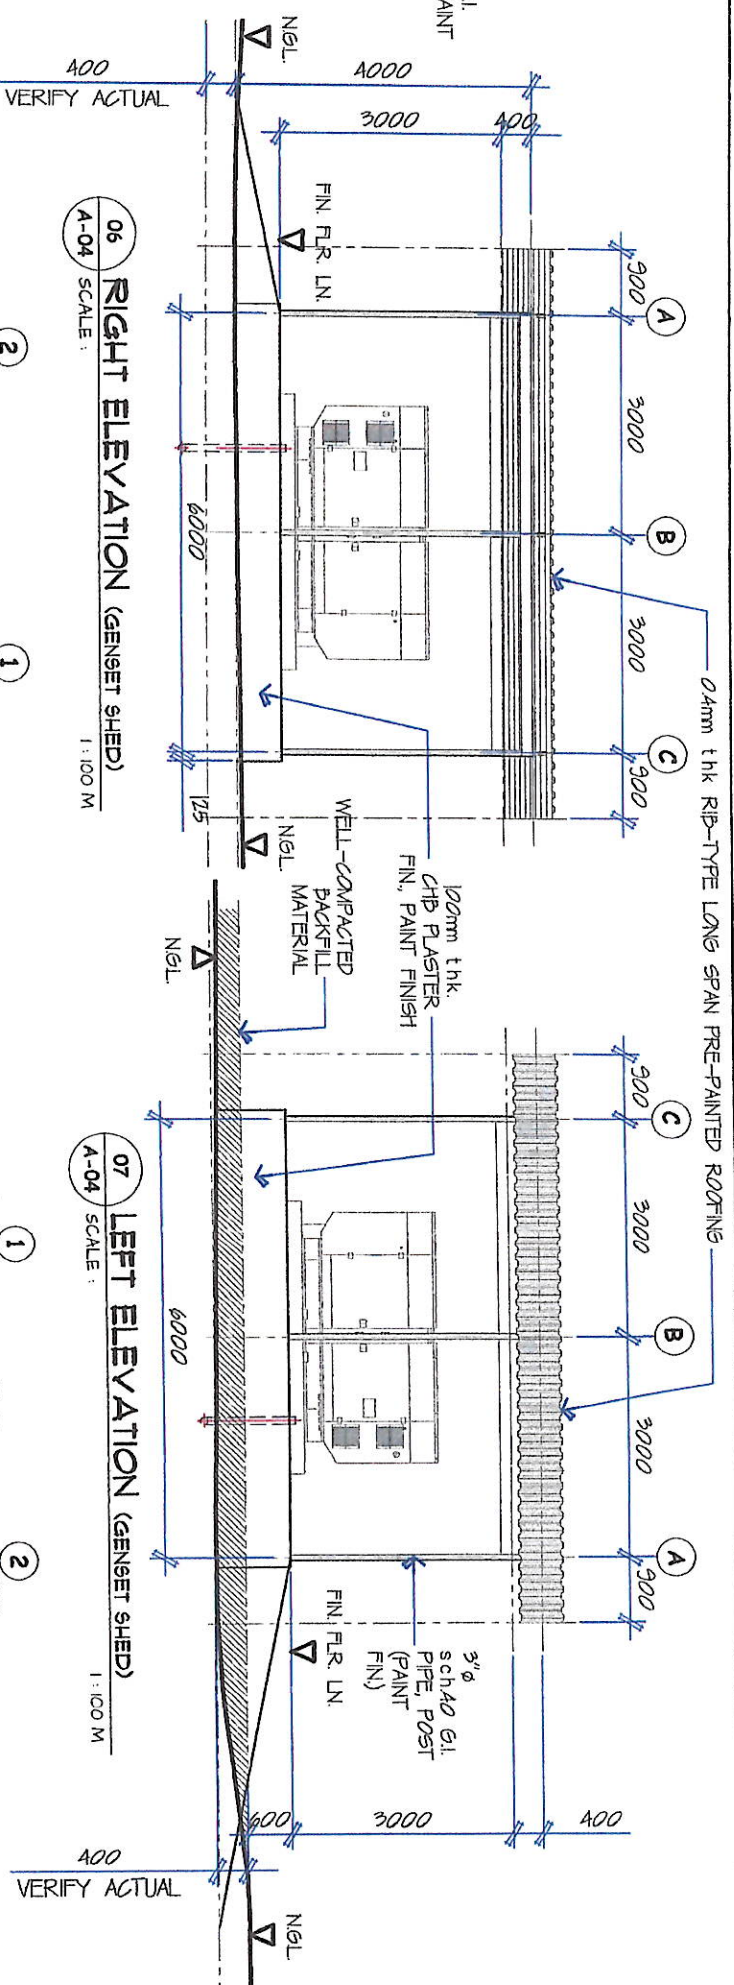



01 FLOOR PLAN (GENSET SHED)
A-04 SCALE : 1 : 100 M

04	A-04
----	------

    
GENERAL SERVICES CITY
737-426-913-001



 GENERAL SANTOS CITY WATER DISTRICT E. FERNANDEZ STREET, BRGY. LAGJO, GEN. SANTOS CITY ENGINEERING & CONSTRUCTION DEPARTMENT PLANNING AND DESIGN DIVISION TEL. NO. (083) 552 - 3824			NOELIE JUSTINE B. ESPESOR REGISTERED ARCHITECT PRC Reg. No. 0052090 LICENSED ARCHT		
PROJECT AND LOCATION PROPOSED CONSTRUCTION OF PUP/HOUSE # GENNET SHED			REVIEWED:  ENGR. MARIA PELLA N. DANDAN DEPARTMENT MANAGER ECD		
RECOMMEND APPROVAL:  ENGR. RODOLFO A. BESANA, JR. AEM, OTS			APPROVED:  FRANCISCO R. ALOD, JR. CPA, CESE ACTING GENERAL MANAGER		
SHEET CONTENTS AS SHOWN			SHEET NO. A-05		
DRAWN BY:  CHECKED BY:  DATE: Apr 2025			05 15		

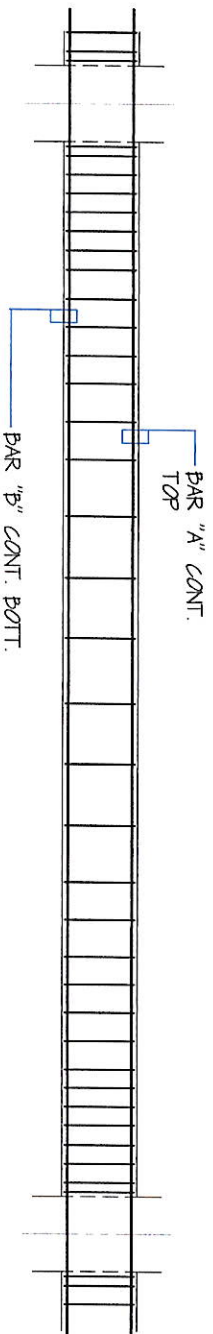


05 TYP. R.C. BEAM ELEVATION (PUMPHOUSE)
S-01 NOT TO SCALE

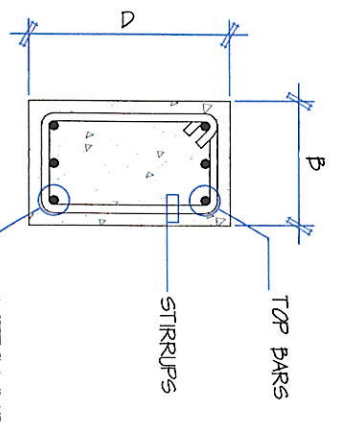


SPACING OF STIRRUPS				
A - Ø10mm - 1@50, 6@100, 4@150, 2@200, REST @ 300mm O.C.				
BEAM MARK	SIZES		REINFORCEMENT	
	WIDTH	DEPTH	BAR "A"	BAR "B"
RCB-1	B	D	CONT. TOP	CONT. BOT.
	200	300	3 - Ø12mm	3 - Ø12mm
SPACING OF STIRRUPS				A



NOTE:
ALL REINFORCEMENT BARS SHALL BE GRADE 40 UNLESS OTHERWISE SPECIFIED IN THE DRAWING

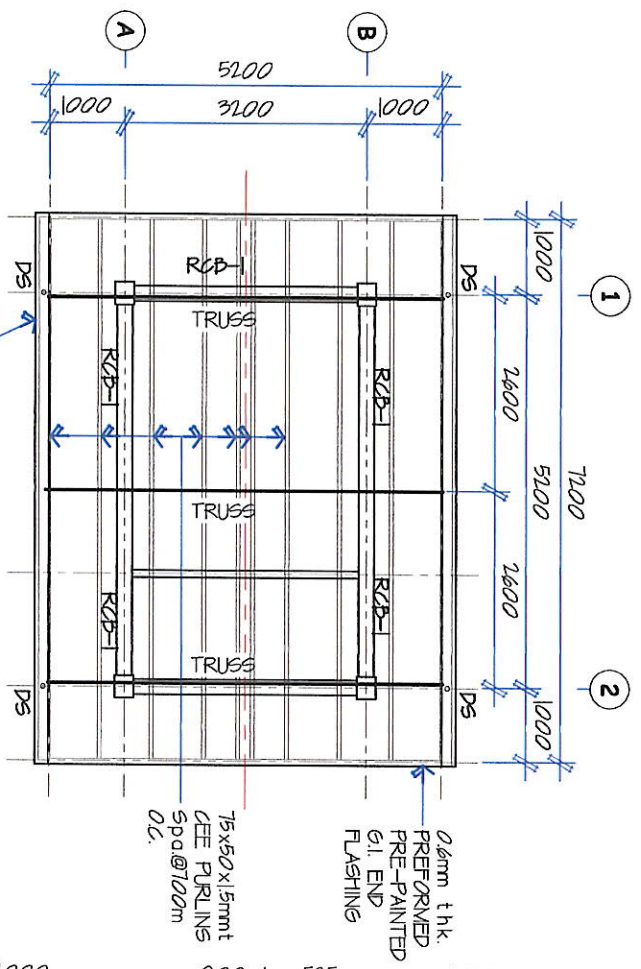


02 ROOF FRAMING PLAN (PUMPHOUSE)
S-01 SCALE: 1:100 M

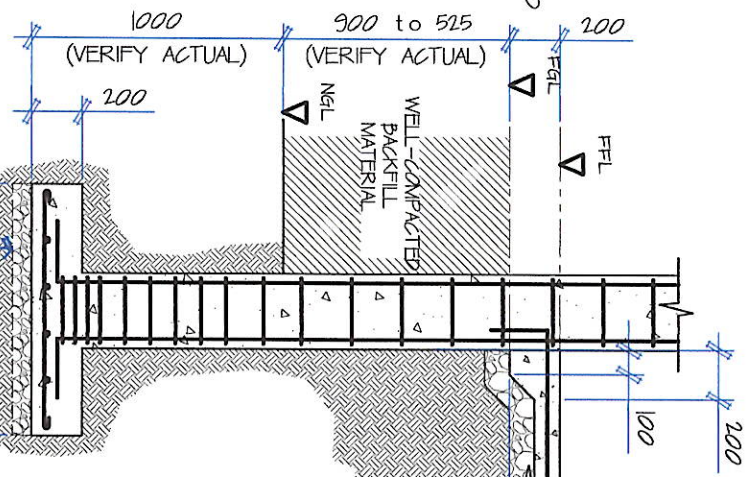


06 DETAIL SECTION OF R.C. RAMP (PUMPHOUSE)
S-01 SCALE: 1:20 M

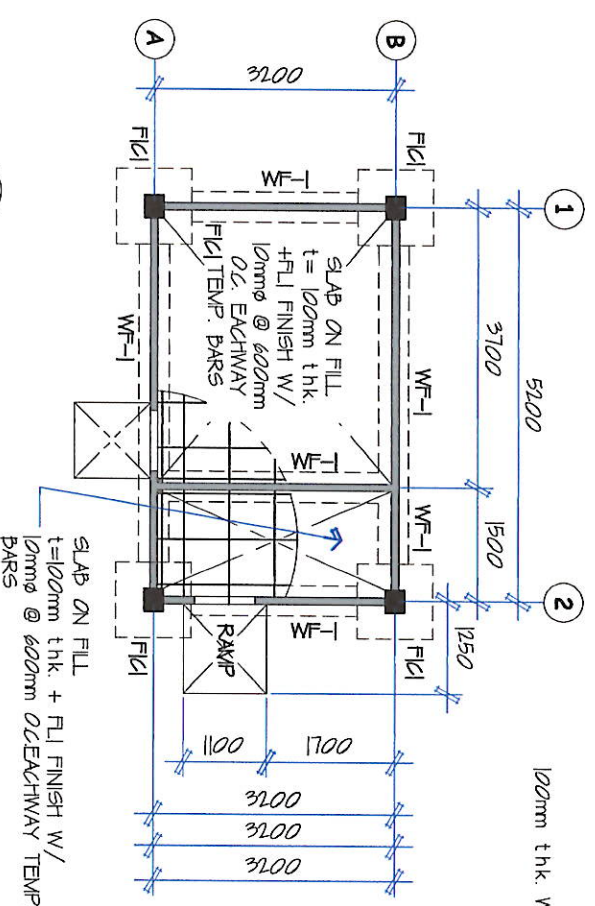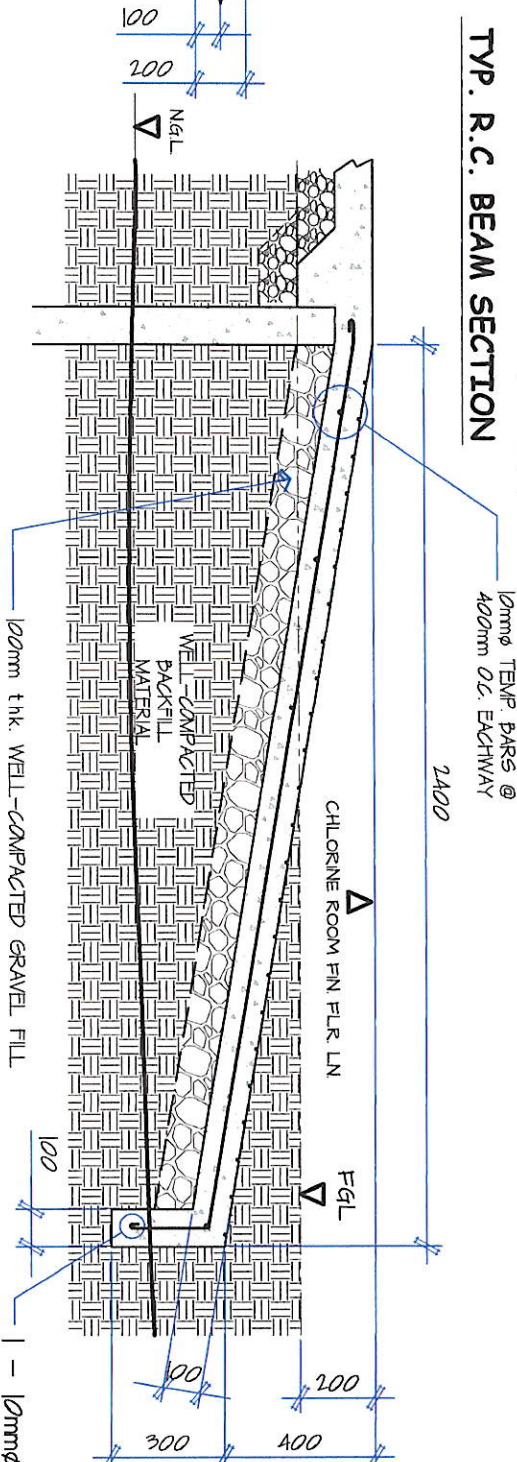

01 FOUNDATION PLAN (PUMPHOUSE)
S-01 SCALE: 1:100 M

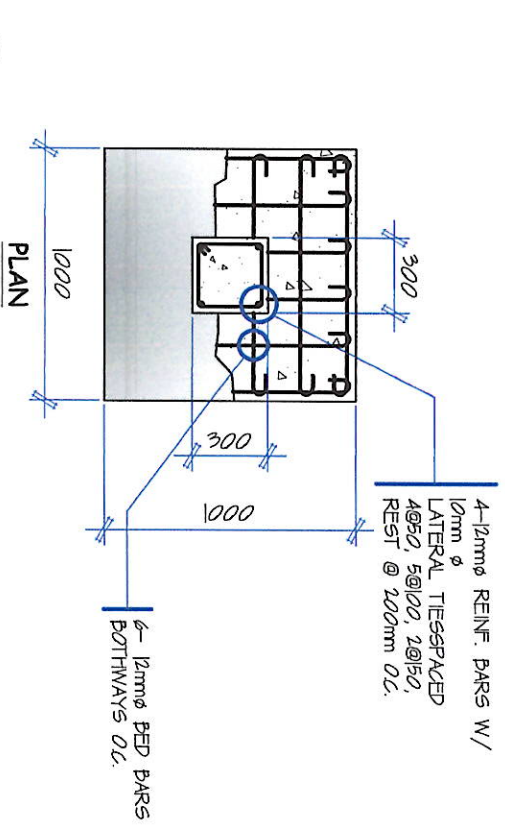

03 FICI DETAIL (PUMPHOUSE)
S-01 SCALE: 1:30 M

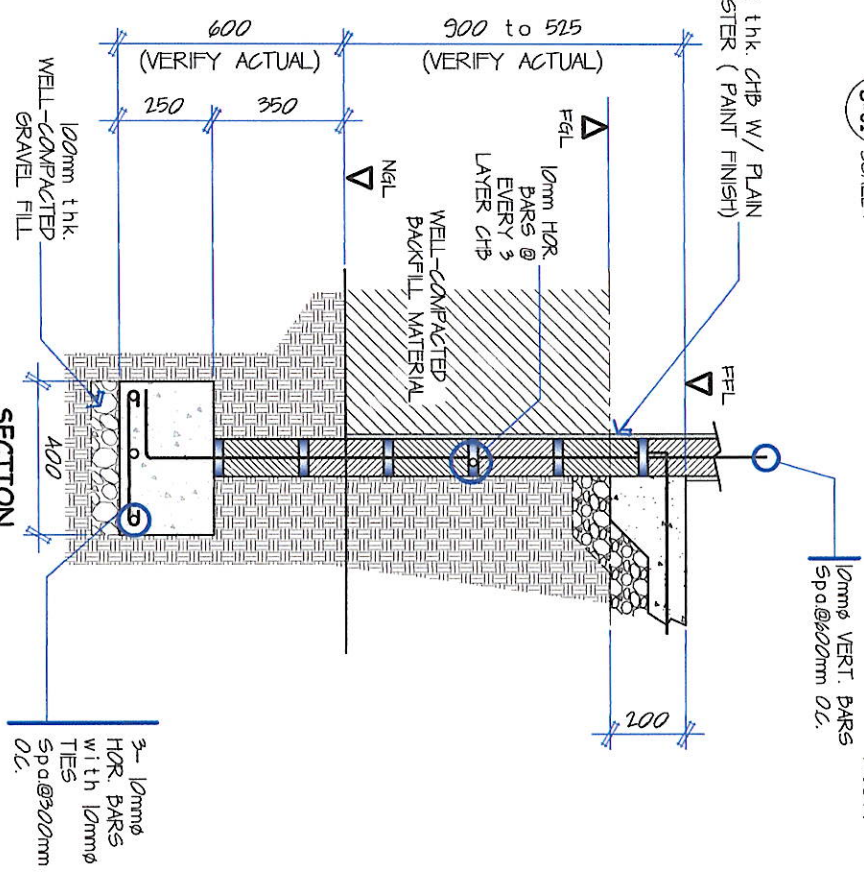

04 WF-1 DETAIL (PUMPHOUSE)
S-01 SCALE: 1:20 M



GENERAL SANTOS CITY WATER DISTRICT
E. FERNANDEZ STREET, BRGY. LIGAO, GEN. SANTOS CITY
ENGINEERING & CONSTRUCTION DEPARTMENT
TEL. NO.: (083) 592-3824

DANILON M. SOLADOR, JR.
CIVIL ENGINEER
REG. NO. 0107545
PIN NO. 1539180A

PROPOSED CONSTRUCTION OF PUMPHOUSE & GENSET SHED

ENG. MARIA CELIA N. DANDAN
DEPARTMENT MANAGER ECD

ENG. ROGELIO A. BESANA, JR.
ACM, OTS

FRANCISCO R. ALLOD, JR., CPA, CESE
ACTING GENERAL MANAGER

AS SHOWN

S-01

06

15

DATE: Apr 2025

CHECKED BY: [Signature]

REV. NO.

SHEET NO.


PROJECT AND LOCATION

REVIEWED:


RECOMMEND APPROVAL:

APPROVED:


SHEET CONTENTS

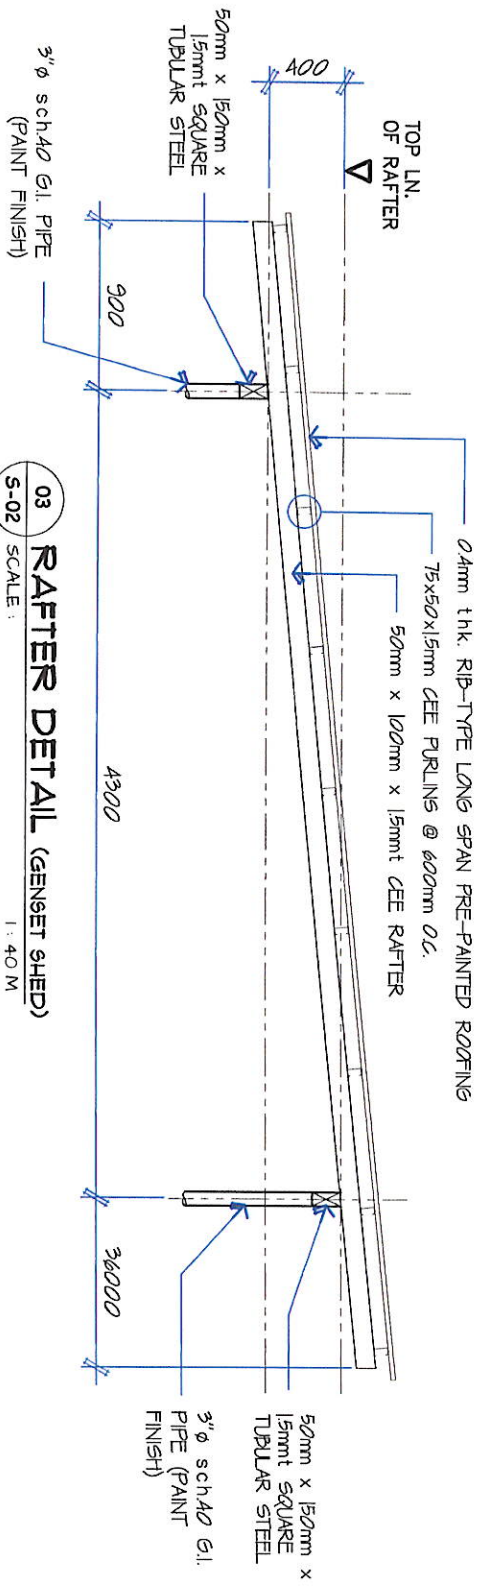


03 RAFTER DETAIL (GENSET SHED)
SCALE: 1:40 M

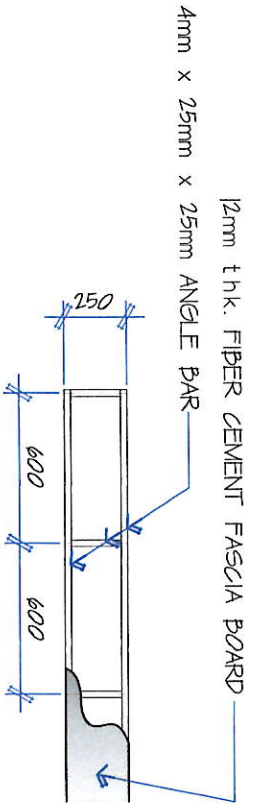

04 FASCIA FRAME DETAIL (PUMPHOUSE)
SCALE: 1:30 M




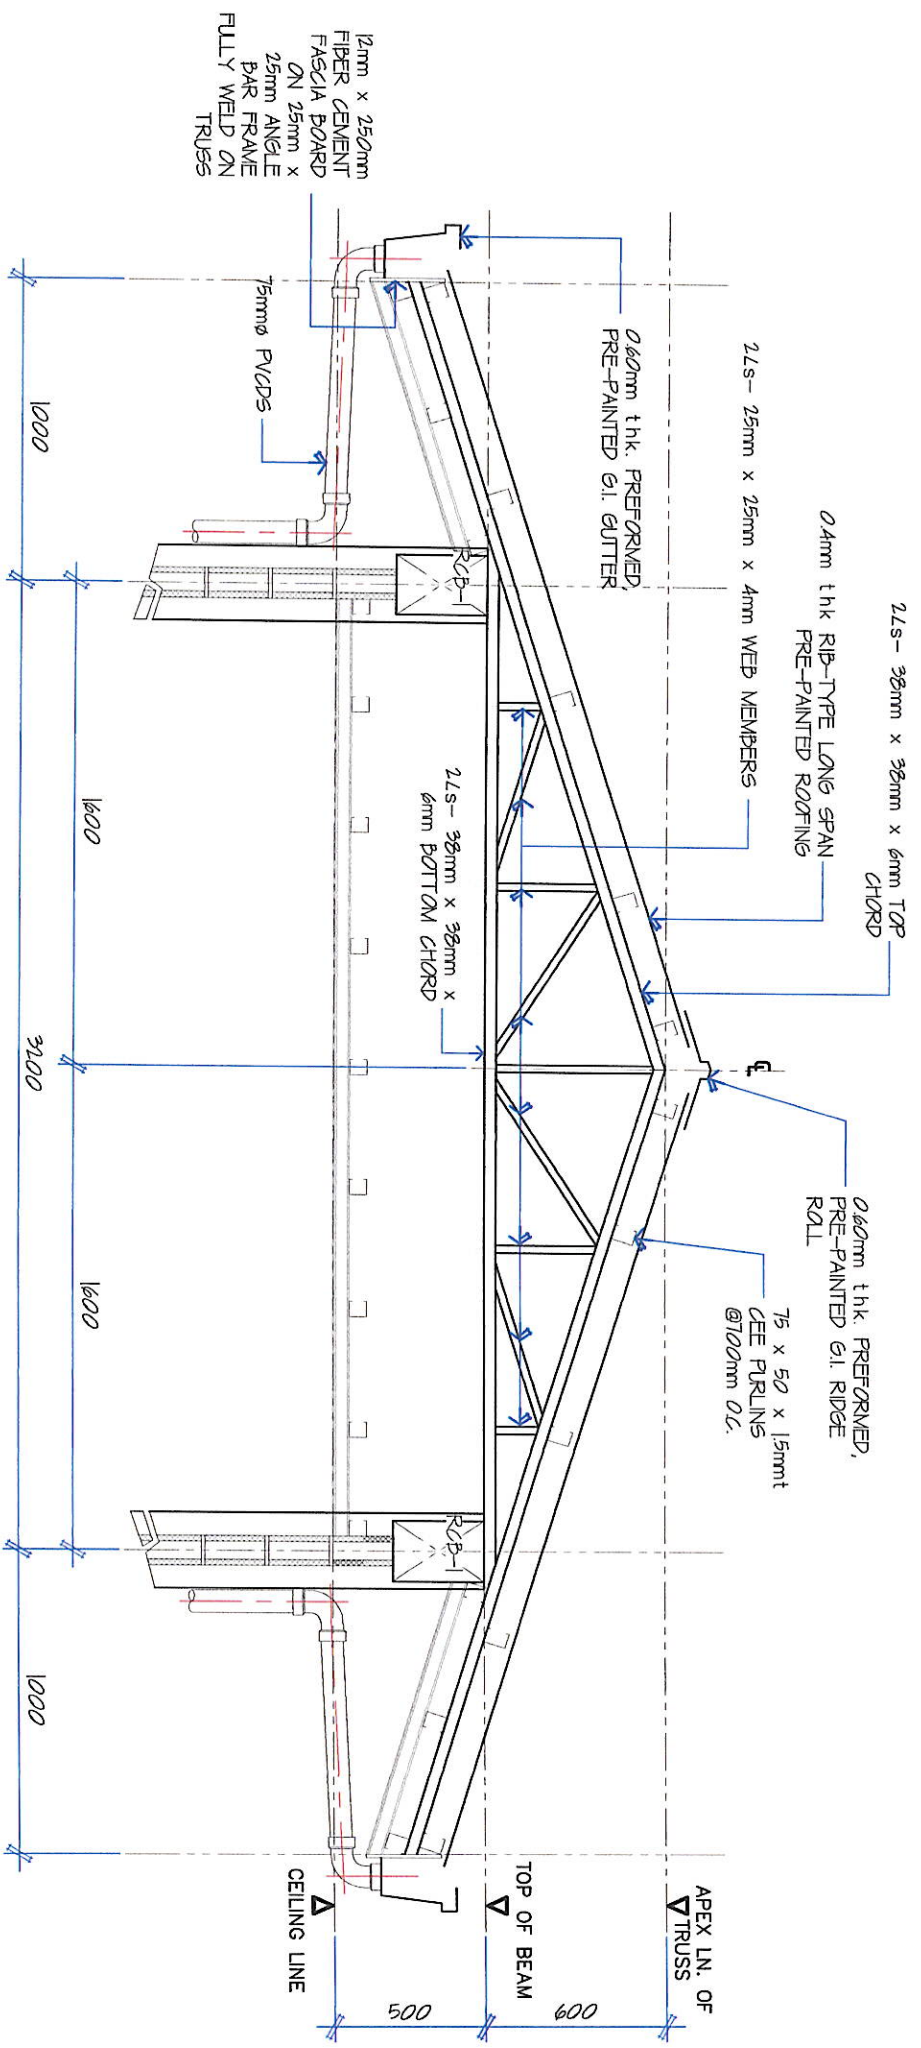




01 DETAIL ELEVATION OF TRUSS (PUMPHOUSE)
SCALE: 1:25 M

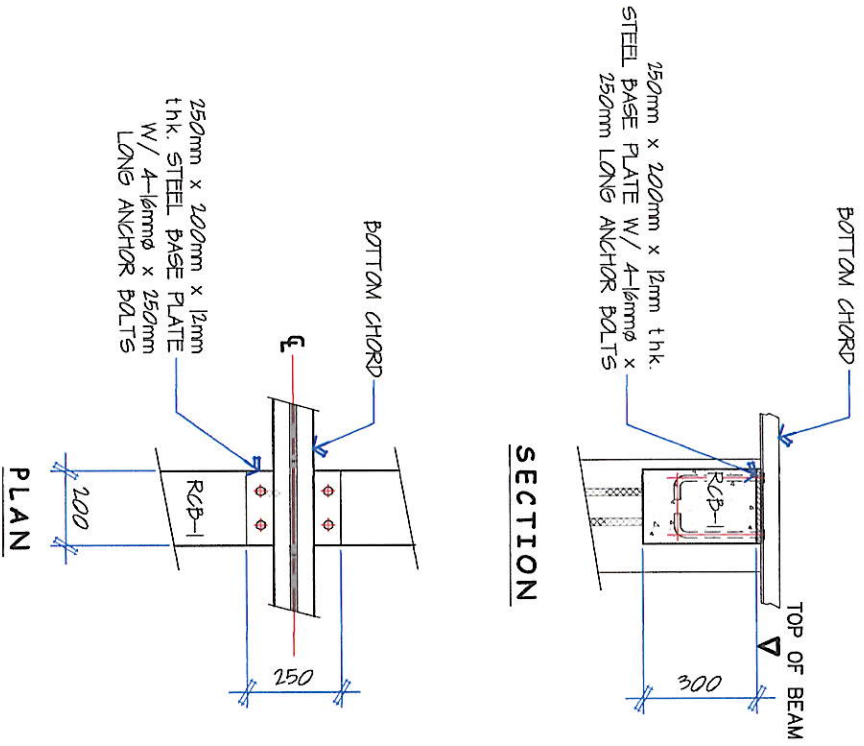


02 DETAIL OF TRUSS ANCHORAGE (PUMPHOUSE)
SCALE: 1:20 M

 GENERAL SANTOS CITY WATER DISTRICT E. FERNANDEZ STREET, BRGY. LAGAO, GEN. SANTOS CITY ENGINEERING & CONSTRUCTION DEPARTMENT PLANNING AND DESIGN DIVISION TEL. NO.: (083) 532-3824		DANILO M. SORLADOR, JR. CIVIL ENGINEER REG. NO. 0107545 TIN. NO. 291-941-997		PROPOSED CONSTRUCTION OF PUMPHOUSE & GENSET SHED		ENGR. MARIA CELIA N. DANDAN DEPARTMENT MANAGER ECD		ENGR. ROGELIO A. BESANA, JR. AGM, OTS		FRANCISCO R. ALONSO, JR., CPA, CESE ACTING GENERAL MANAGER		AS SHOWN		S-02	
PRJ. NO. 1539180A		DATE: 01/09/2025		LOT 965-G-1, BRGY. MABUHAY, GEN. SANTOS CITY								DRAWN BY: <i>Day-Ric</i>		REV. NO.	
												CHECKED BY:		DATE: Apr 2025	
														07	
														15	

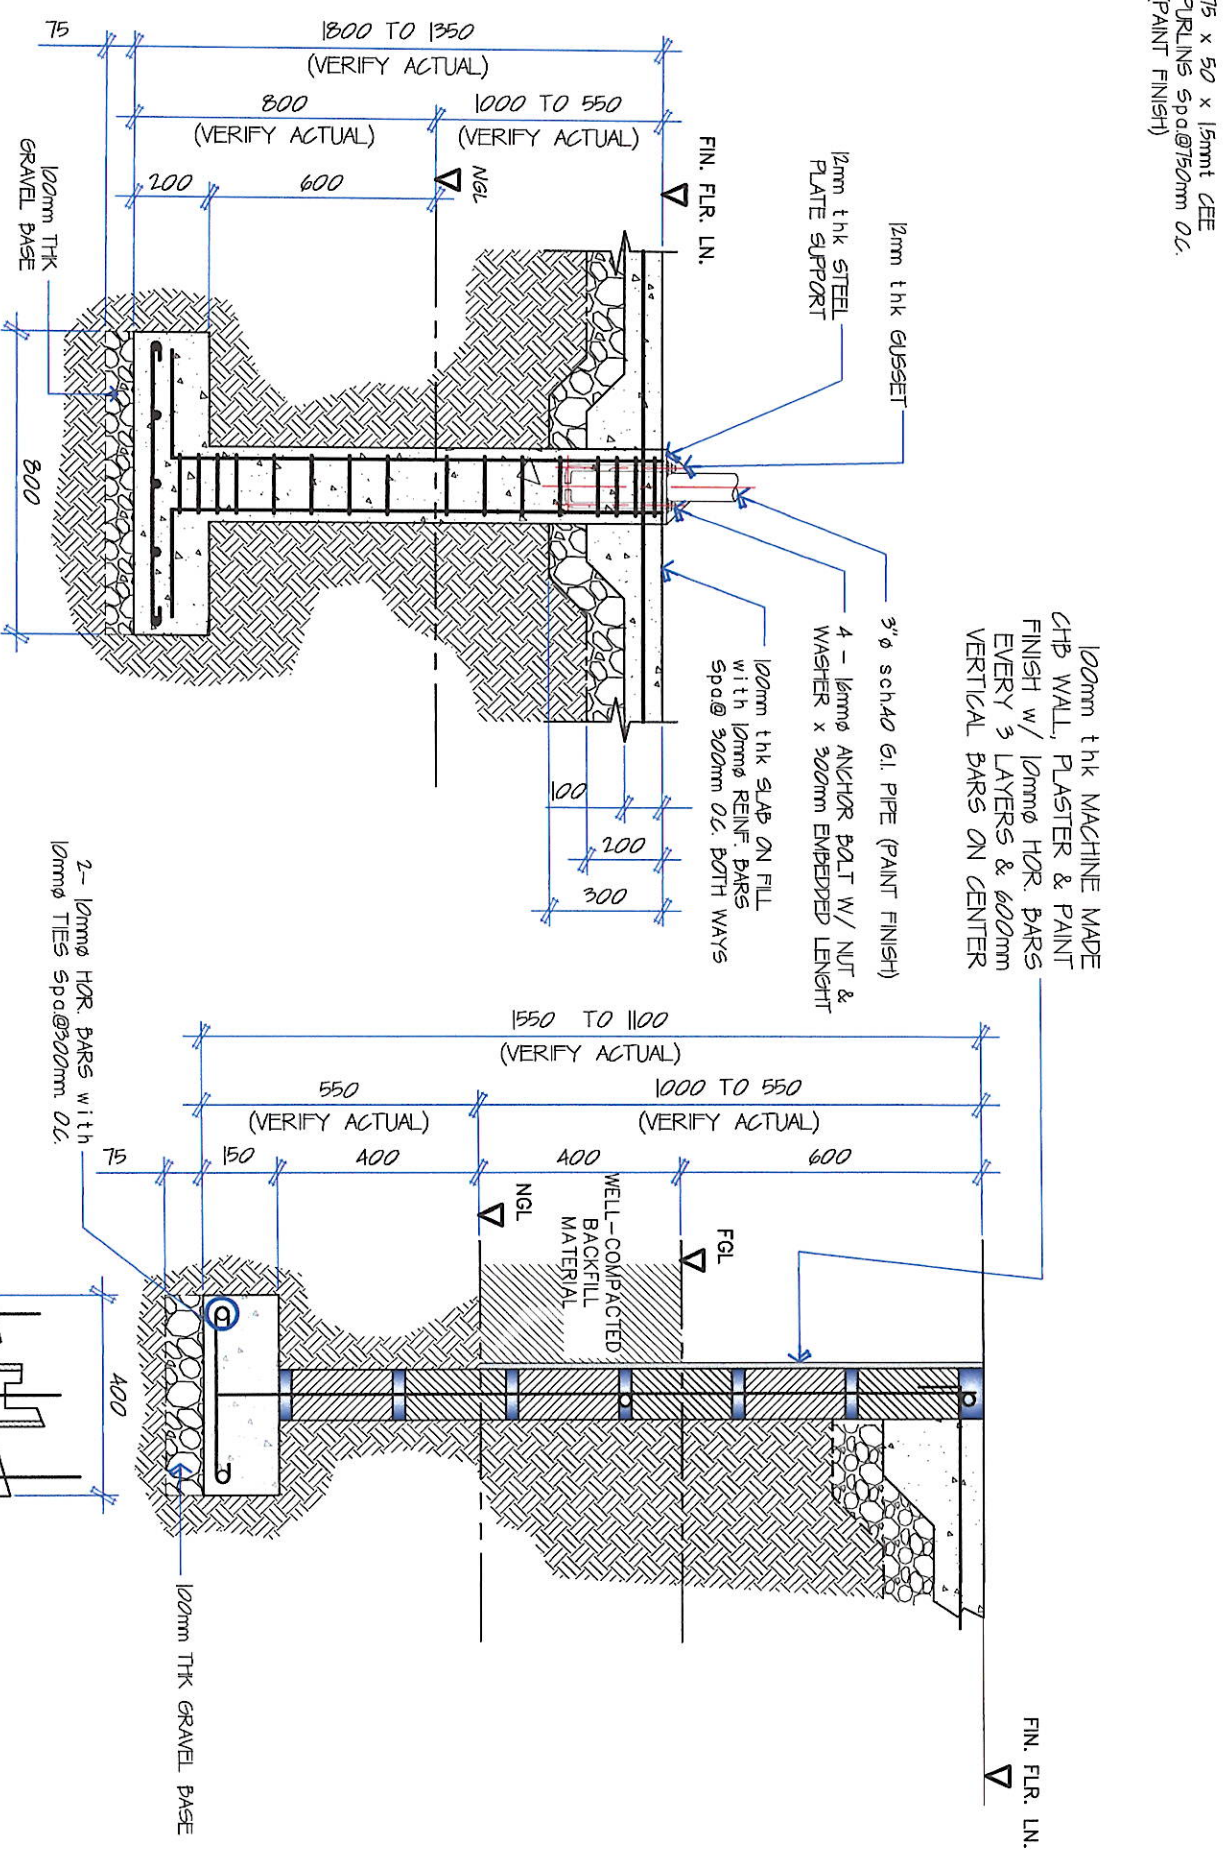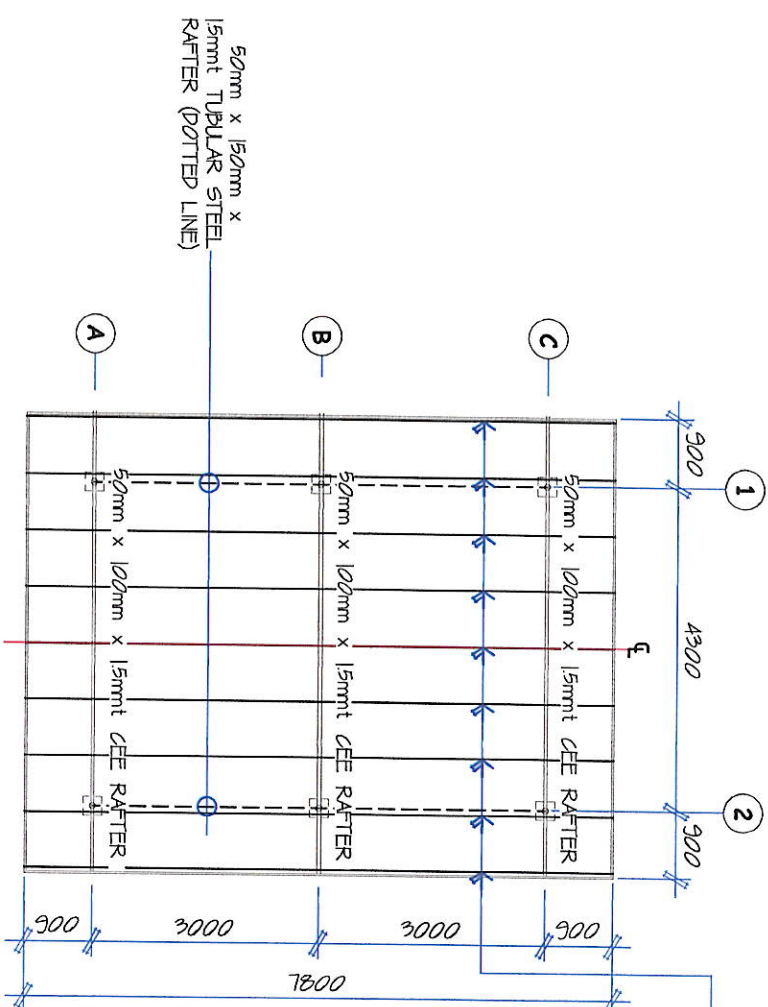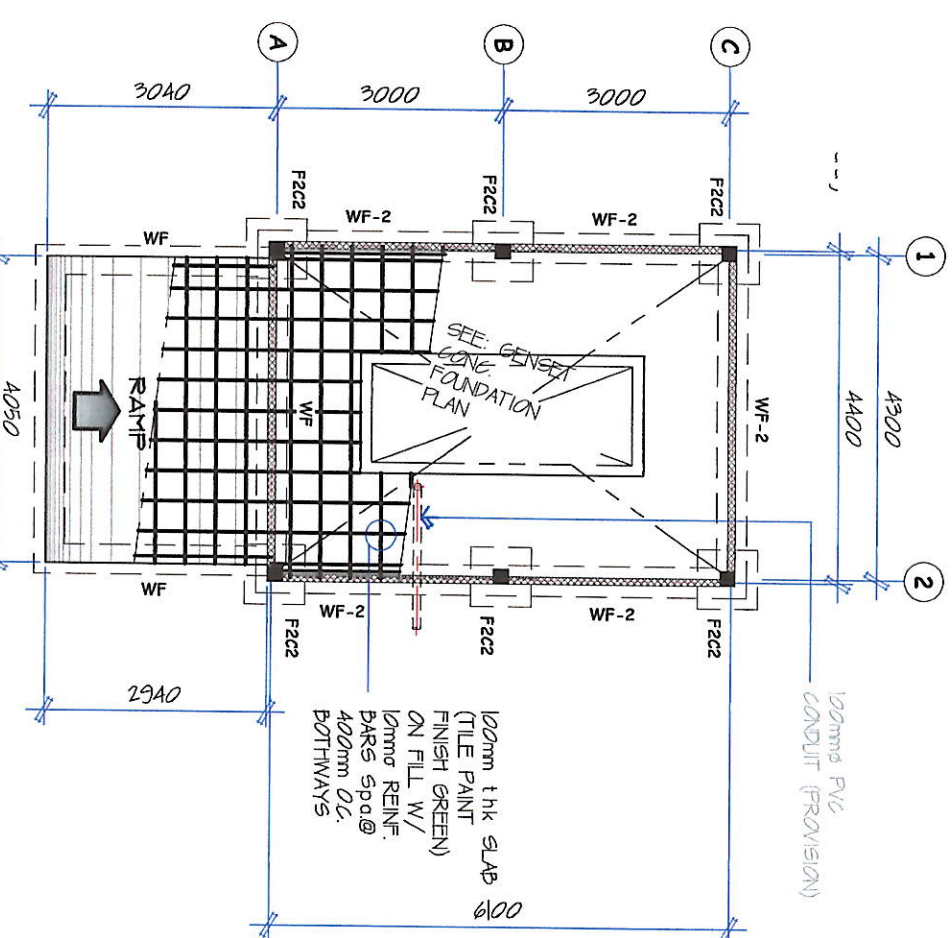 


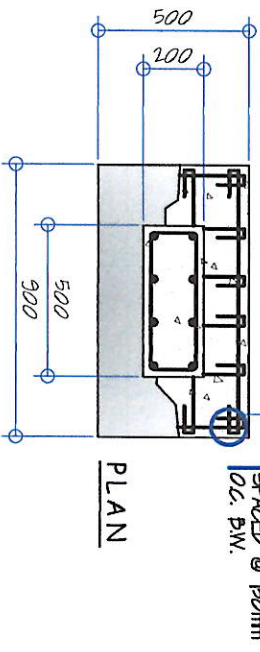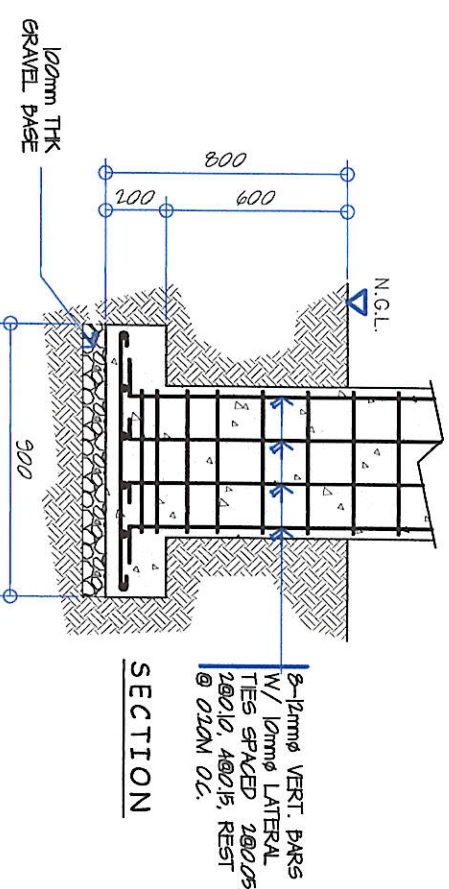



04 CONCRETE PIPE SUPPORT DETAILS
SCALE : 1 : 25 M

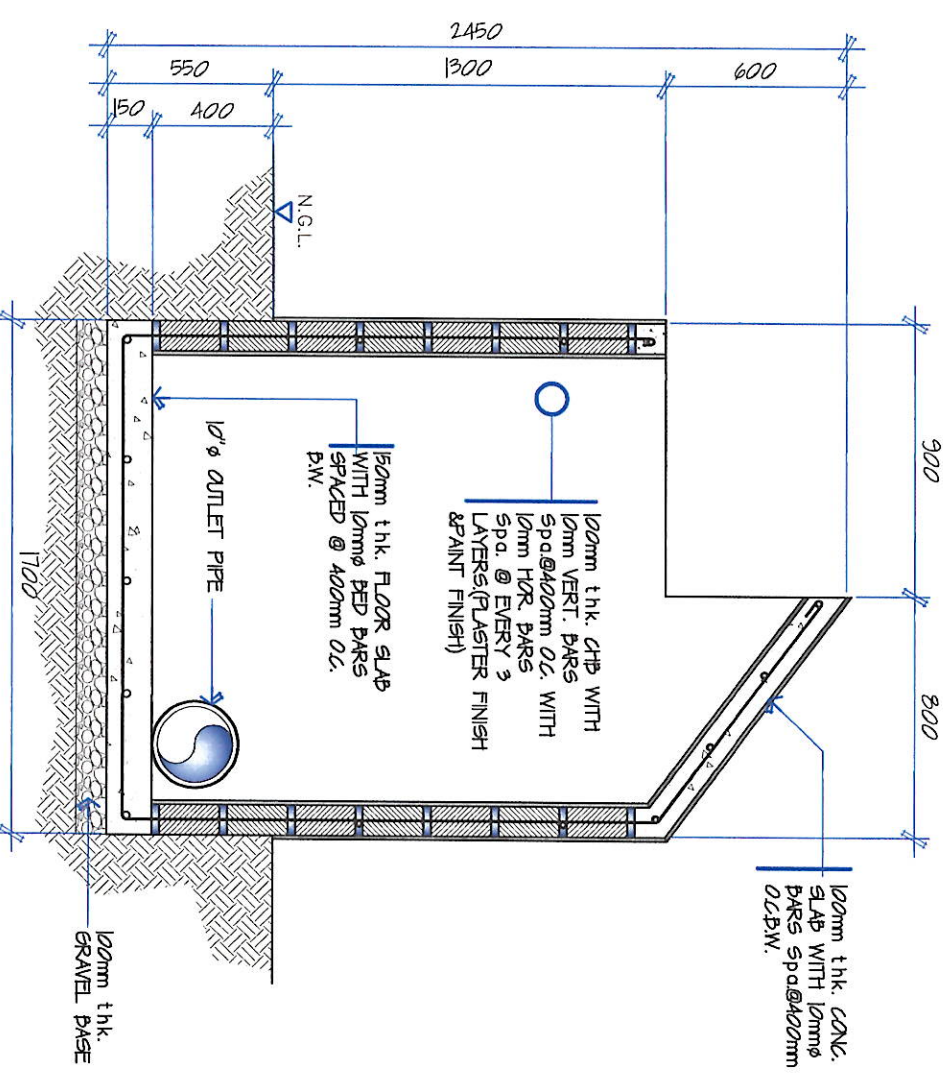


01 LONGITUDINAL SECTION OF TEST LINE BOX
SCALE : 1 : 40 M

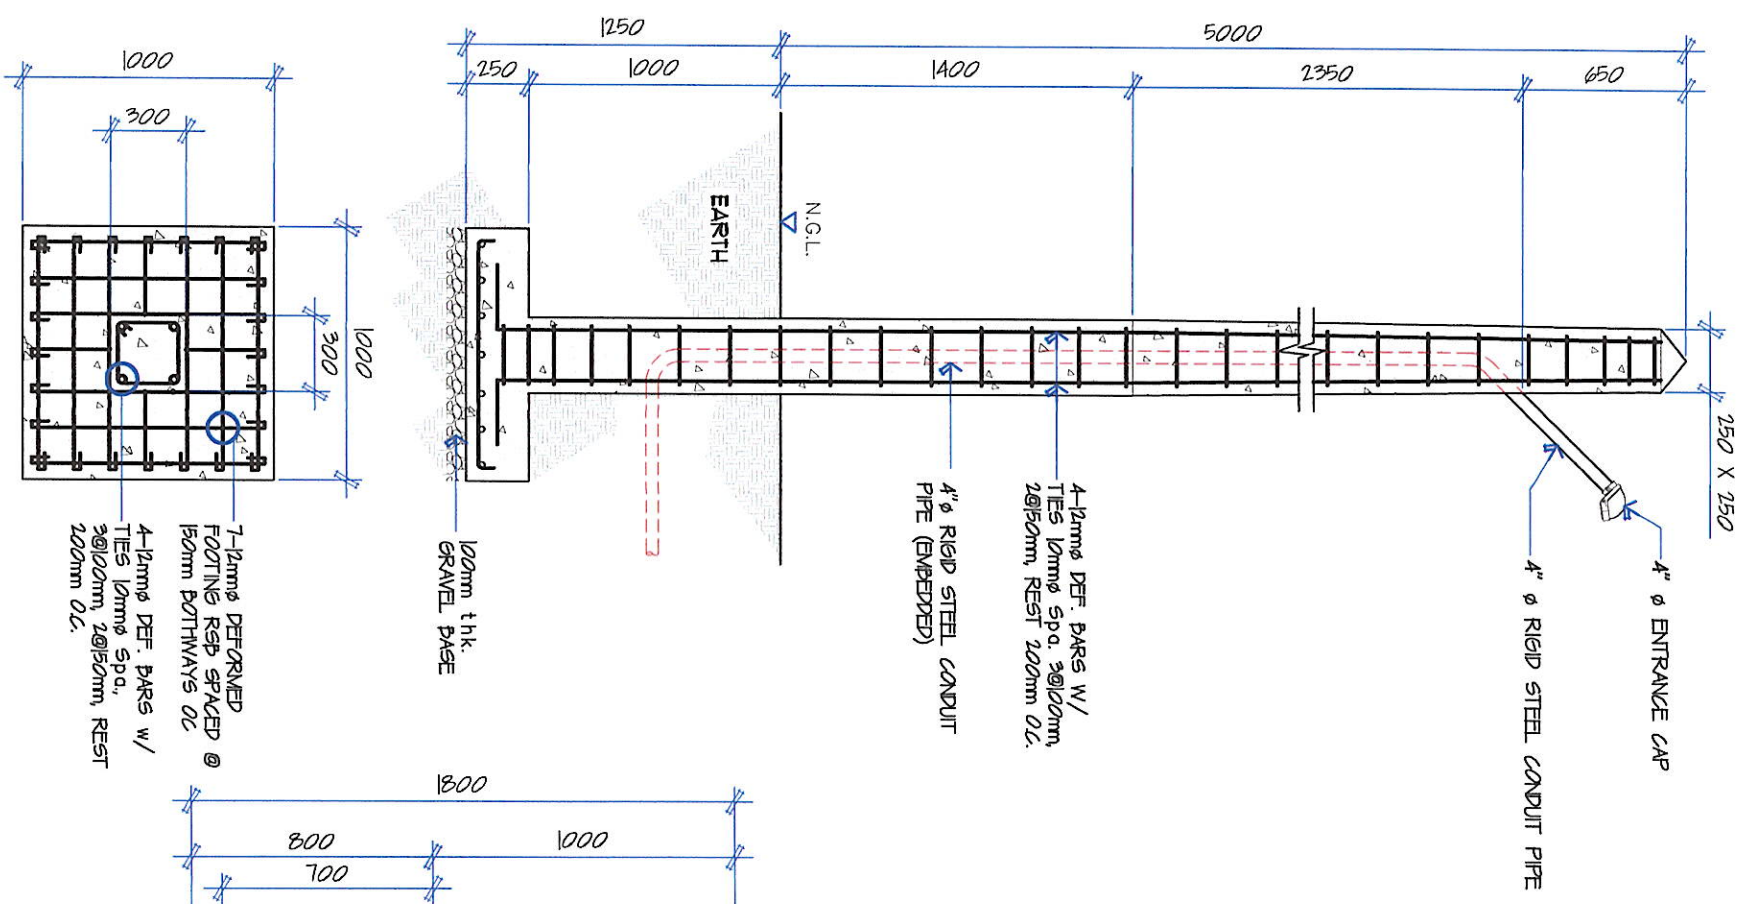

02 ELECTRICAL SERVICE ENTRANCE PEDESTAL DETAIL
SCALE : 1 : 30 M

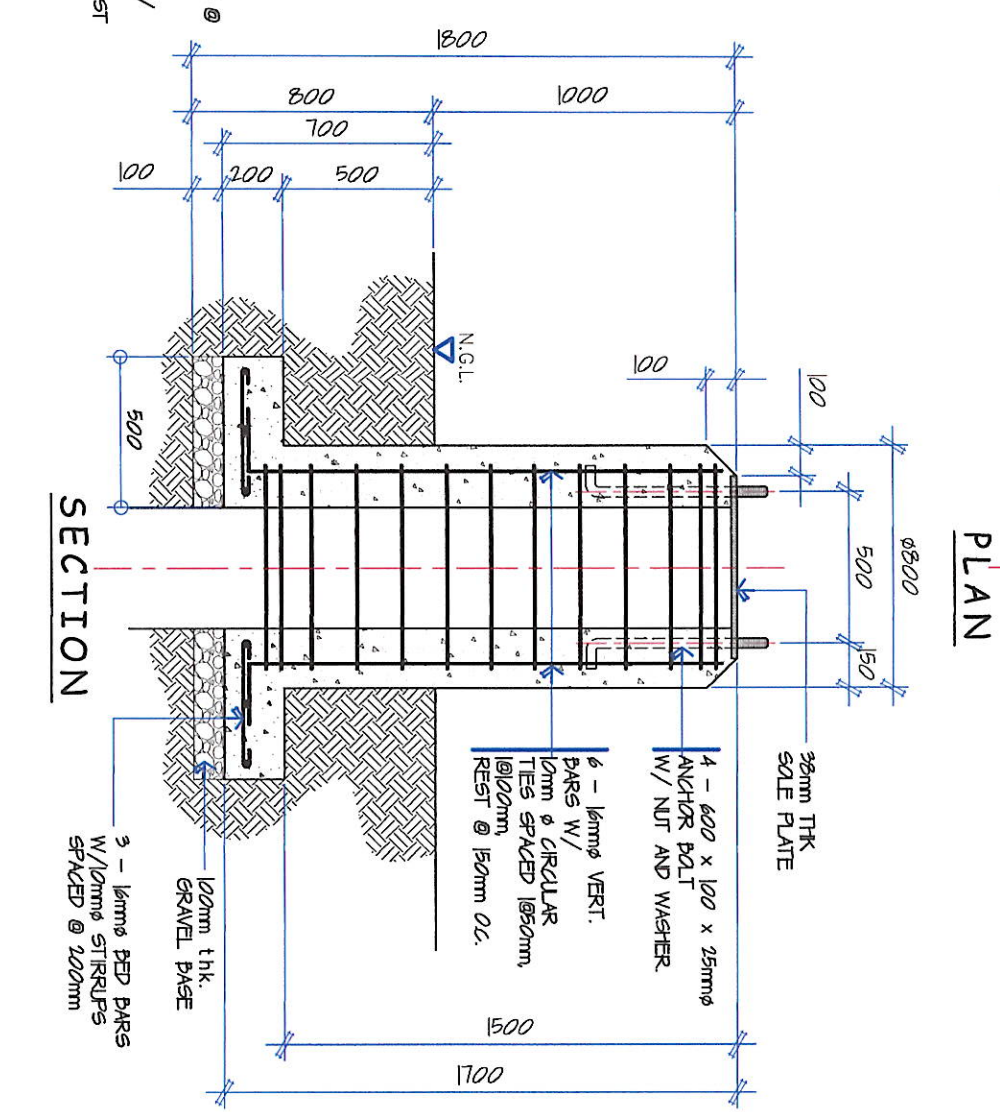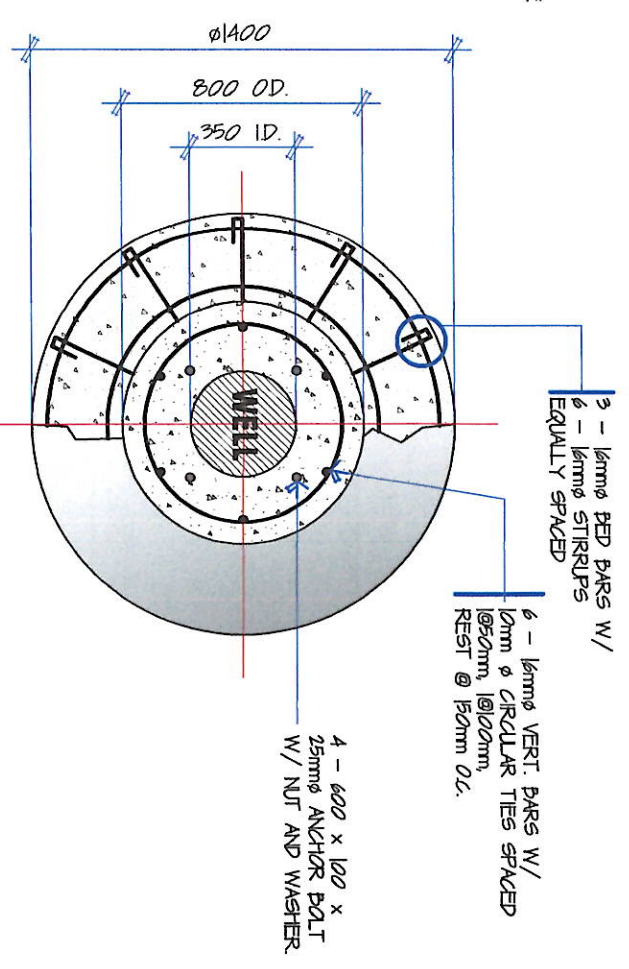

 03 DEEP WELL CONCRETE BASE DETAIL
SCALE : 1 : 25 M

GENERAL SANTOS CITY WATER DISTRICT E. FERNANDEZ STREET, BRGY. LAGAO, GEN. SANTOS CITY ENGINEERING & CONSTRUCTION DEPARTMENT PLANNING AND DESIGN DIVISION TEL. NO.: (083) 552-3824																																																																																																																							
 DANILO M. HORRADOR, JR. CONSULTING ENGINEER REG. NO. 0107545 TIN. NO. 291-941-997 DATE: 01/09/2025										PROJECT AND LOCATION										REVIEWED:										RECOMMEND APPROVAL:										APPROVED:										SHEET CONTENTS										SHEET NO.																																																											
										PROPOSED CONSTRUCTION OF PUMPHOUSE & GENERATOR SHED										 ENGR. MARIA CELIA N. DANDAN DEPARTMENT MANAGER ECD										 ENGR. ROMEO A. BERNAL, JR. AGM, OTS										 FRANCISCO R. ALOD, JR., CPA, CEEB ACTING GENERAL MANAGER										AS SHOWN										S-04																																																											
PR. NO. 1539180A										DATE: 01/09/2025										LOT 965-G-1, BRGY. MABUHAY, GEN. SANTOS CITY																																																		DRAWN BY: 										REV. NO.										DATE: Apr 2025										09										15									

- 1
- 2
- 3

- ## 2. ALTERNATOR

- Generator (PMG)

- 13 1/11 : 25% Load

- (20.68 MPa).

- with 90db.

- values and alarms.

- compatible with either shunt or PMG systems.

- Clear Text Display

- Earth Fault (Option)

- Periodic Maintenance

- $L = 3.30\text{M}$ $W = 1.07\text{m}$ $H = 1.60\text{m}$




02



PR. NO.			
DATE:			
LOT 965-G-1, BRGY. MABUHAY GEN. SANTOS CITY			
DEPARTMENT MANAGER ECD			
AGM, OTS			
ACTING GENERAL MANAGER			
CHECKED BY:			
DATE: <u>APR 24, 2024</u>			

RECOMMENDED SUPPORT SPACING
FOR COPPER TUBING

TUBE O.D. (mm)	DISTANCE BETWEEN SUPPORT (M)
16	1.89
22-29	2.44
35-54	3.05

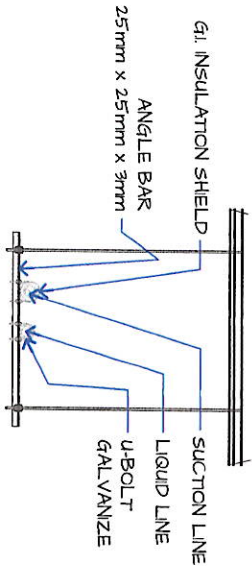

INDOOR


OUTDOOR

02 PIPE HANGER DETAIL


M-03 NOT TO SCALE

03 CONDENSE DRAIN PIPE

M-03 NOT TO SCALE

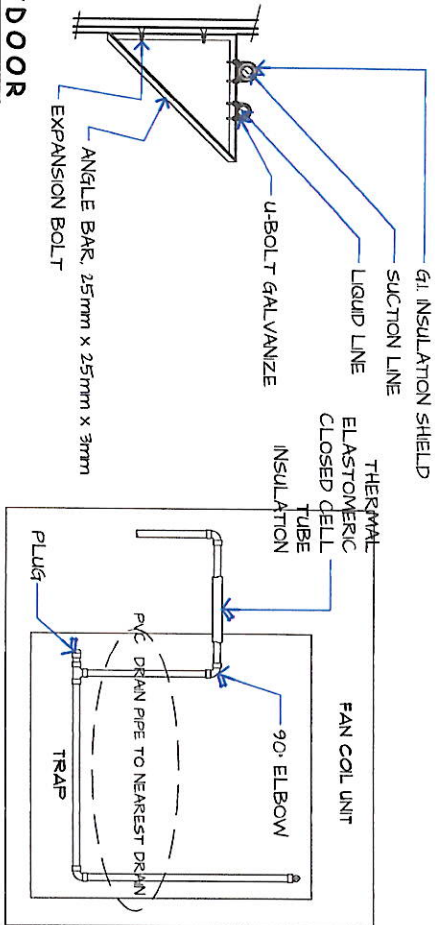


- NOTE:
- ADHESIVE & LATEX PAINT SHOULD BE COMPATIBLE WITH THE INSULATION.
 - LIQUID LINE EXPOSED TO DIRECT SUNLIGHT SHALL BE PROVIDED WITH INSULATION.
 - PROVIDE #24 INSULATION SHIELD AT THE POINT OF SUPPORT.

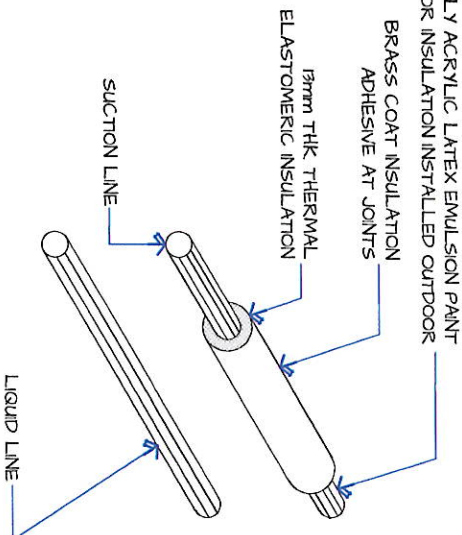


04 PIPE INSULATION DETAIL

M-03 NOT TO SCALE

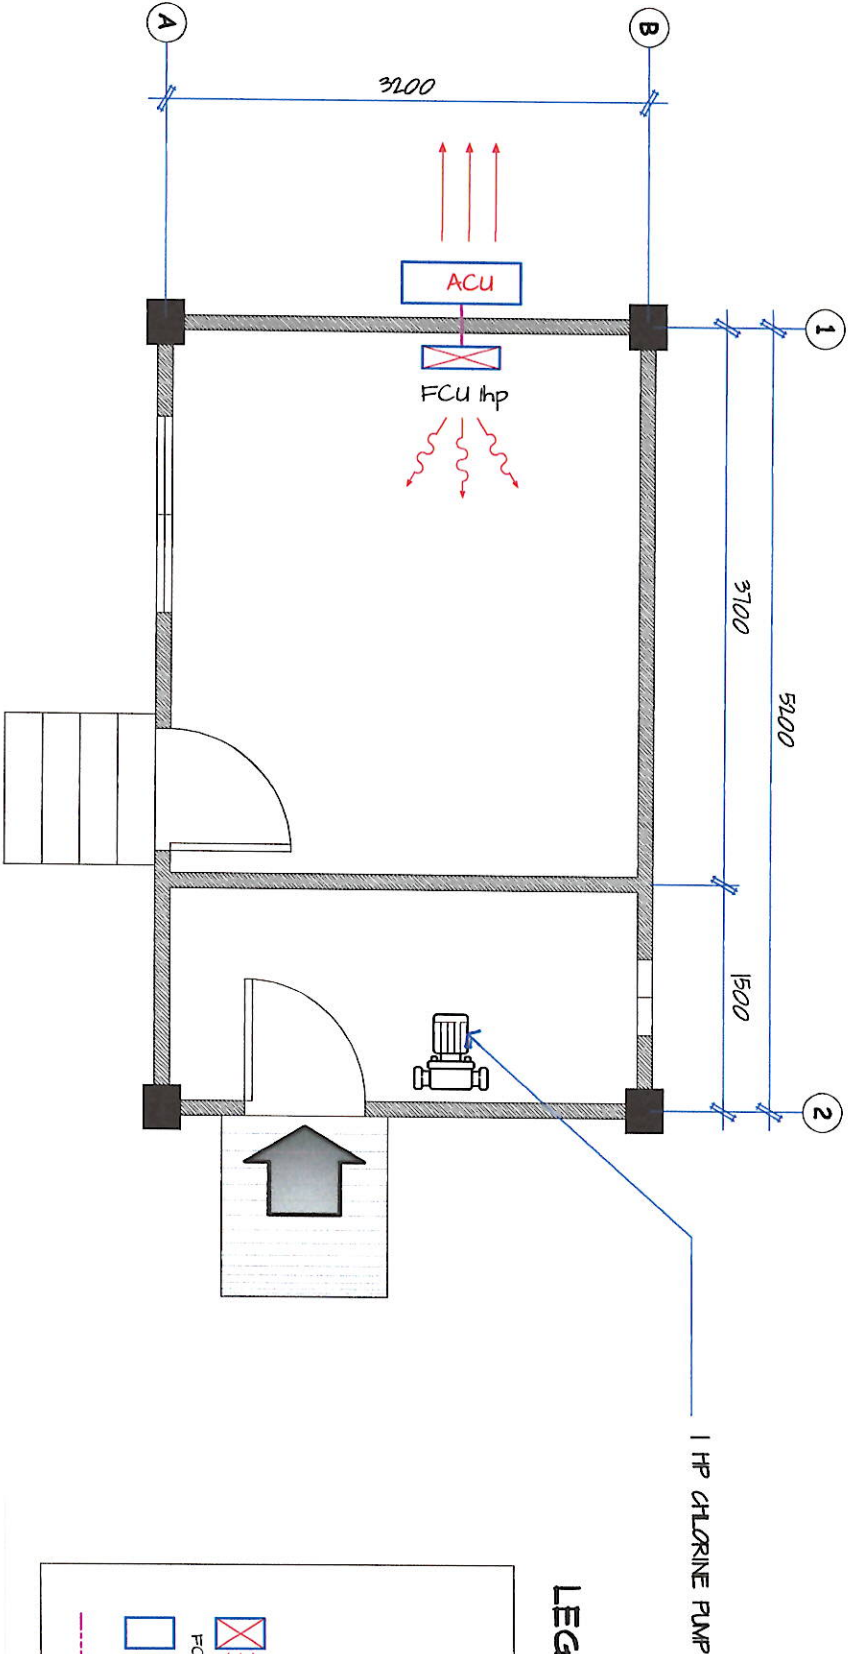

1 HP CHLORINE PUMP

LEGEND & ABBRE.

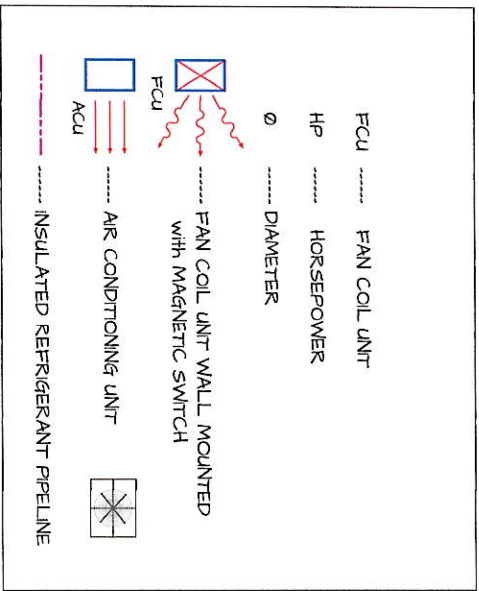


MECHANICAL GENERAL NOTES:

- ALL AIR-CONDITIONING AND VENTILATING UNITS SHALL BE NEW AND THE APPROVED PRODUCTS OF REPUTABLE MANUFACTURERS
- FAN COIL UNITS SHALL BE SUM MODEL MOUNTED AND MUST BE PROVIDED WITH BLUE PVC DRAIN PIPE.
- REFRIGERANT SUCTION LINES SHALL BE INSULATED WITH 13MM THK. ELASTOMERIC PRE-MOLDED RUBBER INSULATION.
- IT SHALL BE THE RESPONSIBILITY OF THE CONTRACTOR TO COORDINATE HIS WORK WITH THE OTHER TRADES CONCERNED AND WITH THE OTHER PROJECT ENGINEER.
- THE WORKS THROUGHOUT SHALL BE EXECUTED IN THE MOST THROUGH MANNER KNOWN TO THE TRADE AND TO THE SATISFACTION OF THE ARCHITECT/ENGINEER.
- PROVIDE PROPER FOUNDATION FOR THE MOUNTING OF EQUIPMENT FOUNDATION FOR THE FCU SHALL BE AT LEAST 100MM FROM FINISHED FLOOR LINE.
- ALL AIR-CONDITIONING UNITS SHALL BE PROVIDED WITH THE AUTOMATIC MOTOR PROTECTOR TO BE INSTALLED BESIDE THE ACCU.
- REFRIGERANT PIPES FOR SPLIT TYPE AIR-CON SHALL BE CLAD WITH A 4"Ø PVC PIPE PRIOR TO BEING EMBEDDED.
- ALL REFRIGERANT PIPES SHALL BE LOCATED AT THE REAR OF THE FCU'S AND NOT ON THE USUAL SIDE LOCATION.
- HANGER/SUPPORT MUST BE PAINTED WITH DOUBLE COAT OF RUST PROTECTIVE PAINT.
- VERIFY ALL DIMENSIONAL LOCATION OF EQUIPMENT ON THE DRAWINGS OF RELATED TRADES AND INVESTIGATE ALL POSSIBLE INTERFERENCE AND CONDITION AFFECTING THE MECHANICAL WORK.
- UPON THE COMPLETION OF THE A/C EQUIPMENT INSTALLATION, TEST ALL FACTORY AND FIELD INSTALLED REFRIGERANT PIPING WITH A LEAK DETECTOR TO ACQUIRE A LEAK-TIGHT CORRECT AND RE-TEST THE SYSTEM FOLLOWING THE MANUFACTURER'S RECOMMENDATIONS.
- THE CONTRACTOR SHALL SUBMIT MANUFACTURER'S WARRANTY CERTIFICATE UPON THE COMPLETION OF THE PROJECT.

01 MECHANICAL EQUIPMENT LOCATION PLAN

 M-03 SCALE : 1 : 50 M

GENERAL SANTOS CITY WATER DISTRICT E. FERNANDEZ STREET, BRGY. LAGAO, GEN. SANTOS CITY ENGINEERING & CONSTRUCTION DEPARTMENT PLANNING AND DESIGN DIVISION TEL. NO. : (083) 532 - 3824													
PROFESSIONAL MECHANICAL ENGINEER		PROJECT AND LOCATION		REVIEWED:		RECOMMEND APPROVAL:		APPROVED:		SHEET CONTENTS		SHEET NO.	
		PROPOSED CONSTRUCTION OF PUMPHOUSE & GENSET SHED		 ENGR. MARIA CELIA N. DANDAN DEPARTMENT MANAGER, ECD		 ENGR. ROGELIO A. BESANA, JR. AGM, OTS		 FRANCISCO P. ALOD, JR., CPA, CEBE ACTING GENERAL MANAGER		AS SHOWN		M-03	
REG. NO.		TIN. NO.		DRAWN BY: 		REV. NO.							
DATE:				CHECKED BY:		DATE: Apr 2025						12	
PTR. NO.		LOT 965-G-1, BRGY. MABUHAY, GEN. SANTOS CITY										15	

PLUMBING NOTES:

1. GRADES OF HORIZONTAL PIPING RUN ALL HORIZONTAL PIPINGS IN PERFECT ALIGNMENT AND AT A FORM GRADE OF NOT LESS THAN TWO PERCENT (2%)
2. CHANGE IN DIRECTION
ALL CHANGE IN DIRECTION SHALL BE MADE BY APPROPRIATE USE OF FORTY FIVE DEGREES (45°) WYES LONG SWEEP QUARTER BEND, SIX-EIGHT OR SIXTEENTH BENDS. WHEN THE CHANGE OF FLOW IS FROM HORIZONTAL TO VERTICAL, 1/8 BEND COMBINATION MAYBE USED ON VERTICAL STACKS AND SHORT QUARTER BENDS MAYBE USED ON WASTE LINE, TEE AND CROSSES MAYBE USED IN VENT PIPES
3. PROHIBITED FITTINGS
NO DOUBLE HUB OR TEE BRANCH SHALL BE USED ON HORIZONTAL WASTE LINES. THE DRILLINGS AND TAPPINGS OF HUBS DRAIN, WASTE OR VENT PIPES AND USE OF SADDLE HUB AND BEND ARE PROHIBITED
4. SLEEVES
PROVIDE PIPE SLEEVES AT WALLS, COLUMNS OR SLABS ONE SIZE BIGGER THAN THE ACTUAL SIZE PASSING THROUGH THE WALLS, COLUMNS OR UNDER SLAB TO PROTECT PIPE FROM LEAKAGE
5. PIPE CLEAN-OUTS
PIPE CLEAN-OUTS ARE REQUIRED UNDER THE FOLLOWING CONDITIONS:
 - a. EVERY CHANGE IN HORIZONTAL DIRECTIONS EXCEEDING TWENTY-TWO AND ONE-HALF DEGREES (22 1/2°)
 - b. ONE AND ONE-HALF METERS (5.0 m) INSIDE THE PROPERTY LINE BEFORE THE HOUSE DRAINAGE CONNECTION.
 - c. EVERY FIFTEEN METERS (50.0 m) IN HORIZONTAL RUN OF PIPES.
 - d. AT THE END OF ANY HORIZONTAL PIPE LINES.
6. ALL PLUMBING WORKS SHALL BE DONE BY A LICENSED MASTER PLUMBER AND A LICENSED PLUMBING CONTRACTOR.

SPECIFICATIONS:

ALL PLUMBING WORKS AND INSTALLATION SHALL CONFORM WITH THE LATEST EDITION OF NATIONAL PLUMBING CODE RULES AND REGULATION OF THE ENFORCING AUTHORITY CONCERNED AND CITY

ALL HORIZONTAL PIPINGS SHALL RUN IN PRACTICAL ALIGNMENT AND SHALL BE PROVIDED WITH SLOPE OF NOT LESS THAN 1% SLOPE AND SUPPORTED OF ANCHORED EVERY 300m INTERVALS


ALL MATERIALS SHALL BE NEW AND APPROVED TYPES:

2" Ø PVC PIPES FOR VENTS AND FIXTURES
4" Ø PVC PIPES FOR WC, FD, CO.

b. FOR WATER LINES:

1" Ø G.I. PIPE FOR FIXTURES
2" Ø G.I. PIPE FOR BRANCHES
1" Ø G.I. PIPE FOR MAINLINE SUPPLY

ALL PUMPING WORKS AND INSTALLATION SHALL BE STRICTLY SUPERVISED BY A FULLY REGISTERED MASTER PLUMBER

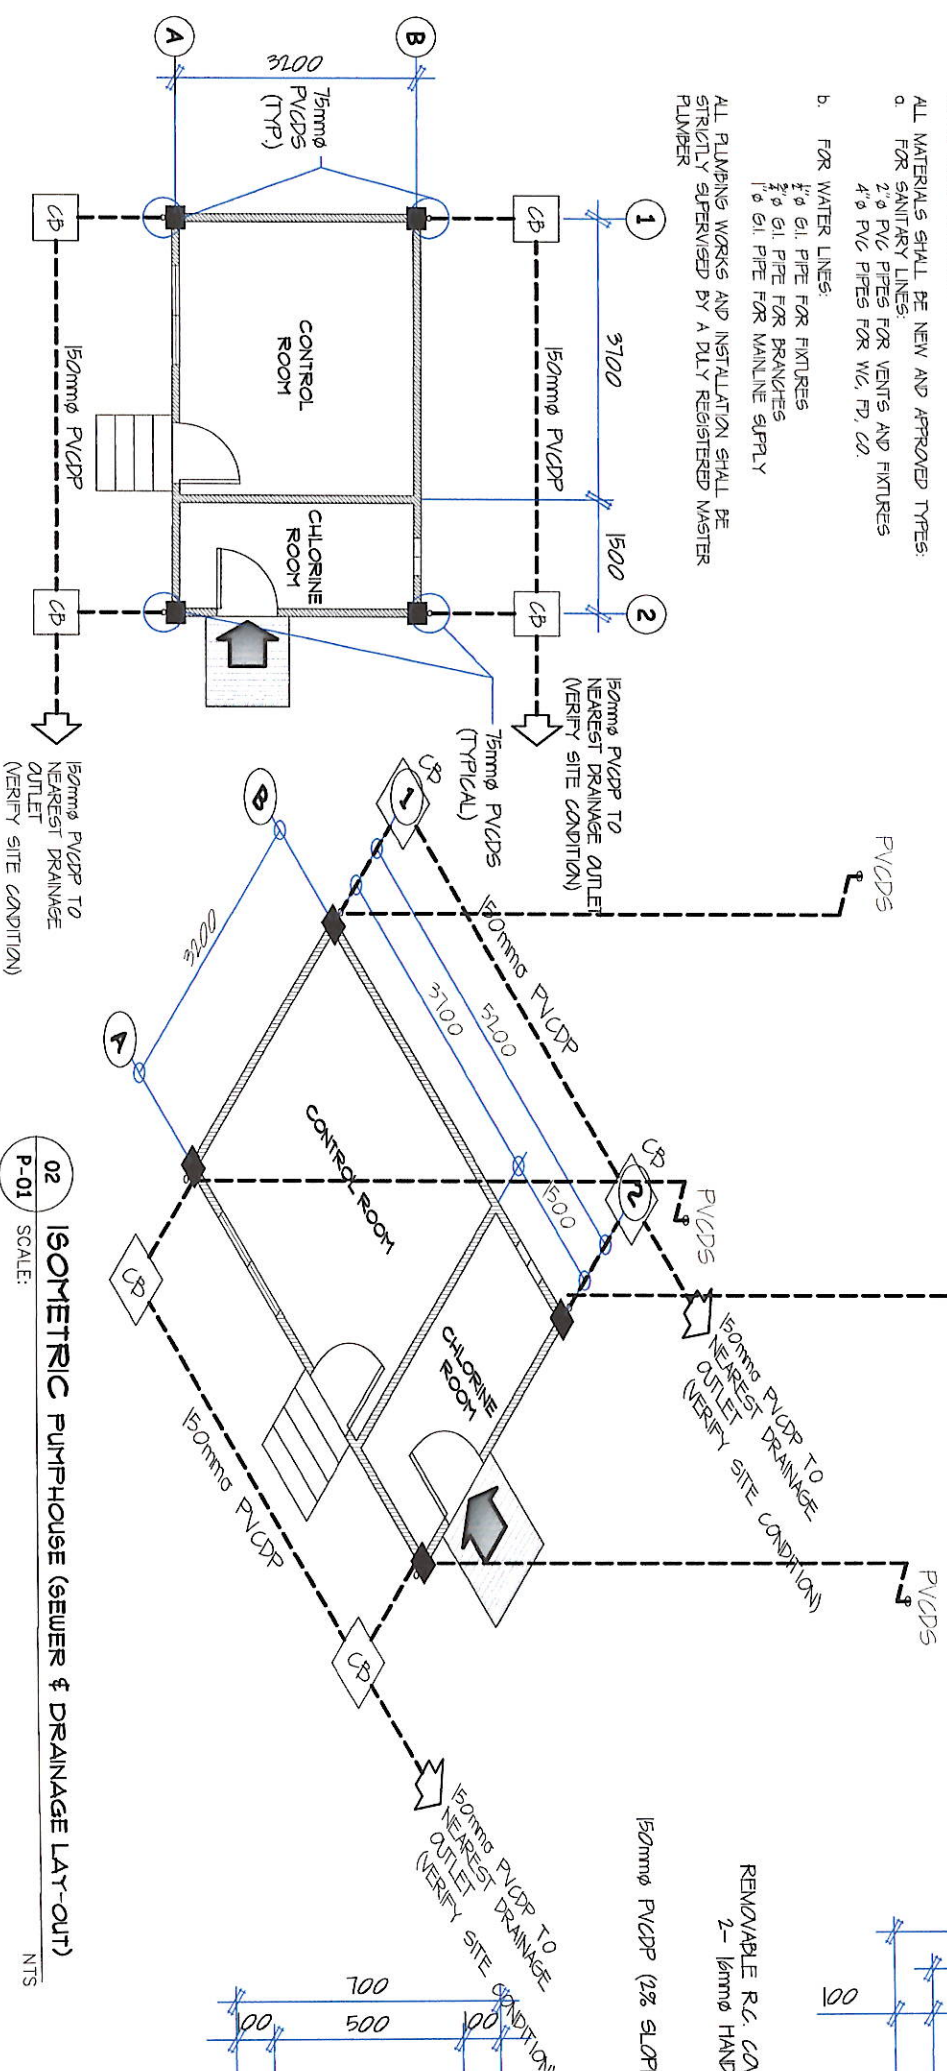

01 FLOOR PLAN PUMPHOUSE (SEWER & DRAINAGE LAY-OUT)

P-01	SCALE: 1 : 100 M
------	------------------

ISOMETRIC PUMPHOUSE (SEWER & DRAINAGE LAY-OUT)


P-01 SCALE:

NTS


REMOVABLE R.C. COVER DETAIL

P-01 SCALE:


1:10 m

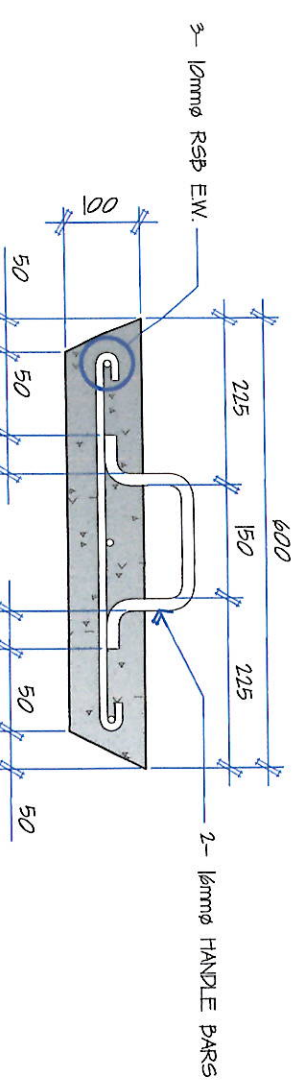

SECTION

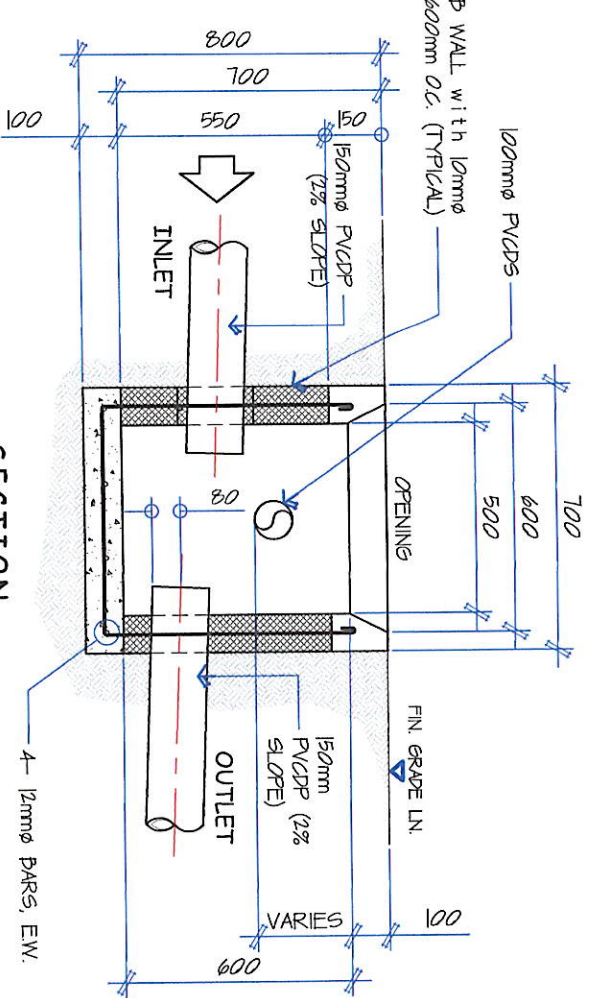

PLAN

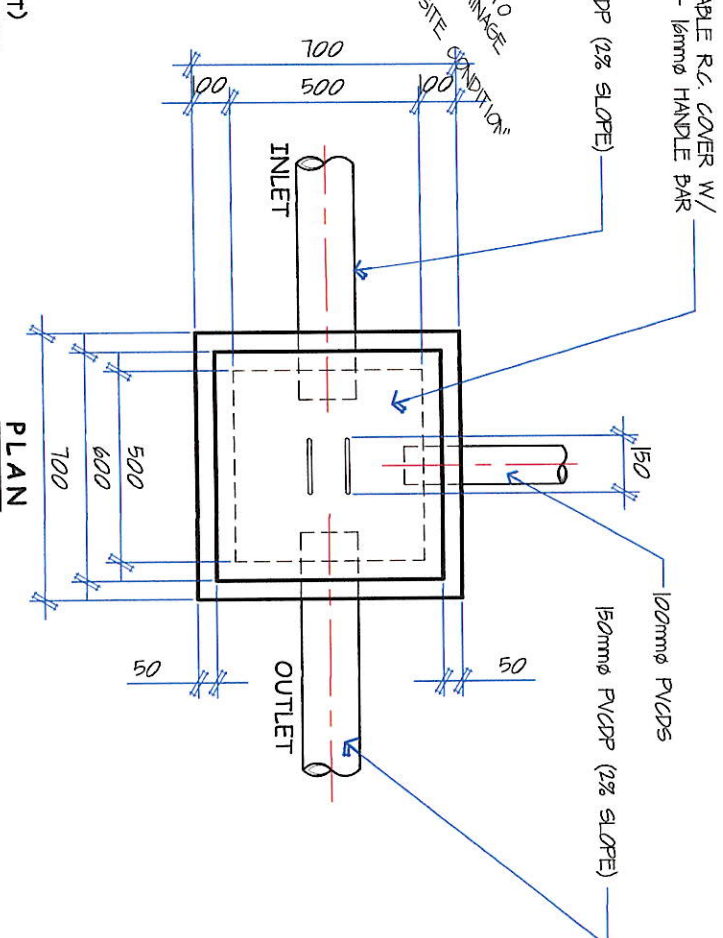

DETAIL OF CATCH BASIN (PUMPHOUSE)

P-01 SCALE:

1 : 20 M

 GENERAL SANTOS CITY WATER DISTRICT E. FERNANDEZ STREET, BRGY. LAGAO, GEN. SANTOS CITY ENGINEERING & CONSTRUCTION DEPARTMENT PLANNING AND DESIGN DIVISION TEL. NO. (083) 552 - 3824			
ENGR. MIGUEL M. DINAPO, JR. REGISTERED MASTER PLUMBER			
REG. NO. 0015212	TIN. NO. 927-963867		
PRJ. NO. 1539181A	DATE: 01/09/2025		
PROPOSED CONSTRUCTION OF PUMPHOUSE & GENSET SHED		PROJECT AND LOCATION	
ENGR. MARIA CELIA N. DANDAN DEPARTMENT MANAGER ECD		REVIEWED: 	
ENGR. ROGELIO A. BESANA, JR. AGM, OTS		RECOMMEND APPROVAL: 	
FRANCISCO BALOTOD, JR., CPA, CESE ACTING GENERAL MANAGER		APPROVED: 	
AS SHOWN		SHEET CONTENTS	
DRAWN BY: 			
REV. NO.	DATE: Apr 2025		
13	15	P-01	

SCHEDULE OF LOADS:

PANEL: LP		VOLTAGE: 220						
FEED: TOP SURFACE		PHASE: 1 2						
MOUNTING:		WIRE:						
CIRCUIT NO.	PARTICULARS	NO. OF OUTLET	WATTS	PHASE	VOLTS	AMPERE	CB RATING	WIRE SIZE AND CONDUIT
1	Lighting Outlet, LED Lamp	7	700	1	230	3.04	15 AT	2-3.5mm ² THWN, 1-2.0mm ² TW(GND), IN 15mmø CONDUIT
2	Lighting Outlet, LED Lamp	4	400	1	230	1.74	15 AT	2-3.5mm ² THWN, 1-2.0mm ² TW(GND), IN 15mmø CONDUIT
3	Convenience Outlet	2	1000	1	230	4.35	20 AT	2-5.5mm ² THWN, 1-2.0mm ² TW(GND), IN 15mmø CONDUIT
4	ACU, 1 hp Split Type(Magnetic Switch w/ Built-in 3-Prong Outlet	1	1340	1	230	5.80	20 AT	2-5.5mm ² THWN, 1-2.0mm ² TW(GND), IN 15mmø CONDUIT
5	1 HP Chlorinator pump	1	1340	1	230	5.80	30 AT	2-5.5mm ² THWN, 1-2.0mm ² TW(GND), IN 15mmø CONDUIT
6	S P A R E	1	2000	1	230	8.70	15 AT	2-3.5mm ² THWN, 1-2.0mm ² TW(GND), IN 15mmø CONDUIT
TOTAL			7,780					

COMPUTATION: @ 80 % Demand Factor
Demand load = 7,780 / 230 x 0.8DF = 27.06 A
COMPUTATION FOR MINIMUM STEP DOWN TRANSFORMER 460V/230V:
USED : 10 KVA, 460V PRI./230V SECONDARY DRY TYPE STEP DOWN
= 27.06 x 1.25 = 33.83 AMPS

PANEL: MOP	VOLTAGE: 460
FEED: TOP SURFACE	PHASE: 3
MOUNTING:	WIRE: 3

FEEDER TRANSFORMER 460V/230V
20mm^ø CONDUIT
MAIN : 50AT, 100AF, 2P, 230V

CKT NO.	PARTICULARS	NO. OF OUTLET	WATTS	PHASE	VOLTS	AB	BC	CA	3Ø	CB RATING	WIRE SIZE AND CONDUIT
1	125 HP Submersible Motor	1	106,000	3	460					250 AT	3-100mm ² THWN, IN 1-22mm ² TW(GND) IN 100mm ^ø CONDUIT
2	LP 10 KVA Dry Type Xmer	1	7,780	1	460			16.91		40 AT	2-5.5mm ² THWN, IN 1-2.0mm ² TW(GND) IN 15mm ^ø CONDUIT
TOTAL			113,780					16.91			

COMPUTATION :


I = $\frac{125 \times 113,780}{173 \times 460 \times 0.80}$
I = 223.4 AMPS
KVA = $(113,780)(125)/0.80$
= $\frac{177,125}{1000}$
= 177.125
USE : 3 - 75 KVA, 13.2KV/460V TRANSFORMER BANK
POLE MOUNTED TRANSFORMER

GENERAL NOTES:

- ALL ELECTRICAL WORKS SHALL BE DONE IN ACCORDANCE WITH THE PROVISION OF THE LATEST EDITION OF THE PHILIPPINE ELECTRICAL CODE, EXISTING APPLICABLE ORDINANCES, RULES AND REGULATIONS OF THE LOCAL GOVERNMENT AND WITH THE REQUIREMENTS OF THE LOCAL POWER COMPANY.
- THE TYPE OF SERVICE POWER SUPPLY TO BE USED SHALL BE SINGLE-PHASE, 2-WIRE, 230V, 60 HERTZ, A.C
- THE CONTRACTOR SHALL VERIFY AND ORIENT THE ACTUAL LOCATION OF SERVICE ENTRANCE FOR CONNECTION TO THE POWER COMPANY SERVICE POINT.
- UNLESS OTHERWISE SPECIFIED, THE MINIMUM SIZES OF WIRE AND ELECTRICAL PVC PIPE TO BE USED SHALL BE 3.5mm² THHN AND 15mm NOMINAL DIAMETER, RESPECTIVELY. LIKEWISE ALL ELECTRICAL WIRES SHALL BE COLOR-CODED.
- ALL LIGHTING CIRCUIT HOME RUNS AND CONVENIENCE OUTLETS SHALL BE WIRED WITH NOT LESS THAN 3.5 mm² IN SIZE.
- WHEREVER REQUIRED AND NECESSARY, PULL OR JUNCTION BOXES SHALL BE INSTALLED AT CONVENIENT AND INCONSPICUOUS LOCATION, ALTHOUGH SUCH BOXES ARE NOT SHOWN ON THE PLAN NOR MENTIONED IN THE SPECIFICATIONS.
- ALL NON-CURRENT CARRYING METAL PARTS OF ELECTRICAL EQUIPMENT SHALL BE PROPERLY GROUNDED IN ACCORDANCE WITH THE PROVISIONS OF THE LATEST EDITION OF THE PHILIPPINE ELECTRICAL CODE.
- ALL MATERIALS TO BE USED SHALL BE BRAND NEW AND OF THE APPROVED TYPE FOR LOCATION AND PURPOSE.
- ALL WALL OUTLETS SHALL BE INSTALLED AT THE FOLLOWING HEIGHTS ABOVE THE FINISHED FLOOR LEVEL, UNLESS NOTED IN THE PLAN.
a. WALL SWITCHES @ 1300mm
b. ALL CONVENIENCE OUTLETS @ 300 mm
- ALL ELECTRICAL WORKS SHALL BE DONE UNDER THE DIRECT AND IMMEDIATE SUPERVISION OF A DULY REGISTERED ELECTRICAL ENGINEER.


MOUNTING HEIGHTS:

CONVENIENCE OUTLETS : 300mm FROM BOTTOM OF OUTLET TO FINISH FLOOR LEVEL.
WALL SWITCHES : 1,370mm FROM BOTTOM OF SWITCH TO FINISH FLOOR LEVEL.
PANEL BOARD : 1,830mm TOP OF PANEL TO FINISH FLOOR LEVEL.
KILOWATT HOUR METER : 1,830mm FROM CENTER OF DEVICES TO FINISH GRADE LEVEL.

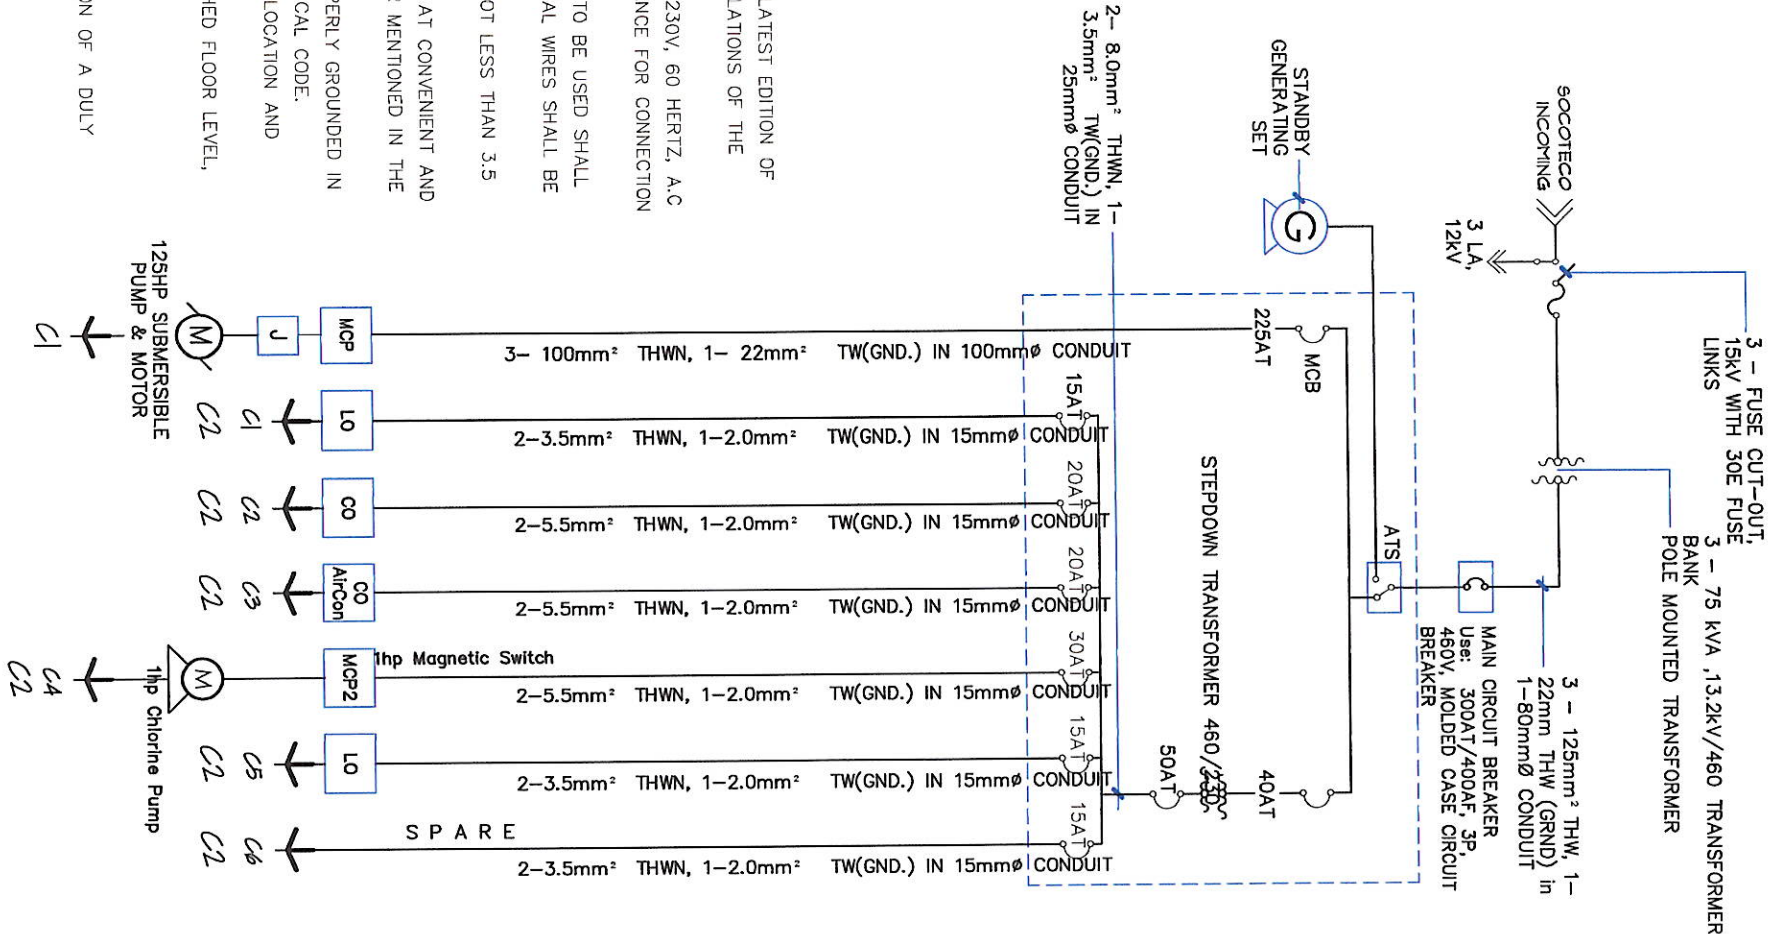

POWER SYSTEM SINGLE LINE DIAGRAM

 01
E-02
NOT TO SCALE

 GENERAL SANTOS CITY WATER DISTRICT E. FERNANDEZ STREET, BRGY. LAGAO, GEN. SANTOS CITY ENGINEERING & CONSTRUCTION DEPARTMENT PLANNING AND DESIGN DIVISION TEL. NO.: (083) 952 - 3824		PROFESSIONAL ELECTRICAL ENGINEER REG. NO. _____ TIN NO. _____ DATE: _____		PROJECT AND LOCATION PROPOSED CONSTRUCTION OF PUMPHOUSE & GENSET SHED		REVIEWED:  ENGR. MARIA CELIA N. DANDAN DEPARTMENT MANAGER, ECD		RECOMMEND APPROVAL:  ENGR. ROGELIO A. BERNAL, JR. AGM, OTS		APPROVED:  FRANCISCO A. ALOD, JR., CPA, CESE ACTING GENERAL MANAGER		SHEET CONTENTS AS SHOWN		SHEET NO. E-02	
PDR NO. _____		DATE: _____		LOT 965-G-1, BRGY. MABUHAY, GEN. SANTOS CITY						DRAWN BY:  CHECKED BY: _____ DATE: Apr 2025		REV. NO. _____		15 15	