


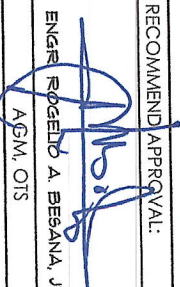
 
 
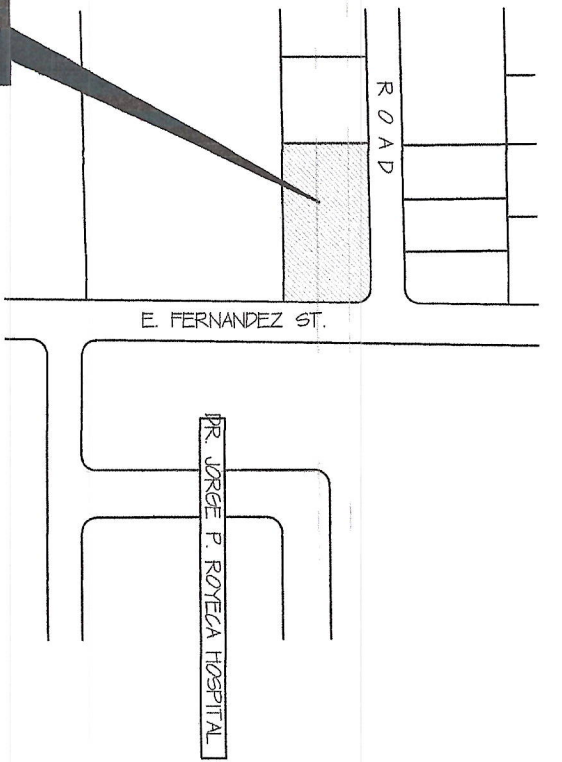




01
B-01

PERSPECTIVE VIEWS

 GENERAL SANTOS CITY WATER DISTRICT E. FERNANDEZ STREET, BRGY. LAGAO, GEN. SANTOS CITY ENGINEERING & CONSTRUCTION DEPARTMENT PLANNING AND DESIGN DIVISION TEL. NO. : (083) 532 - 3824	 DANILO B. MORLADOR, JR. CIVIL ENGINEER	PROJECT AND LOCATION RENOVATION OF OLD METER ROOM FOR FINANCE OFFICE	REVIEWED:  ENGR. MARIA CELLA N. DANDAN DEPT. MANAGER, ECD	RECOMMEND APPROVAL:  ENGR. ROGELIO A. BESANA, JR. AGM, OTS	APPROVED:  FRANCISCO R. ALOLOD, JR., CPA, CESE ACTING GENERAL MANAGER	SHEET CONTENTS AS SHOWN	SHEET NO. B-01
REG. NO. 0107345 TIN. NO. 291-941-997 DATE:	LOCATION : E. FERNANDEZ ST. LAGAO, GSC	DRAWN BY:  CHECKED BY:	REV. NO. 01	DATE: May 2024	REV. NO. 05		



THIS
SITE

03 LOCATION PLAN
B-02 NOT TO SCALE



THIS
SITE

01 VICINITY MAP
B-02 NOT TO SCALE



GENERAL SANTOS CITY WATER DISTRICT
E. FERNANDEZ STREET, BRGY. LAGA, GEN. SANTOS CITY
ENGINEERING & CONSTRUCTION DEPARTMENT
PLANNING AND DESIGN DIVISION
TEL. NO. (083) 552-3824

DANILO M. ORLADOR, JR.
CIVIL ENGINEER
REG. NO. 0107545
TIN. NO. 291-941-997
DATE:

PROJECT AND LOCATION
RENOVATION OF OLD METER ROOM FOR FINANCE OFFICE
LOCATION: E. FERNANDEZ ST., LAGA, GSC

REVIEWED:
ENGR. MARIA CELIA N. DANDAN
DEPT. MANAGER, ECD

RECOMMEND APPROVAL:
ENGR. ROGELIO A. BESANA, JR.
AGM, OTS

APPROVED:
FRANCISCO R. ALMODO, JR., CPA, CESE
ACTING GENERAL MANAGER

SHEET CONTENTS
AS SHOWN
DRAWN BY: [Signature]
REV. NO.
DATE: May 2024

SHEET NO.
B-02
05

02 SITE DEVELOPMENT PLAN
B-02 SCALE: 1 : 300 M



THIS
SITE

LOT 1334-D-6, PSD II-010021 (ROAD)

E. FERNANDEZ ST.

SCHEDULE OF FINISH





FLOORS :

(F1) 600mm x 600mm UNGLAZED CERAMIC FLOOR TILES

WALLS :

(WF1) EXISTING CHB WALL, PLAIN CEMENT PLASTER (PAINT FINISH)

(WF2) 45mm thk. FIBER CEMENT BOARD (PAINT FINISH) W/ 32mm x 12mm x 0.8mm thk. VERT. & HOR. METAL STUDS Spac@ 600mm O.C.

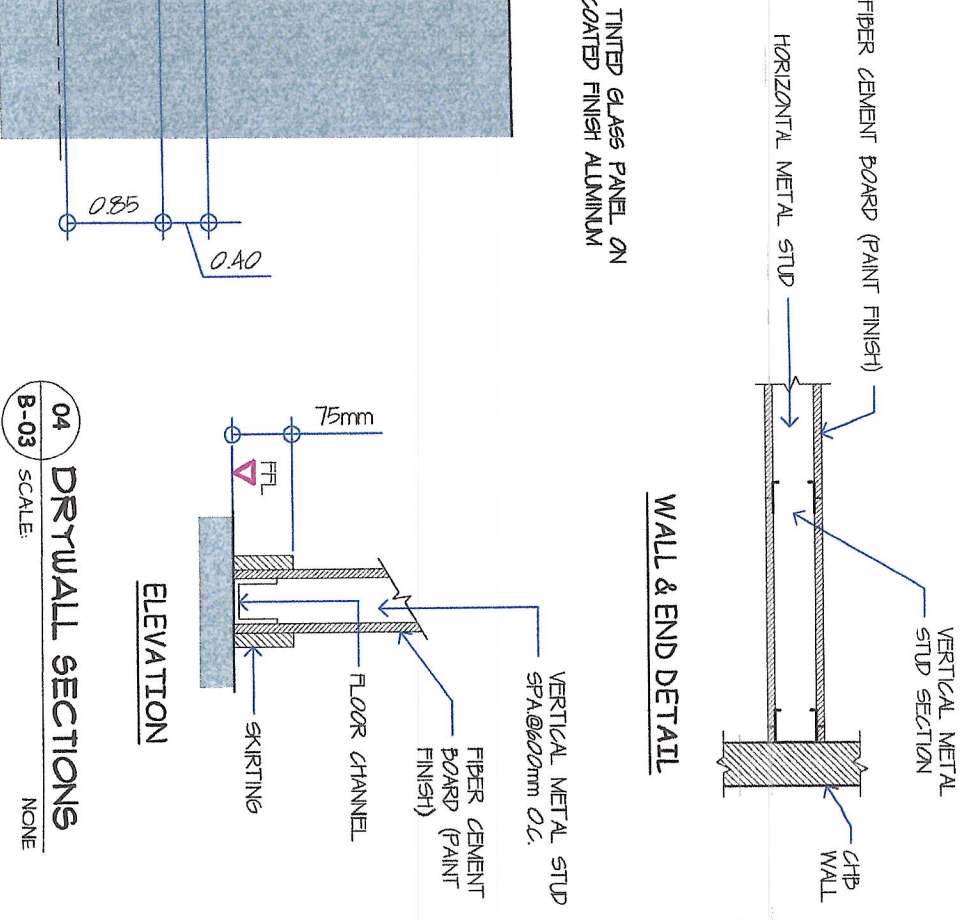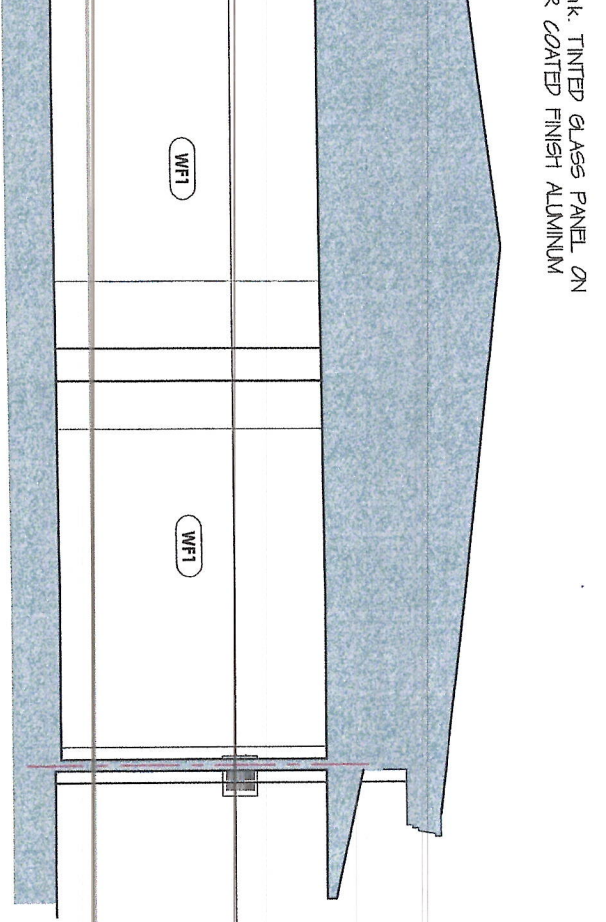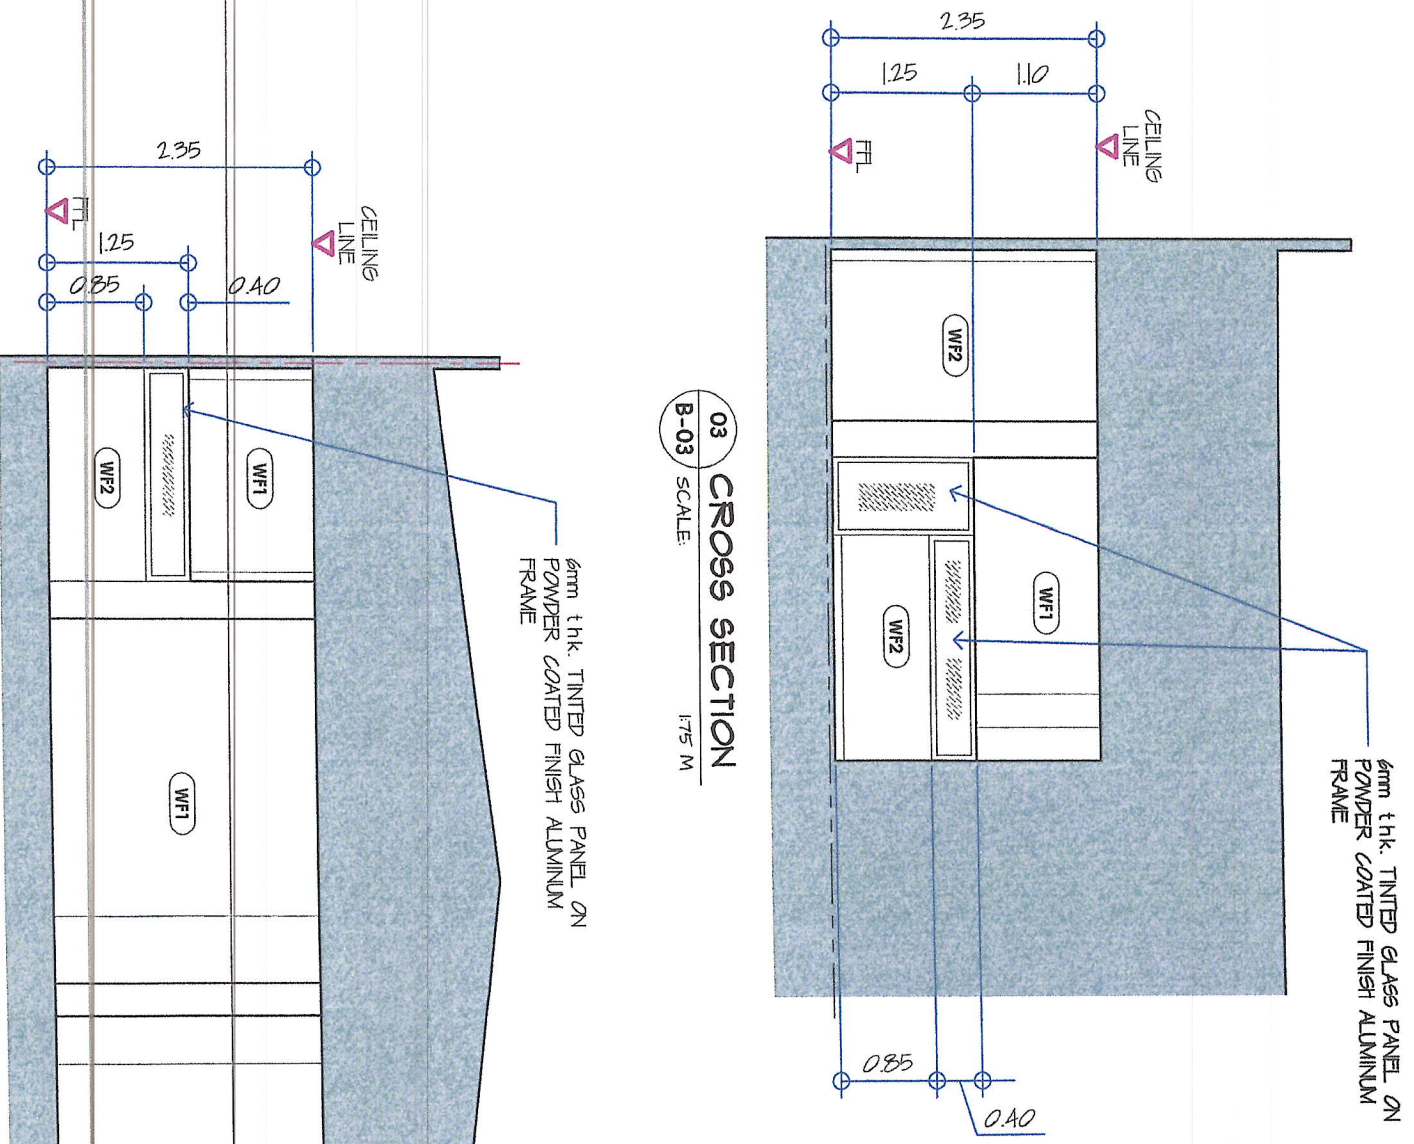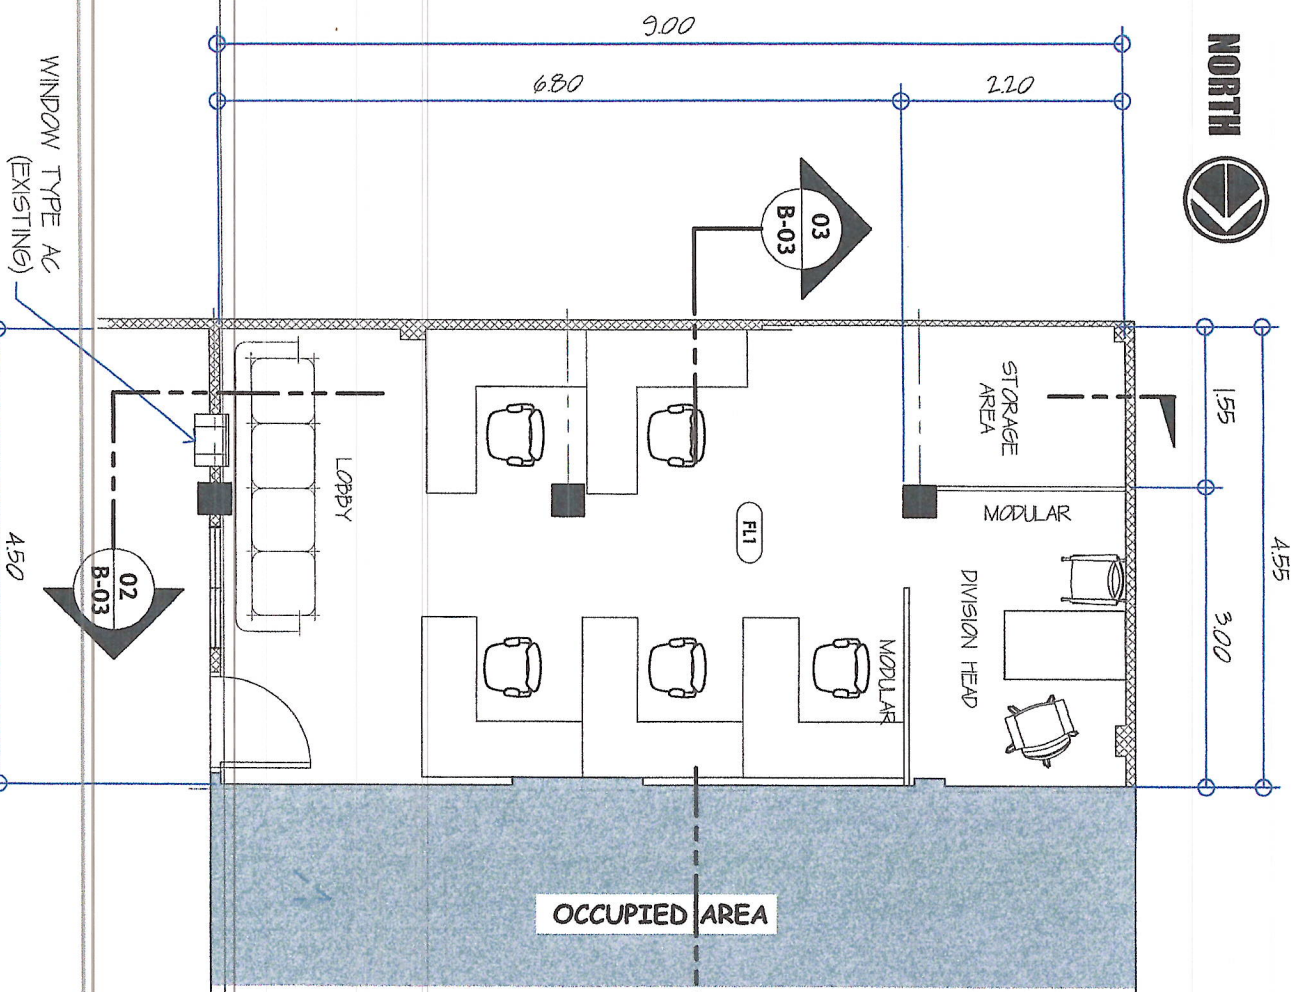


<p>GENERAL SANTOS CITY WATER DISTRICT E. FERNANDEZ STREET, BRGY. LAGA, GEN. SANTOS CITY ENGINEERING & CONSTRUCTION DEPARTMENT PLANNING AND DESIGN DIVISION TEL. NO.: (083) 582-3824</p>		<p>DANILO M. TORILADOR, JR. CIVIL ENGINEER REG. NO. 0107545 TIN. NO. 291-941-997</p>		<p>RENOVATION OF OLD METER ROOM FOR FINANCE OFFICE</p>		<p>ENGR. MARIA CELIA N. DANDAN DEPT. MANAGER, ECD</p>		<p>ENGR. ROBERTO A. BEBANA, JR. ACGM, OTS</p>		<p>FRANCISCO P. ALONSO, JR., CPA, CSEE ACTING GENERAL MANAGER</p>	
<p>PROJECT AND LOCATION</p>		<p>REVIEWED:</p>		<p>RECOMMEND/ APPROVAL:</p>		<p>APPROVED:</p>		<p>SHEET CONTENTS</p>		<p>SHEET NO.</p>	
<p>DATE:</p>		<p>DATE:</p>		<p>DATE:</p>		<p>DATE:</p>		<p>AS SHOWN</p>		<p>B-03</p>	
<p>LOCATION: E. FERNANDEZ ST. LAGA, GSC</p>		<p>DEPT. MANAGER, ECD</p>		<p>ACGM, OTS</p>		<p>DATE: MAY 2024</p>		<p>CHECKED BY:</p>		<p>05</p>	

SCHEDULE OF FINISH


CEILING :

(GL-1) 10mm thk. PVC LAMINATED GYPSUM BOARD ON METAL FURRING CEILING FRAMES. USE 0.60mm thk. x 15mm x 50mm x 5000mm FURRING CHANNELS @ 600mm ON CENTER W/ 0.60mm thk. x 38mm x 5000mm MAIN CHANNEL @ 600mm ON CENTER & ROP JOINER (HANGER/SUPPORTS) @ 1200mm O.C., SHORTER SPAN


03 PERSPECTIVE (CEILING CL-1)
NOT TO SCALE

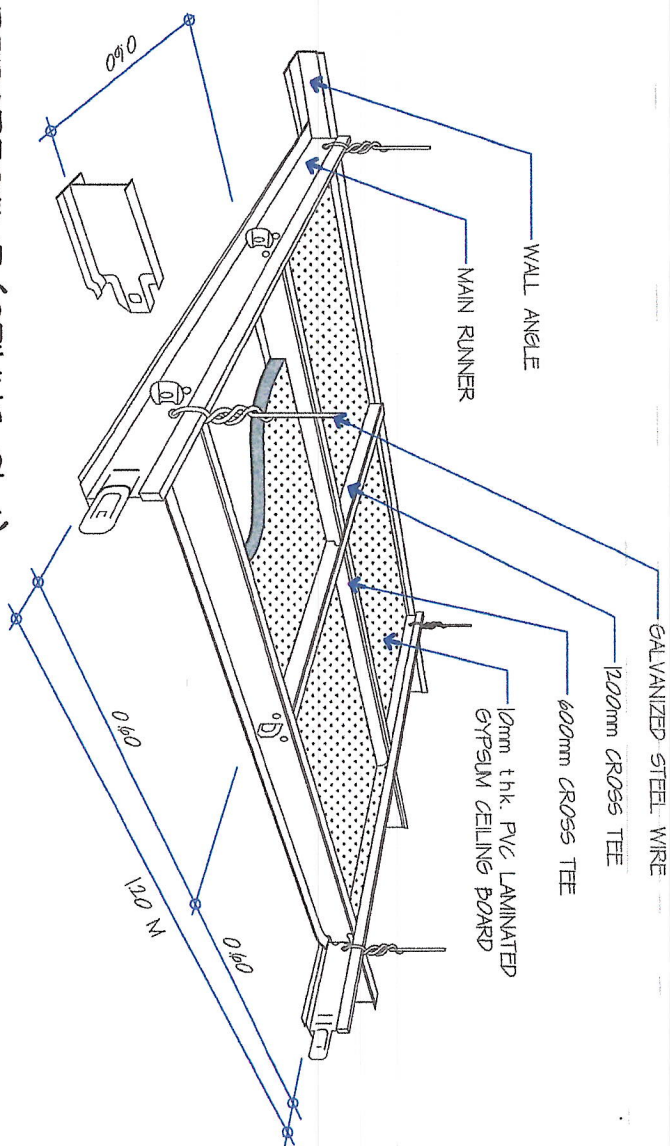

01 FRONT ELEVATION
SCALE: 1/75 M

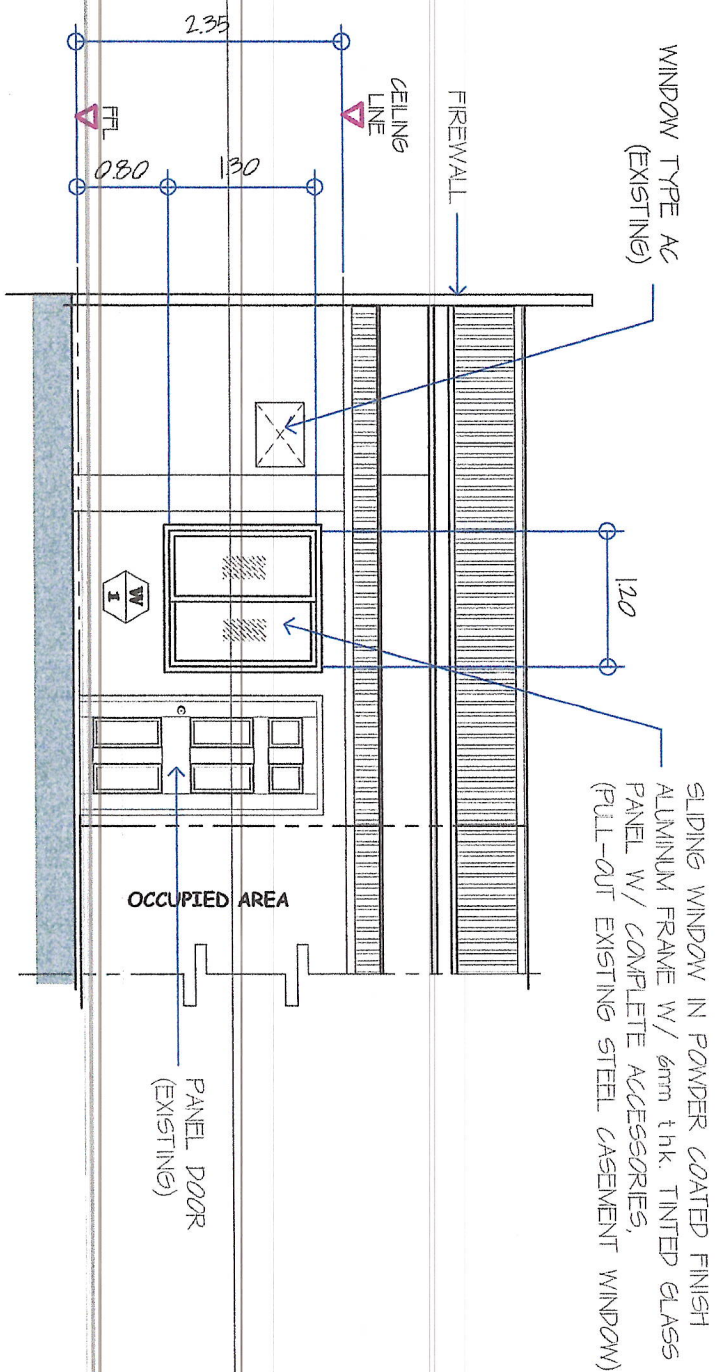

02 REFLECTED CEILING PLAN
SCALE: 1/75 M

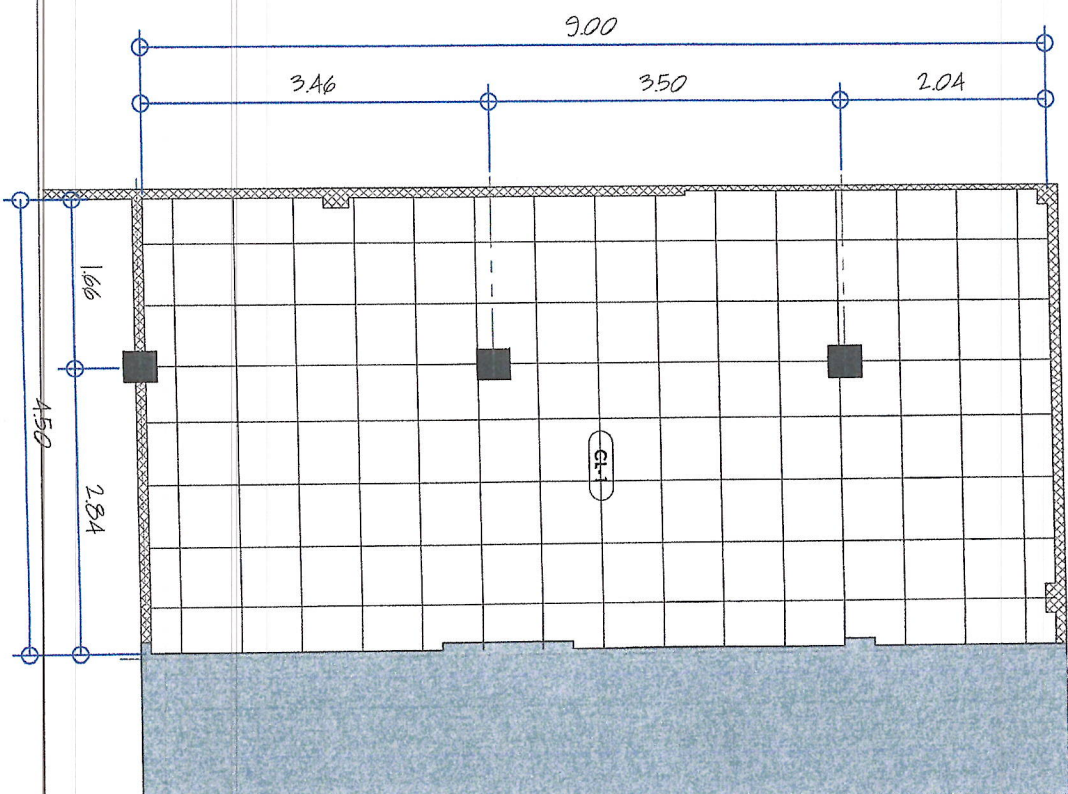

DANILOR HORLADOR, JR.
CIVIL ENGINEER
REG. NO. 0107545
TIN. NO. 291-941-997
DATE:

PROJECT AND LOCATION
RENOVATION OF OLD METER ROOM FOR FINANCE OFFICE
LOCATION : E. FERNANDEZ ST. LAGA, GSC

REVIEWED:
ENGR. MARIA CELIA N. DANDAN
DEPT. MANAGER, ECD

RECOMMEND APPROVAL:
ENGR. ROGELIO A. BESANA, JR.
LACM, OTS

APPROVED:
FRANCISCO R. ALACAP, JR., CPA, CEEB
ACIN, GENERAL MANAGER

SHEET CONTENTS		SHEET NO.	
AS SHOWN		B-04	05
DRAWN BY: <i>Danilor</i>	REV. NO.	04	
CHECKED BY:	DATE: May 2024		



GENERAL SANTOS CITY WATER DISTRICT
 E. FERNANDEZ STREET, BRGY. LAGA, GEN. SANTOS CITY
 ENGINEERING & CONSTRUCTION DEPARTMENT
 PLANNING AND DESIGN DIVISION
 TEL. NO.: (083) 582-3824

REG. NO. 0107345
 P.R. NO. _____
 DATE: _____

DANILO M. TORILADOR, JR.
 CIVIL ENGINEER

PROJECT AND LOCATION
 RENOVATION OF OLD METER ROOM FOR FINANCE OFFICE
 LOCATION: E. FERNANDEZ ST. LAGA, GSC

REVIEWED:
 ENGR. MARIA CELIA N. DANDAN
 DEPT. MANAGER, ECD


RECOMMEND APPROVAL:
 ENGR. ROGELIO A. BESANA, JR.
 AGM, OTS

APPROVED:
 FRANCISCO R. ALDOD, JR., CPA CESE
 ACTING GENERAL MANAGER


SHEET CONTENTS
 As shown

SHEET NO.
 E-01

01 LIGHTING LAYOUT
 E-01 SCALE: 1:75 M

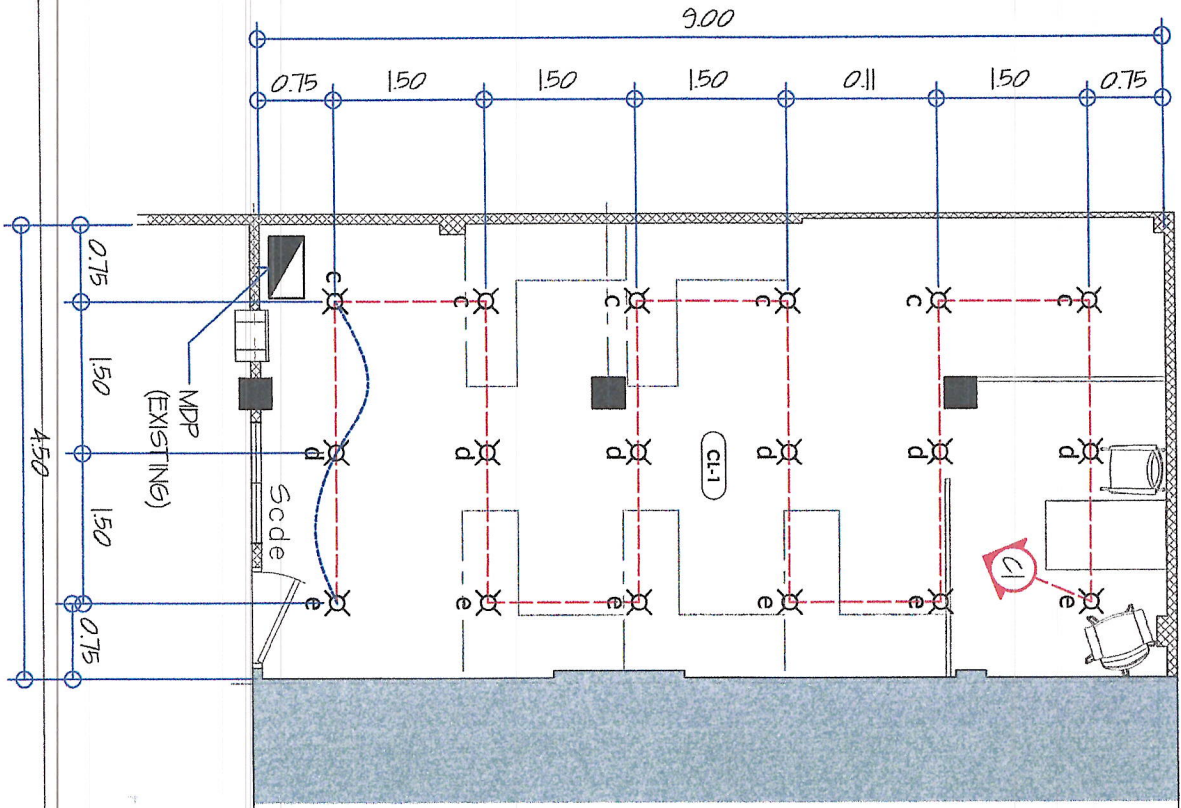

02 POWER LAYOUT
 E-01 SCALE: 1:75 M

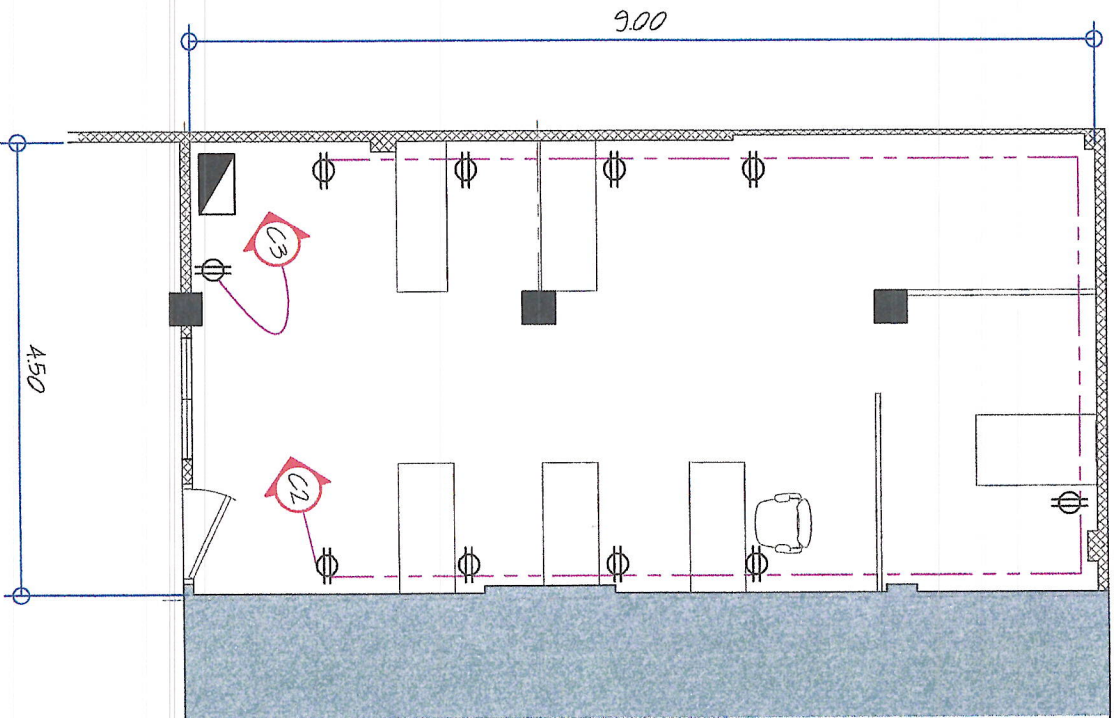

LEGEND

- 60W LED PANEL LIGHT, DOWNLIGHT
- DUPLEX CONVENIENCE OUTLET, 10 AMP, 250 VOLT W/ MODERN PLATE COVER
- MAIN DISTRIBUTION PANEL
- RACEWAY CONDUIT CONCEALED UNDER FLOOR
- CIRCUIT RUN
- RACEWAY CONDUIT CONCEALED IN CEILING
- HOMERUN DIRECT TO PANEL BOARD
- THREE GANG DEVICE SWITCH

Scode