




CABINET-1



CABINET-2




CABINET-3

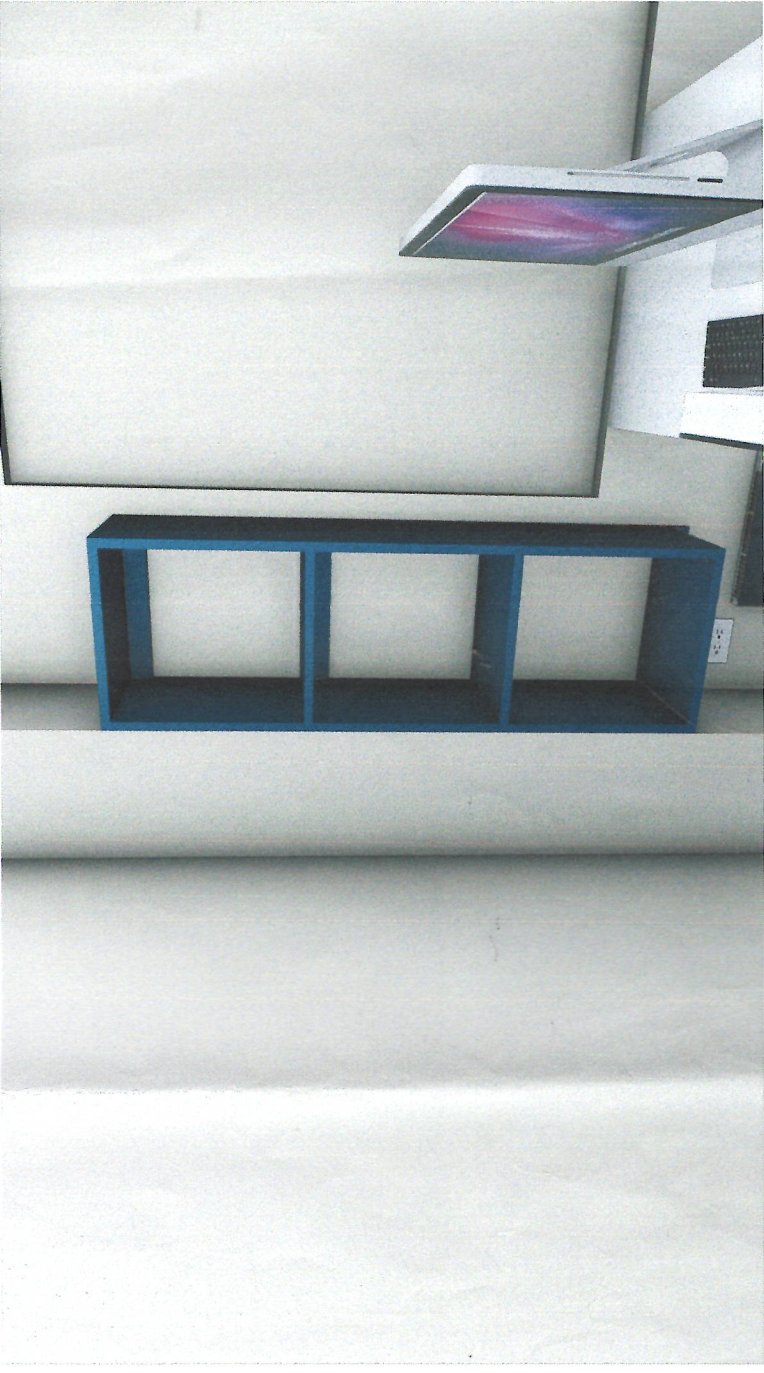


CABINET-4

01 **PERSPECTIVES** TO SCALE
B-01 NOT TO SCALE


<p>GENERAL SANTOS CITY WATER DISTRICT E. FERNANDEZ STREET, BRGY. LAGAO, GEN. SANTOS CITY ENGINEERING & CONSTRUCTION DEPARTMENT PLANNING AND DESIGN DIVISION TEL. NO. : (083) 552 - 3824</p>	PROJECT AND LOCATION	CHECKED BY	REVIEWED BY	RECOMMEND APPROVAL	APPROVED:	SHEET CONTENTS	SHEET NO.
	<p>RENOVATION & EXTENSION OF PDD OFFICE</p> <p>ADDRESS: GEORGE ADMIN. BLDG. E. FERNANDEZ ST., LAGAO</p>	<p>DANILO M. MORLADOR, JR., CE Project Planning & Development Officer A</p>	<p>ENGR. MARIA CELIA N. DANDAN Activity Department Manager, ECD</p>	<p>ENGR. ROGELIO A. BESANA, JR. Admin. Officer & Technical Services</p>	<p>FERNANDO S. FERRER, MPA Activity General Manager</p>	<p>AS SHOWN</p>	<p>B-01</p>
						<p>DRAWN BY: DOLIC-RAE CHECKED BY:</p>	<p>REV. NO. DATE: Aug 2022</p>

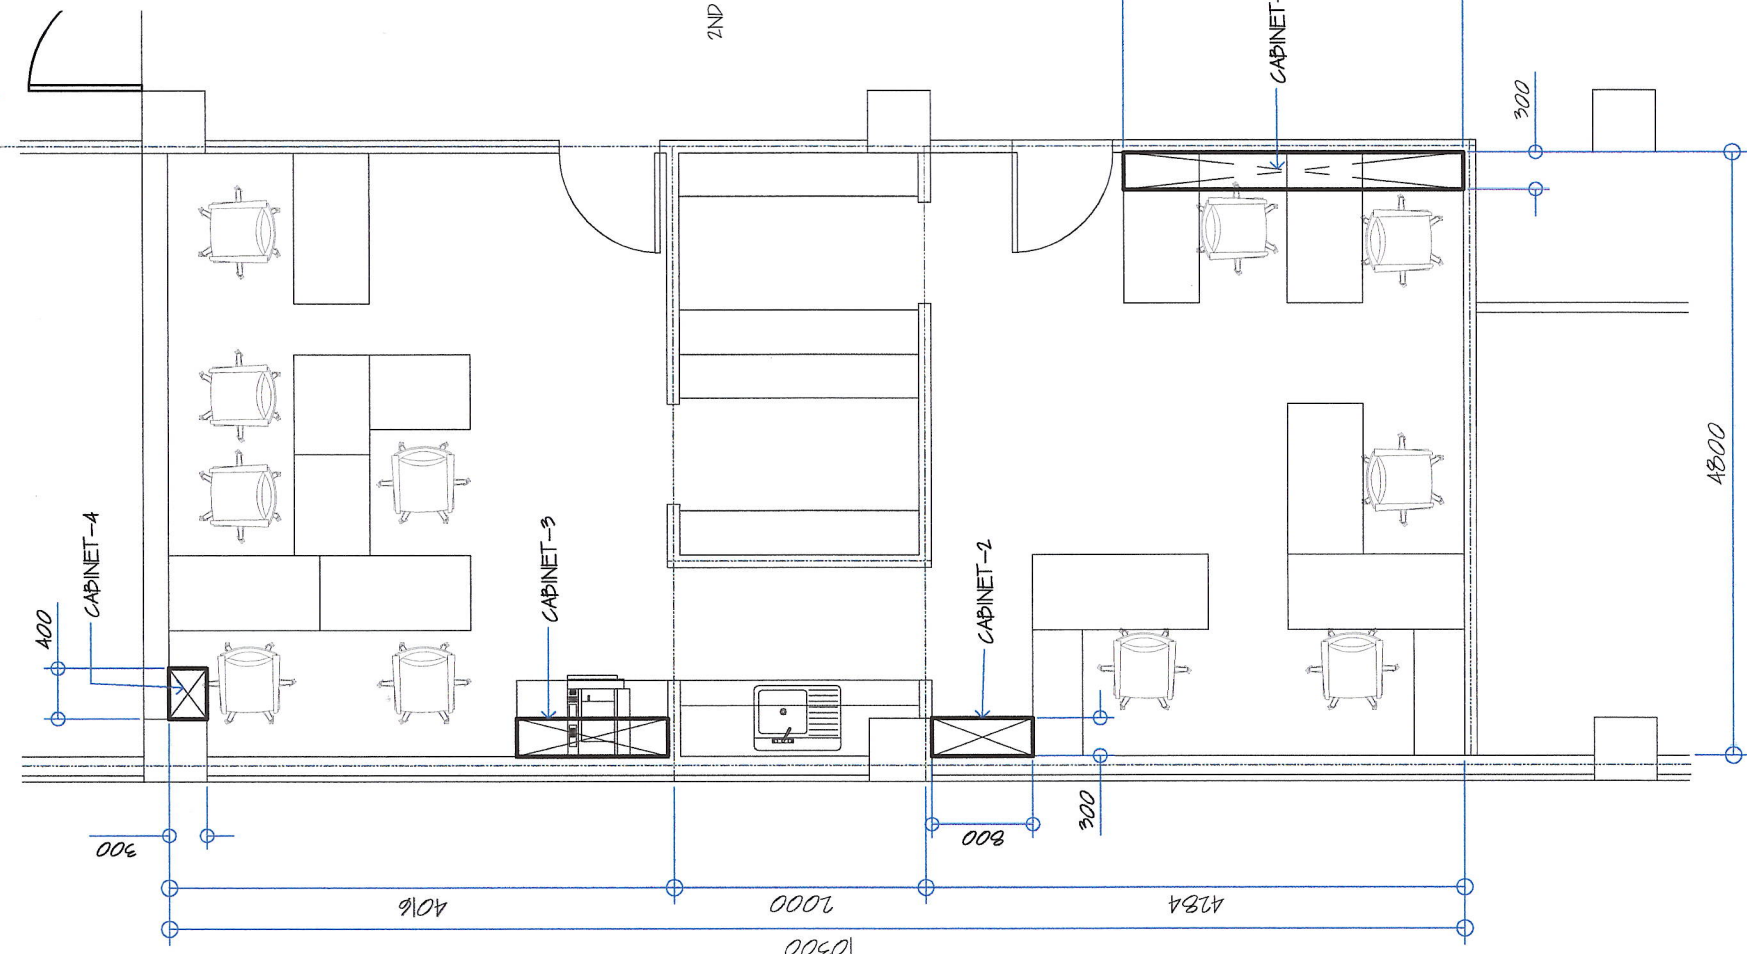


01 FLOOR PLAN
B-02 SCALE: 1 : 60 M

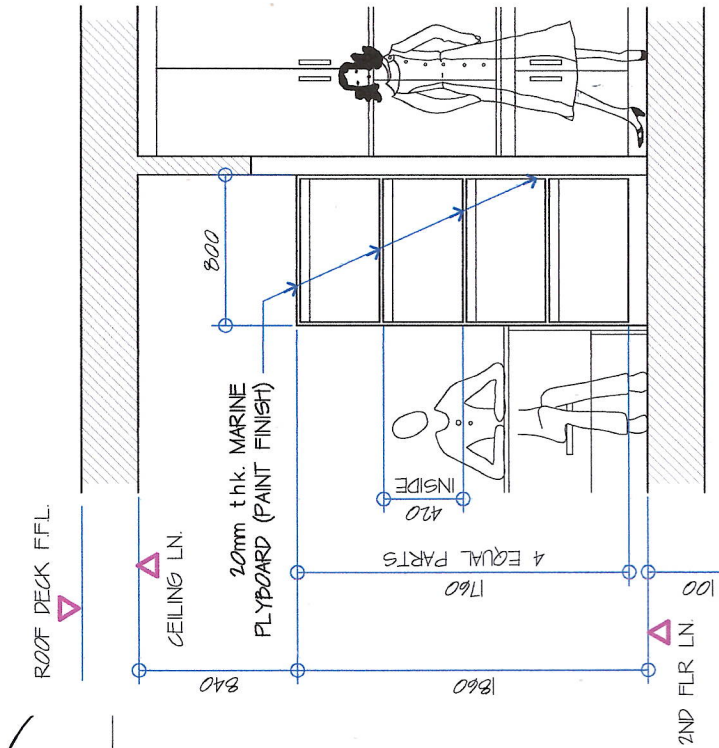


04 CABINET-2 ELEVATION
B-02 SCALE: 1 : 40 M

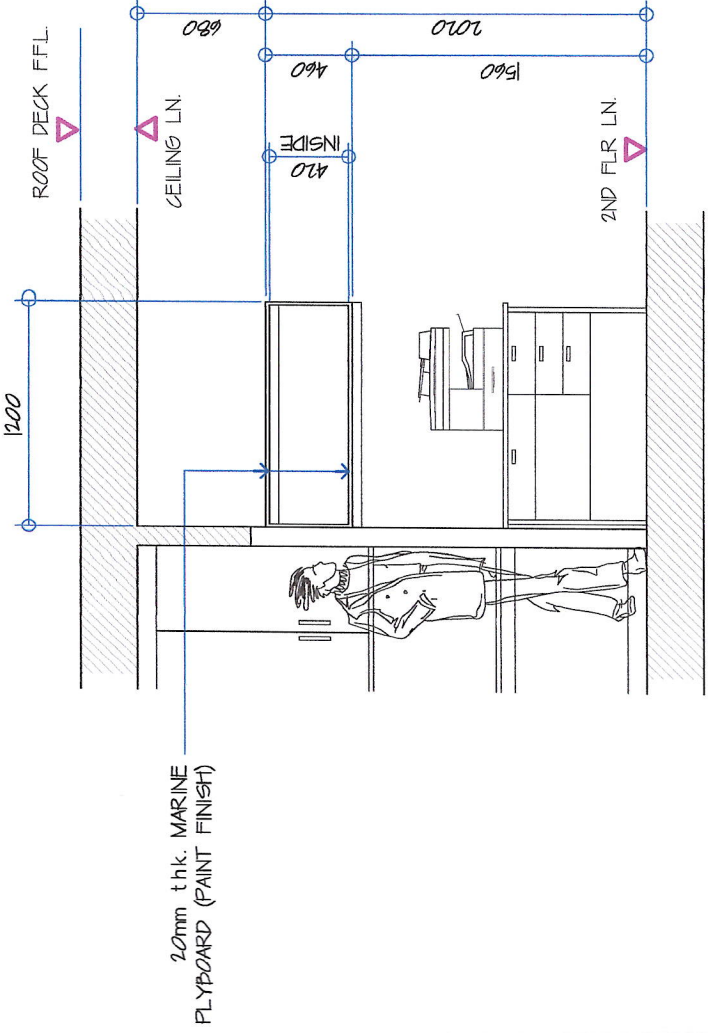

05 CABINET-3 ELEVATION
B-02 SCALE: 1 : 40 M

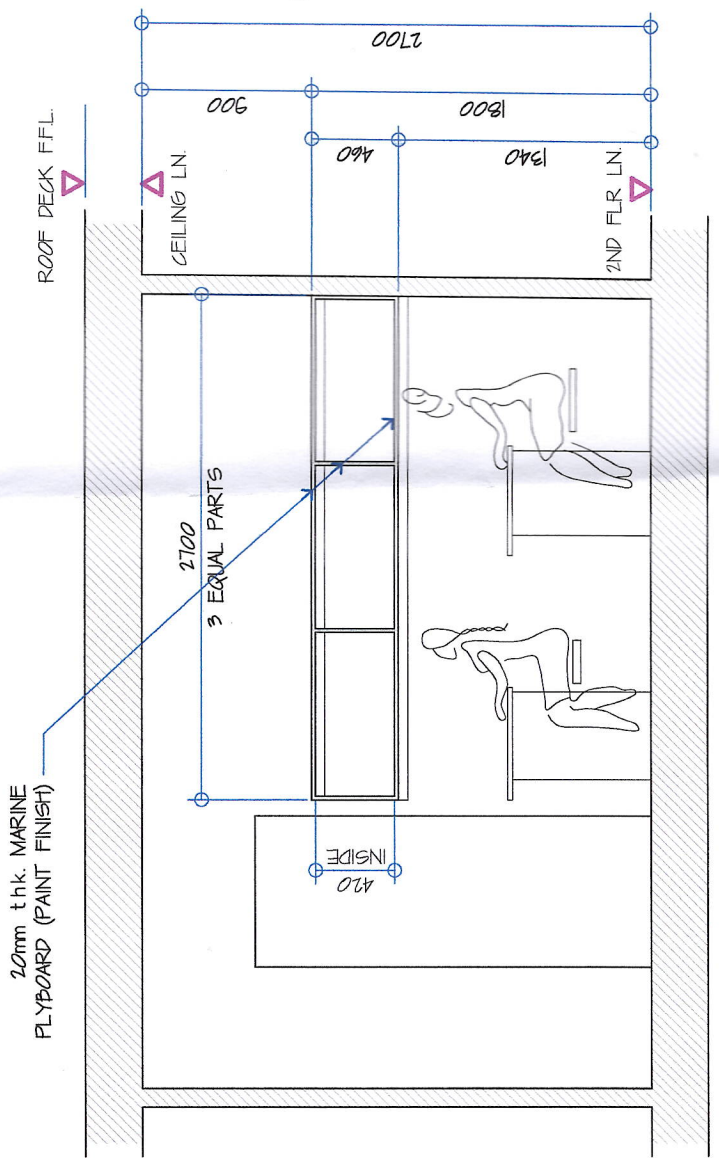

02 CABINET-1 ELEVATION
B-02 SCALE: 1 : 40 M

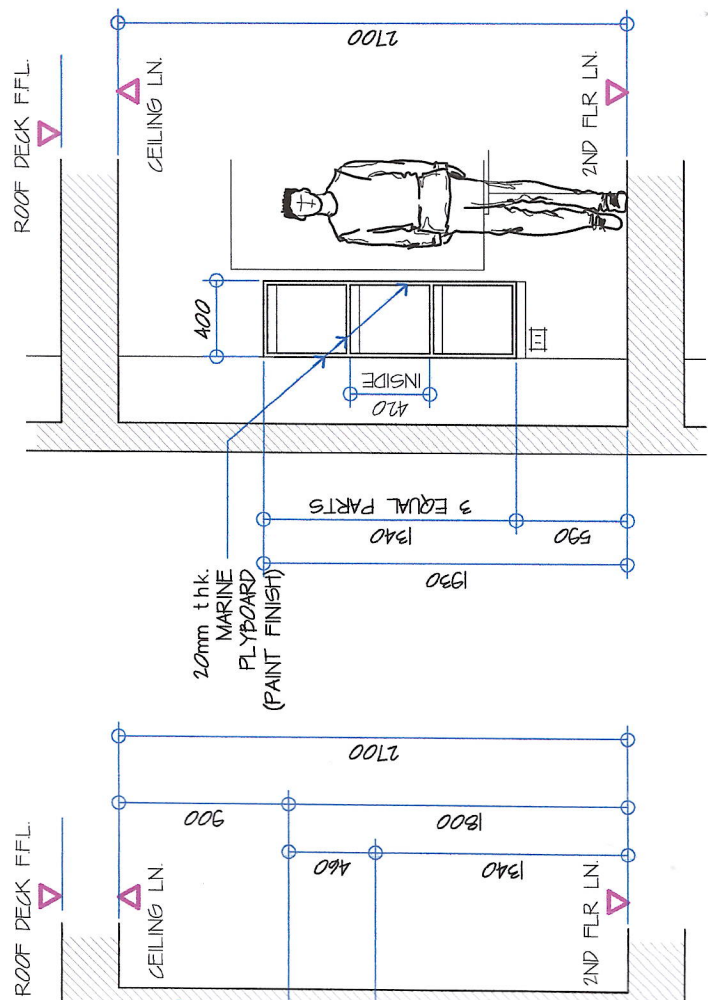

03 CABINET-4 ELEVATION
B-02 SCALE: 1 : 40 M

<p>GENERAL SANTOS CITY WATER DISTRICT E. FERNANDEZ STREET, BRGY. LAGAO, GEN. SANTOS CITY ENGINEERING & CONSTRUCTION DEPARTMENT PLANNING AND DESIGN DIVISION TEL. NO.: (083) 552-3824</p>	<p>PROJECT AND LOCATION</p> <p>FABRICATION & INSTALLATION OF PDD'S OFFICE CABINETS</p> <p>ADDRESS: 680MP ADMIN BLDG, E. FERNANDEZ ST., LAGAO</p>	<p>CHECKED BY:</p> <p><i>[Signature]</i></p> <p>DANILO M. HORLADOR, JR., CE Project Planning & Development Officer A</p>	<p>RECOMMEND APPROVAL:</p> <p><i>[Signature]</i></p> <p>ENGR. ROGELIO A. BESANA, JR. Acting Chief Engineer & Technical Services</p>	<p>APPROVED:</p> <p>FERDINAND S. FERRER, MPA Acting General Manager</p>	<p>SHEET CONTENTS</p> <p>A5 SHOWN</p>	<p>SHEET NO.</p> <p>B-02</p>
	<p>REVIEWED BY:</p> <p><i>[Signature]</i></p> <p>ENGR. MARIA CELIA N. DANDAN Acting Department Manager, ECD</p>	<p>DRAWN BY: RONALD RAE</p>	<p>REV. NO.</p> <p>02</p>	<p>DATE: July 2023</p>	<p>CHECKED BY:</p> <p>02</p>	<p>02</p>