


VICINITY MAP


SCALE: DRAWN NOT TO SCALE

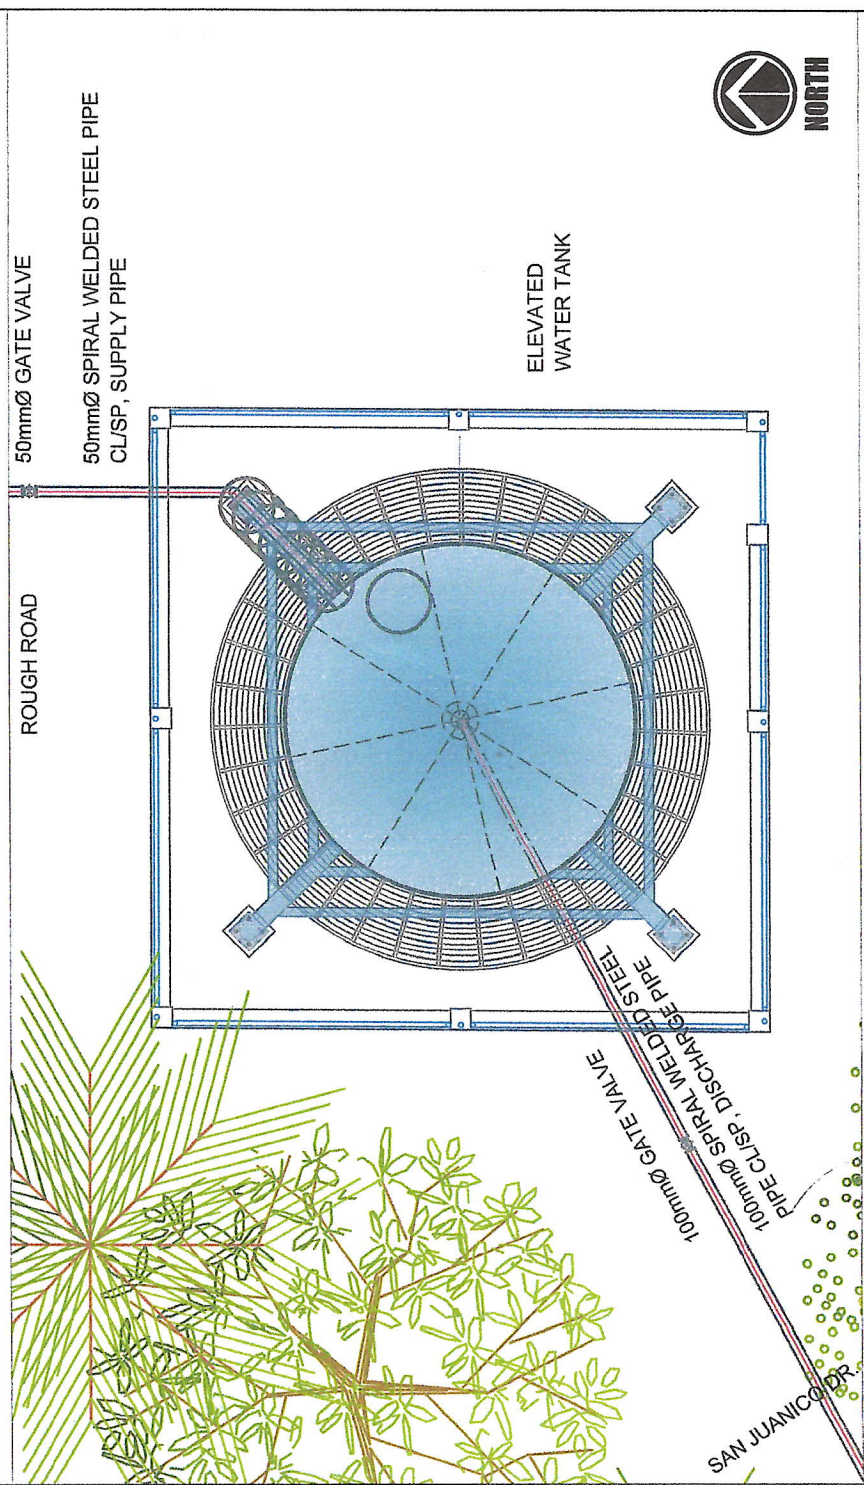

EXISTING SITE DEVELOPMENT PLAN


SCALE: 1:200

RECOMMENDED FOR APPROVAL BY:	APPROVED BY:	SHEET CONTENTS:	SHEET NO.:
		ASSHOWN	01
N. DANDAN, CE PLANT MANAGER - ECD	ROGELIO A. BESANA, JR., CE/RMP ASSISTANT GENERAL MANAGER - OTS	PREPARED BY: JKD	DATE: AUG. 28, 2023
	FERDINAND S. FERRER, MPA ACTING GENERAL MANAGER	REV. NO. 00	

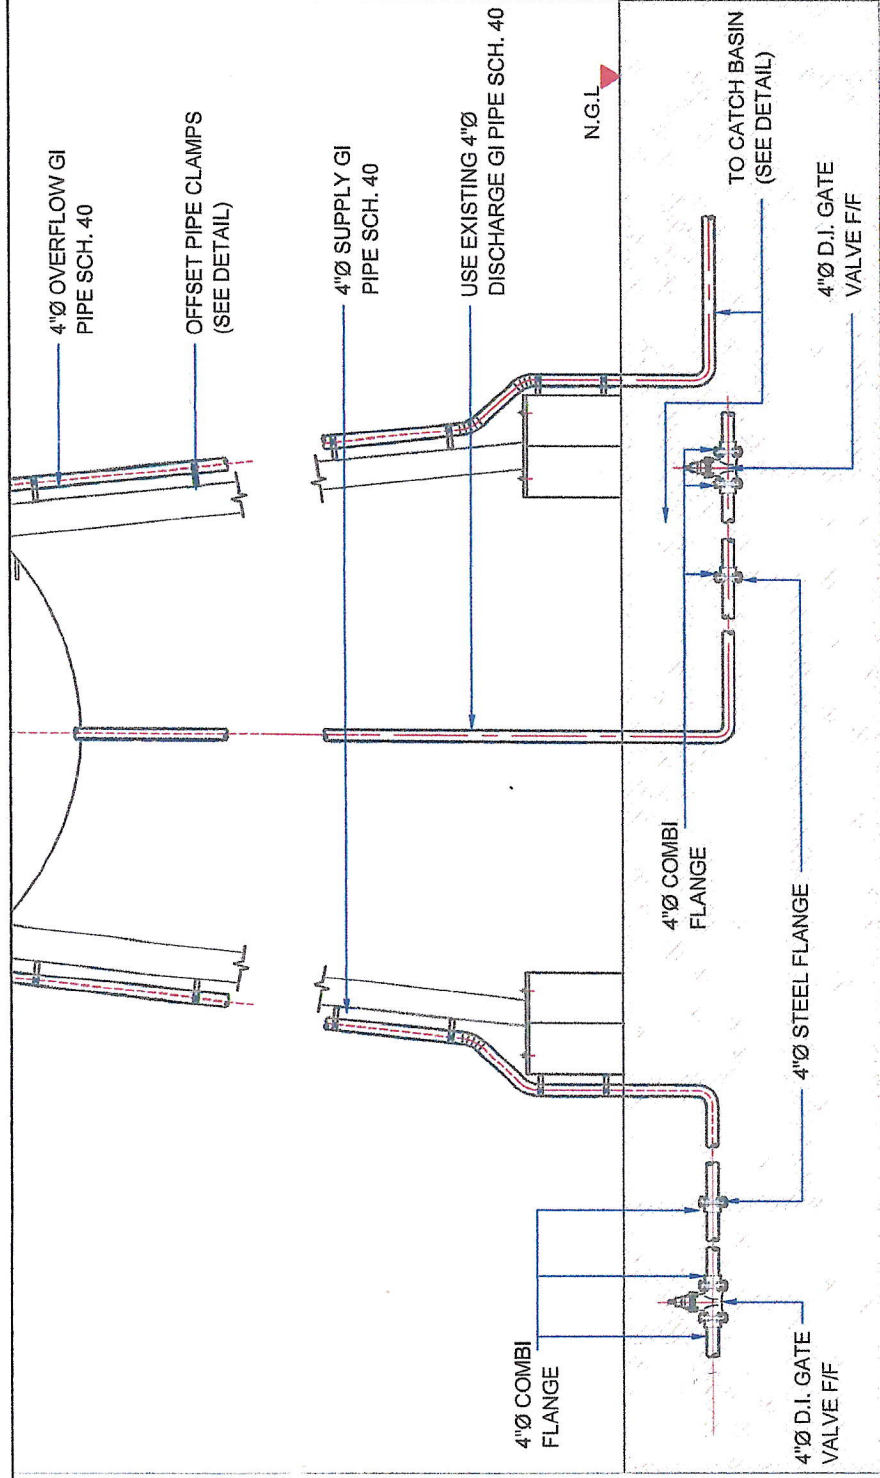


NEW SUPPLY AND OVERFLOW DETAIL 2

SCALE: 1:62.5

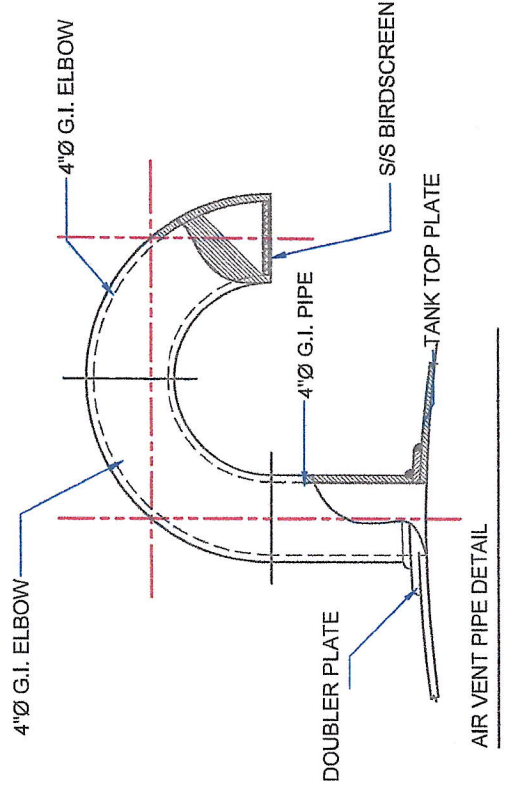

1:10

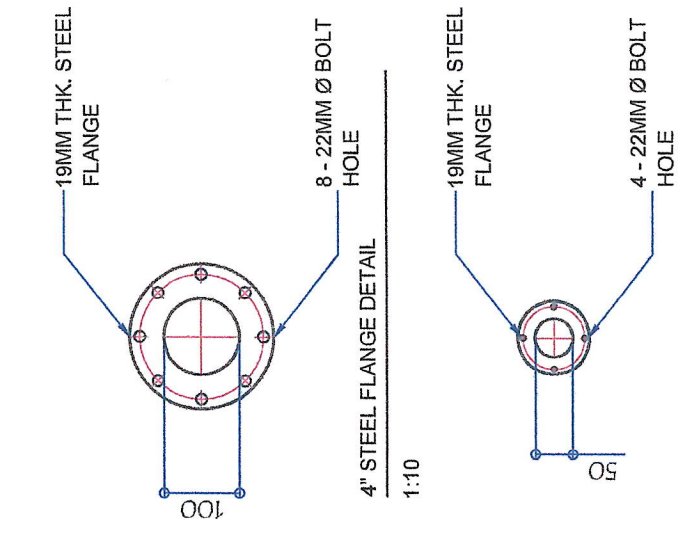


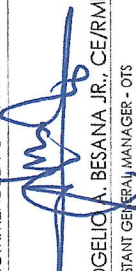
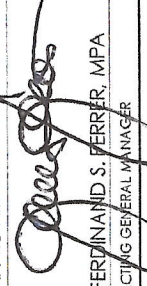
1:10


2\"/>

1:10

AIR VENT & STEEL FLANGE DETAIL


SCALE: 1:10

 N. DANDAN, CE ASSISTANT GENERAL MANAGER - ECD	 ROGELIO A. BESANA JR., CE/RMP ASSISTANT GENERAL MANAGER - OTS	 FERDINAND S. FERRER, MPA ACTING GENERAL MANAGER	SHEET CONTENTS:	AS SHOWN	SHEET NO.:	03
			RECOMMENDED FOR APPROVAL BY:	APPROVED BY:	PREPARED BY:	DATE:
			JKD	AUG. 23, 2023		

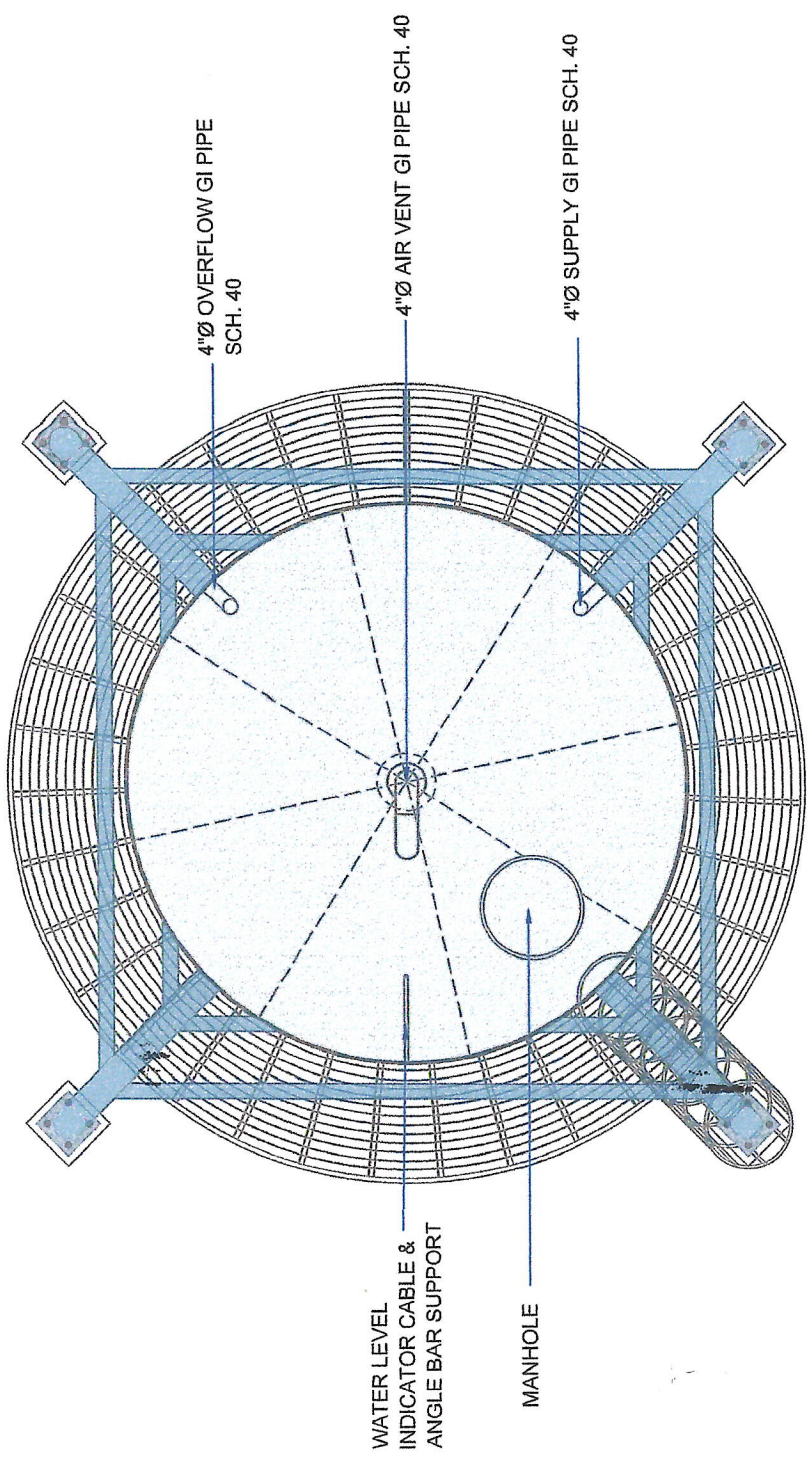




WATER TANK PLAN

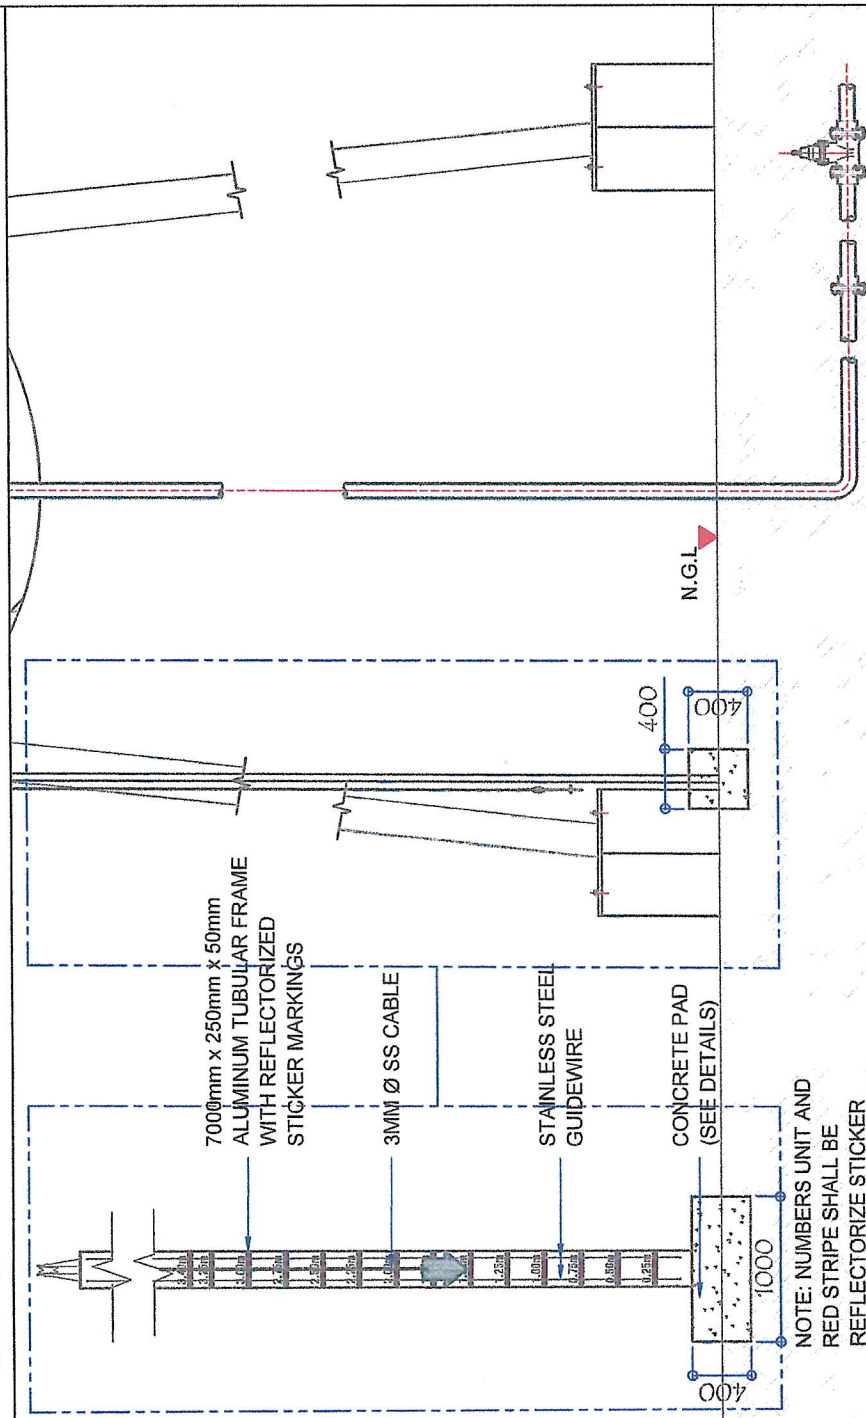SCALE: 1:50



WATER LEVEL INDICATOR DETAIL 02

SCALE: 1:50

 A. N. DANDAN, CE PROJECT MANAGER - ECD	RECOMMENDED FOR APPROVAL BY: 	APPROVED BY: 	SHEET CONTENTS: AS SHOWN	SHEET NO.: 04
	PREPARED BY: JKD	DATE: AUG. 23, 2023	REV. NO. 00	

6700

1000

2060

NEW BARBED WIRE

REPAINT STEEL MATTING AND CONCRETE

N.G.L. 



REPAIRING OF PERIMETER FENCE (FRONT ELEVATION)

SCALE: 1/50

4" D.I. DISTRIBUTION PIPE

4" Ø D.I. GATE

VALVE F/F

4" Ø SUPPLY uPVC PIPE


PIPE INTERCONNECTION TO DISTRIBUTION LINE BY GSCWD . CONTRACTOR TO PROVIDE 4" Ø STEEL FLANGE FOR SUPPLY AND DISTRIBUTION CONNECTION

4" Ø STEEL FLANGE & 4" Ø COMBI FLANGE (SEE DETAIL)

EXISTING 4" Ø SUPPLY GI PIPE SCH. 40

4" Ø DIA. PVC SANITARY PIPE - 1000 SERIES TO LOCAL DRAINAGE

4" Ø DIA. OVERFLOW GI PIPE SCH. 40 - CONNECT TO SANITARY PIPE USING COMBI FLANGE

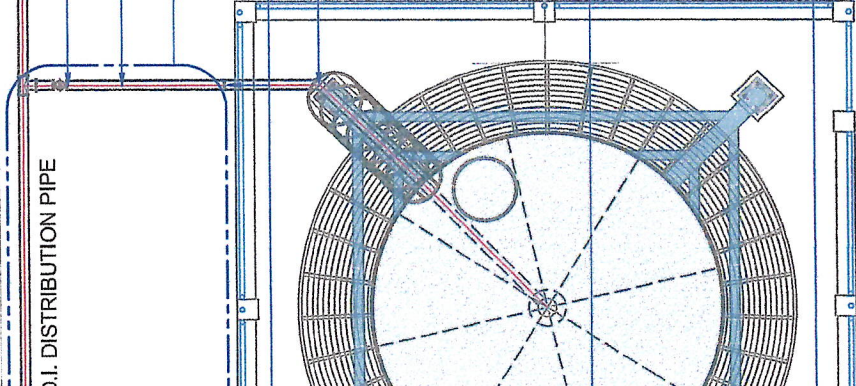


RECOMMENDED FOR APPROVAL BY: APPROVED BY:

SHEET CONTENTS:

SHEET NO.:


N. DANDAN, CE
PLANT MANAGER - ECD


ROGELIO A. BESANA JR., CE/RMP
ASSISTANT GENERAL MANAGER - OTS


FERDINAND S. FERRER, MPA
ACTING GENERAL MANAGER


AS SHOWN

PREPARED BY:
JKD

DATE:
AUG. 23, 2023


REV. NO. 00

05

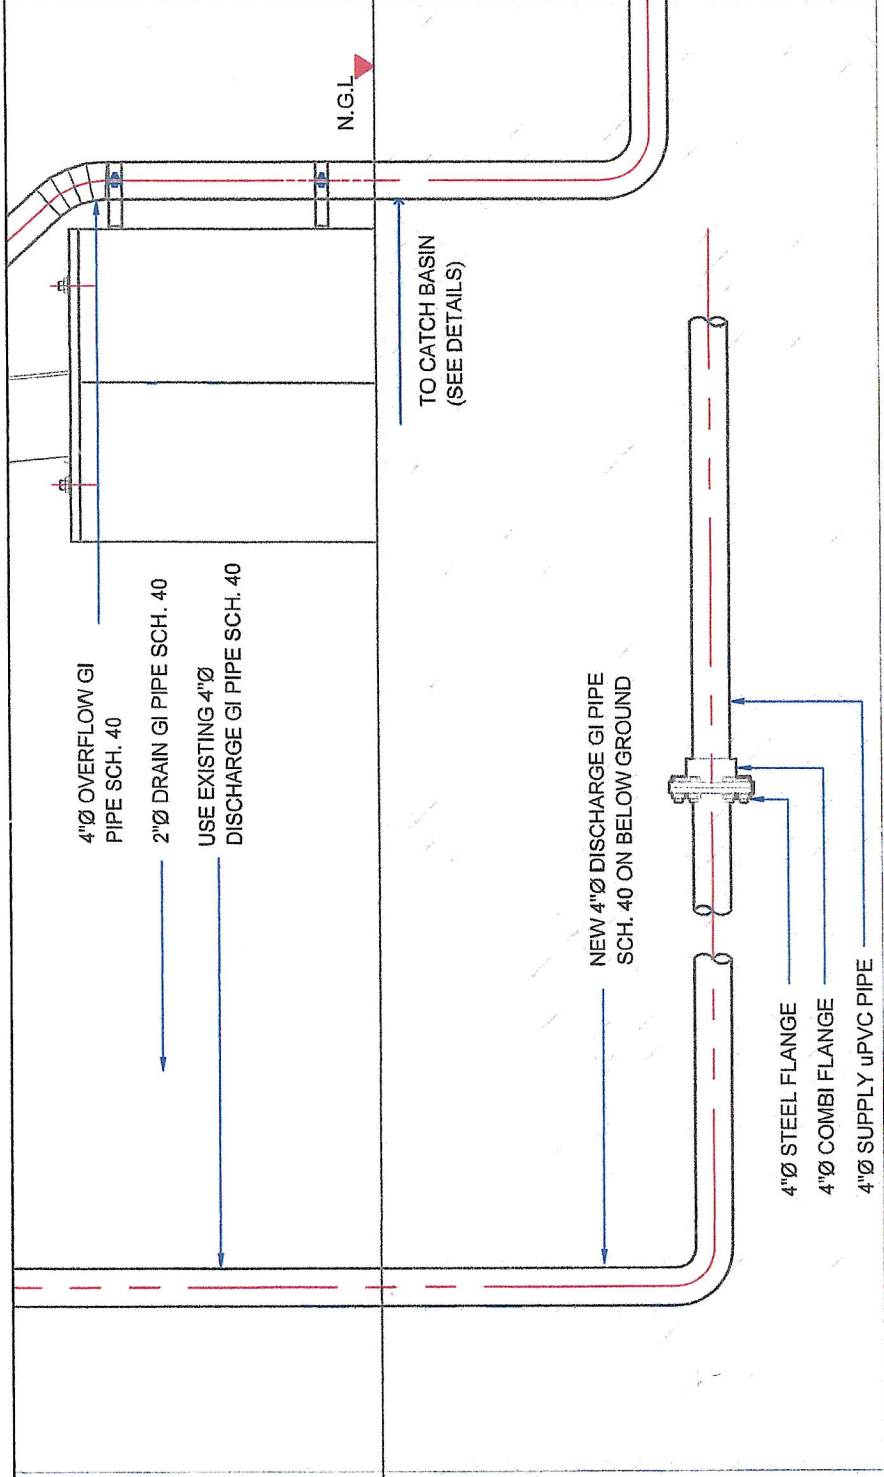

DISCHARGE PIPE DETAILS

SCALE: 1:20

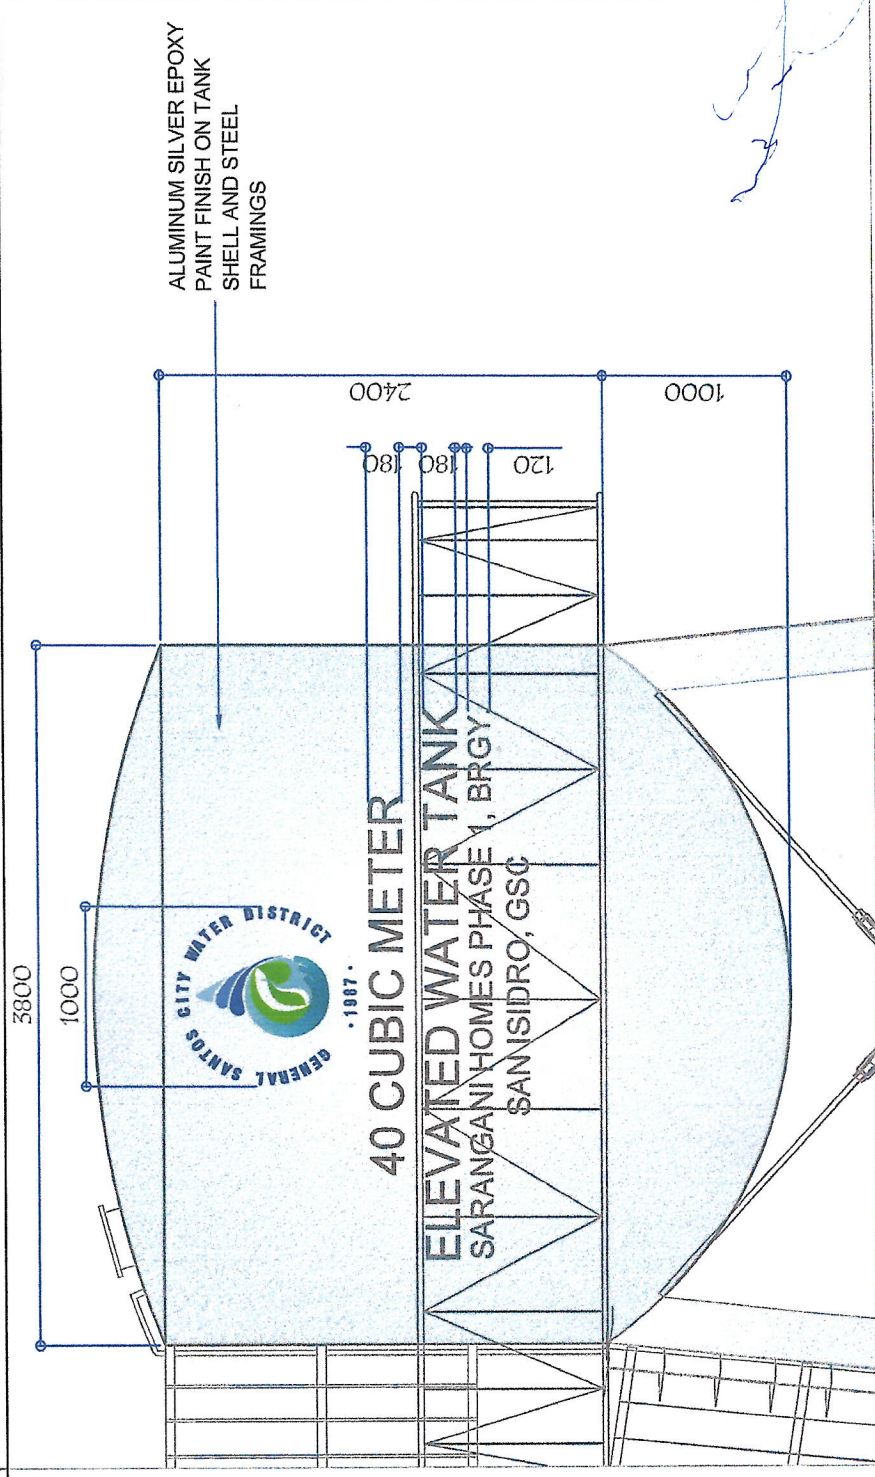

LOGO & SIGNAGE PAINTING DETAILS

SCALE: 1:40

RECOMMENDED FOR APPROVAL BY:	APPROVED BY:	SHEET CONTENTS:	SHEET NO.:
		AS SHOWN	06
ROGELIO A. BESANA JR., CE/RMP ASSISTANT GENERAL MANAGER - OIS	FERDINAND S. FERRER, MPA ACTING GENERAL MANAGER	PREPARED BY: JKD	REV. NO. 00
		DATE: AUG. 23, 2023	


A. N. DANDAN, CE
GENERAL MANAGER - ECD

GENERAL SANTOS CITY WATER DISTRICT
• 1987 •
ELEVATED WATER TANK
SARANGANI HOMES PHASE 1, BRGY.
SAN ISIDRO, GSC


ALUMINUM SILVER EPOXY
PAINT FINISH ON TANK
SHELL AND STEEL
FRAMINGS

TO CATCH BASIN
(SEE DETAILS)

N.G.L.

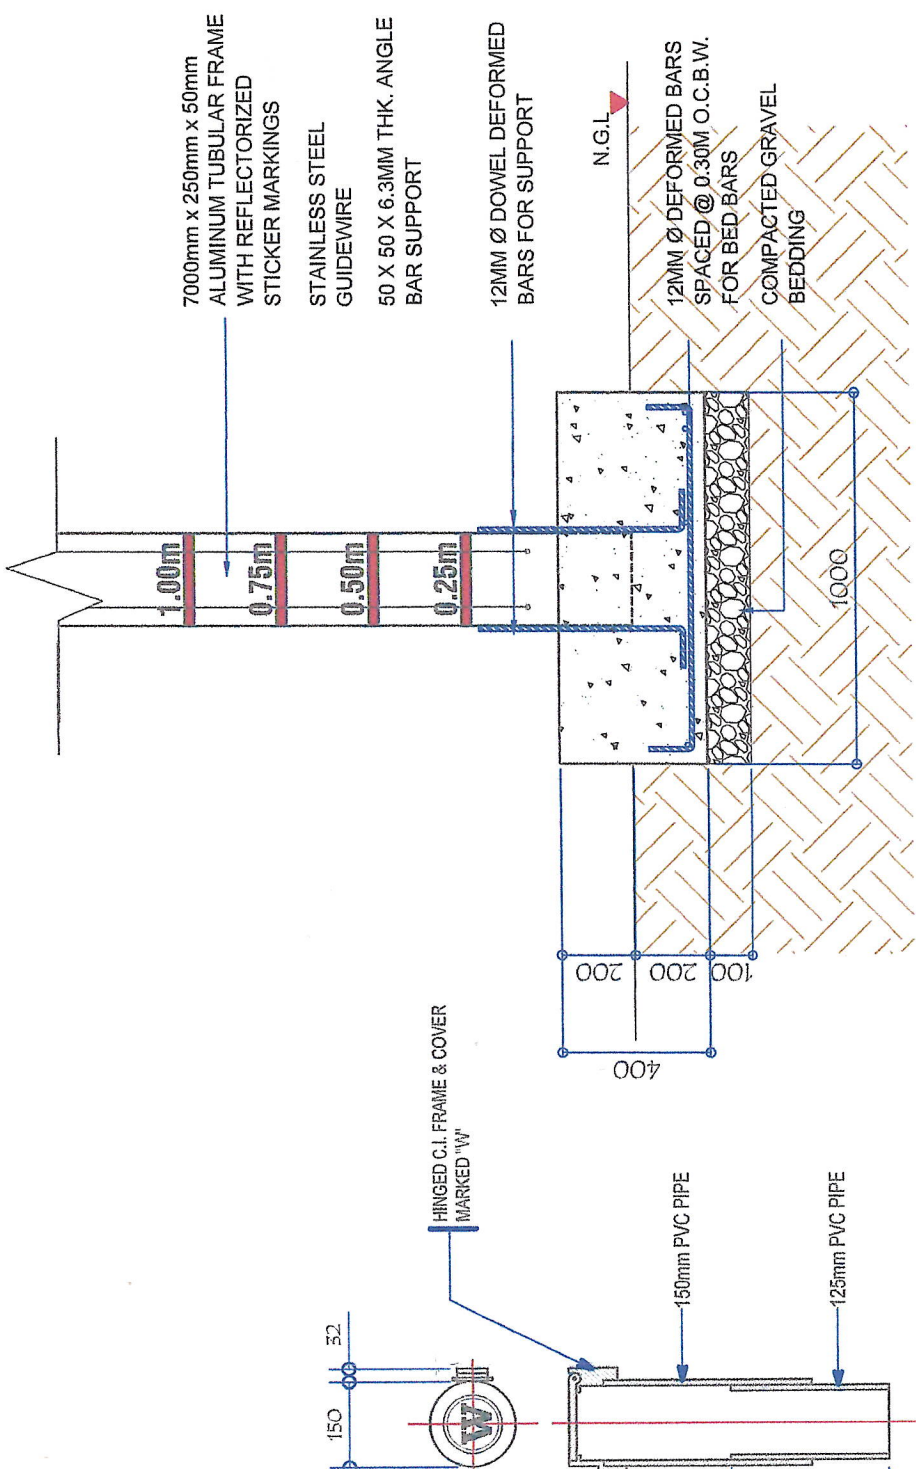

WATER INDICATOR CONCRETE PAD DETAILS

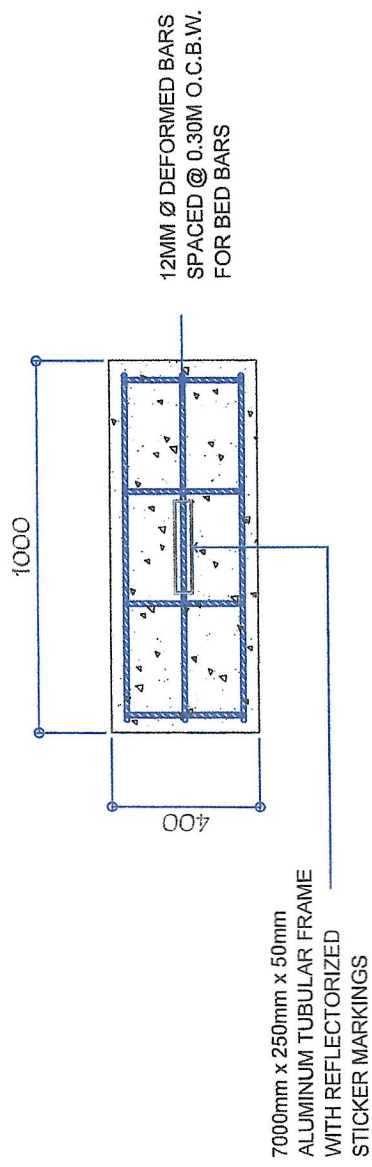

WATER INDICATOR CONCRETE PAD DETAILS

SCALE: NTS

 A. N. DANDAN, CE ASSTANT GENERAL MANAGER - ECD	RECOMMENDED FOR APPROVAL BY:	APPROVED BY:	SHEET CONTENTS:	SHEET NO.:
	 ROGELIO A. BESANA JR., CE/RMP ASSISTANT GENERAL MANAGER - OTS	 FERDINAND S. FERRER, MPA ACTING GENERAL MANAGER	AS SHOWN	07
			PREPARED BY: JFD DATE: AUG. 23, 2023	REV. NO. 00